



# **KARACHI NEIGHBORHOOD IMPROVEMENT PROJECT (KNIP)**

## **PACKAGE-2**

# **REDEVELOPMENT OF KAKRI SPORTS COMPLEX AND NEIGHBORHOOD IMPROVEMENT**


## **ELECTRICAL DRAWINGS TENDER DRAWINGS**

SEPTEMBER - 2021



**G3 ENGINEERING CONSULTANTS (PVT.) LTD.**

Consulting Engineers – Architects – Planners

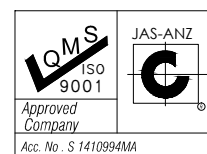

ISO 2000-9001

CERTIFIED

COMPANY

LIST OF DRAWINGS  
ELECTRICAL DRAWINGS

S.NO	DRAWING DETAIL	DRAWING NO.	S.NO	DRAWING DETAIL	DRAWING NO.
1.	LIST OF DRAWING	0249/PG/000	34.	PARK ILLUMINATION LAYOUT	0249/PARK/035
2.	MAIN LEGENDS	0249/PG/001	35.	PARK POWER DISTRIBUTION LAYOUT	0249/PARK/036
3.	PLAY GROUND ILLUMINATION LAYOUT	0249/PG/002	36.	PARK CCTV LAYOUT	0249/PARK/037
4.	GENERAL PARK ILLUMINATION LAYOUT	0249/PG/003	37.	PARK PUBLIC ADDRESS SYSTEM	0249/PARK/038
5.	PLAY GROUND POWER DISTRIBUTION SYSTEM	0249/PG/004	38.	TOILET BLOCK ILLUMINATION LAYOUT	0249/PARK/039
6.	GENERAL PARK POWER DISTRIBUTION SYSTEM	0249/PG/005	39.	SINGLE LINE DIAGRAM	0249/PARK/040
7	PLAY GROUND CCTV LAYOUT	0249/PG/006	40.	LIGHTING DETAILS	0249/PARK/041
8	GENERAL GROUND CCTV LAYOUT	0249/PG/007			
9	PLAY GROUND PUBLIC ADDRESS SYSTEM	0249/PG/008			
10	PURPOSED MULTIPURPOSE HALL BASEMENT ILLUMINATION LAYOUT	0249/MPH/009			
11	PURPOSED MULTIPURPOSE HALL GROUND FLOOR ILLUMINATION LAYOUT	0249/MPH/010			
12	PURPOSED MULTIPURPOSE HALL FIRST FLOOR ILLUMINATION LAYOUT	0249/MPH/011			
13	PURPOSED MULTIPURPOSE HALL GROUND FLOOR POWER DISTRIBUTION LAYOUT	0249/MPH/012			
14	PURPOSED MULTIPURPOSE HALL FIRST FLOOR POWER DISTRIBUTION LAYOUT	0249/MPH/013			
15	PURPOSED MULTIPURPOSE HALL GROUND FLOOR FIRE ALARM SYSTEM	0249/MPH/014			
16	PURPOSED MULTIPURPOSE HALL FIRST FLOOR FIRE ALARM SYSTEM	0249/MPH/015			
17	EXISTING GYMNASIUM GROUND FLOOR ILLUMINATION LAYOUT	0249/EMPH/016			
18	EXISTING GYMNASIUM FIRST FLOOR ILLUMINATION LAYOUT	0249/EMPH/017			
19	EXISTING GYMNASIUM POWER DISTRIBUTION LAYOUT	0249/EMPH/018			
20	BOXING ARENA ILLUMINATION LAYOUT	0249/BA/019			
21	BOXING ARENA POWER DISTRIBUTION LAYOUT	0249/BA/020			
22	BOXING ARENA PUBLIC ADDRESS SYSTEM & CCTV LAYOUT	0249/BA/021			
23	BOXING ARENA FIRE ALARM SYSTEM	0249/BA/022			
24	STADIA ILLUMINATION LAYOUT	0249/ST/023			
25	STADIA POWER DISTRIBUTION SYSTEM	0249/ST/024			
26	STADIA FIRE ALARM SYSTEM	0249/ST/025			
27	EXISTING STADIA ILLUMINATION LAYOUT	0249/ST/026			
28	EXISTING STADIA POWER DISTRIBUTION LAYOUT	0249/ST/027			
29	UNION COUNCIL ILLUMINATION LAYOUT	0249/UCO/028			
30	UNION COUNCIL POWER DISTRIBUTION LAYOUT	0249/UCO/029			
31	PLAY GROUND BOUNDARY WALL	0249/BW/030			
32	PLAY GROUND ENTRANCE GATE	0249/EG/031			
33.	FISH MARKET ILLUMINATION LAYOUT	0249/FM/032			

CLIENT:

 PROJECT  
IMPLEMENTATION  
UNIT (PIU) KNIP

 CONSULTANTS:  
G3 ENGINEERING  
CONSULTANTS (PVT)LTD.  
House No.57-M Gulberg-III, Lahore, Pakistan  
Tel : (92-42) 35441641, 35441642  
Fax : (92-42) 35441645  
E-mail : info@g3ec.com  
URL : www.g3ec.com

PROJECT:  
**Karachi Neighbourhood  
Improvement Project (KNIP)**

SUB PROJECT:  
**Redevelopment of Kakri Sports  
Complex and Neighborhood  
Improvement**

NOTES:  
1. ALL DIMENSIONS ARE IN FEET UNLESS  
OTHERWISE SPECIFIED.  
2. THIS DRAWING IS AN INTELLECTUAL PROPERTY  
OF G3 ENGINEERING CONSULTANTS (PVT.) LTD.  
AND CANNOT BE REPRINTED OR REPRODUCED  
WITHOUT PRIOR APPROVAL OF G3.

REVISIONS:		
No.	DESCRIPTION	DATE

TENDER DRAWINGS


 








DRAWING TITLE:

LIST OF DRAWINGS


 







DRAWN BY: M.Raffeh	DATE: SEP 2021
CHECKED BY: Eng.Ghulam Daraz Shaikh	
APPROVED BY: Syed Ali Abbas Gillani	
DRAWING NO: 0249/PG/000	REV: 0
SCALE (A3): N.T.S	SHEET: 1/11

# MAIN LEGEND






## LIGHT FIXTURES

\$.\$NO	SYMBOLS	DESCRIPTION
1		POST TOP LED LIGHT
2		ARCHITECTURAL POLE
3		SINGLE ARM POLE
4		DOUBLE ARM POLE
5		OUTDOOR GARDEN SPIKE LIGHT
6		LED FLOOD LIGHT 100 WATT
7		DOWN LIGHT FIXTURE WITH 10WATT SMD LAMP
8		LED BOLLARD LIGHT
9		
10		WATER TIGHT WALL BRACKET LIGHT


 


## WIRING ACCESSORIES

\$.\$NO	SYMBOLS	DESCRIPTION	MOUNTING HEIGHT
1		10 AMPS, ONE WAY AND TWO WAYS GANG TYPE SWITCH NUMBER OF SWITCHES ON SWITCH PLATE	3'-6" F.F.L
2		5 AMPS 3-PIN COMBINED SWITCH SOCKET	0'-9" F.F.L
3		5 AMPS 3-PIN COMBINED SWITCH SOCKET	3'-6" F.F.L
4		3 PIN FLAT SWITCH SOCKET 13 AMPS,	0'-9" F.F.L
5		15 AMPS 3-ROUND PIN SWITCH SOCKET	0'-9" F.F.L
6		15 AMPS 3-ROUND PIN SWITCH SOCKET	3'-6" F.F.L
7		WIRING IN 3/4" OR 1"DIA PVC CONDUIT	-IN WALL/ -BUF/BUG/ BIS
8		MEDICAL EQUIPMENT PANEL BOARD	4'-0" F.F.L OR AS REQ.
9		DISTRIBUTION BOARD FOR LIGHTING CIRCUIT & SMALL POWER	4'-0" F.F.L OR AS REQ.

## CLOSE CIRCUIT T.V SYSTEM

\$.\$NO	SYMBOLS	DESCRIPTION	MOUNTING HEIGHT
1		MONITOR	AS PER SITE
2		CLOSE CIRCUIT TV CAMERA	-ON WALL 7'-0" -ON SLAB
3		CCTV JUNCTION BOX	6" TO 9" BELOW SLAB BUT ABOVE FALSE CEILING
4		WIRING IN 1"Ø PVCC FOR CCTV SYSTEM	ON SLAB/ BUG/BUF/BIS
5		NETWORK VIDEO RECORDER	AS PER SITE

## PUBLIC ADDRESS SYSTEM

\$.\$NO	SYMBOLS	DESCRIPTION	MOUNTING HEIGHT
1		CIRCULAR TYPE LOUD SPEAKER	ON FALSE CEILING
		WALL SPEAKER	ON WALL
2		AMPLIFIER	RACK MOUNTED
3		PUBLIC ADDRESS JUNCTION BOX	4'-0"F.F.L OR AS REQ
4		WIRING IN 1"Ø PVCC FOR PUBLIC ADDRESS SYSTEM	BIS OR ON SLAB AFC

CLIENT:

PROJECT  
IMPLEMENTATION  
UNIT (PIU) KNIP



CONSULTANTS:

G3 ENGINEERING  
CONSULTANTS (PVT)LTD.  
House No.57-M Gulberg-III, Lahore, Pakistan

Tel : (92-42) 35441641, 35441642  
Fax : (92-42) 35441645  
E-mail : info@g3ec.com  
URL : www.g3ec.com

PROJECT:

**Karachi Neighbourhood  
Improvement Project (KNIP)**

SUB PROJECT:

**Redevelopment of Kakri Sports  
Complex and Neighborhood  
Improvement Including Kharadar  
Locality**

NOTES:

- ALL DIMENSIONS ARE IN FEET UNLESS OTHERWISE SPECIFIED.
- THIS DRAWING IS AN INTELLECTUAL PROPERTY OF G3 ENGINEERING CONSULTANTS (PVT.) LTD. AND CANNOT BE REPRINTED OR REPRODUCED WITHOUT PRIOR APPROVAL OF G3.

REVISIONS:

No.	DESCRIPTION	DATE

TENDER DRAWINGS

DRAWING TITLE:

**PARK  
ILLUMINATION LAYOUT**

DRAWN BY: M.Raffeh DATE: SEP 2021

CHECKED BY: Eng.Ghulam Daraz Shaikh

Approved BY: Syed Ali Abbas Gillani

DRAWING NO: 0249/PG/001 REV: 0

SCALE (A3): N.T.S SHEET: 00/00



CLIENT:

 PROJECT  
IMPLEMENTATION  
UNIT (PIU) KNIP



CONSULTANTS:

G3 ENGINEERING  
CONSULTANTS (PVT) LTD.  
House No.57-M Gulberg-III, Lahore, Pakistan



Tel : (92-42) 35441641, 35441642  
Fax : (92-42) 35441645  
E-mail : info@g3ec.com  
URL : www.g3ec.com

PROJECT:

**Karachi Neighbourhood  
Improvement Project (KNIP)**

SUB PROJECT:

**Redevelopment of Kakri Sports  
Complex and Neighborhood  
Improvement**

NOTES:

1. ALL DIMENSIONS ARE IN FEET UNLESS OTHERWISE SPECIFIED.
2. THIS DRAWING IS AN INTELLECTUAL PROPERTY OF G3 ENGINEERING CONSULTANTS (PVT.) LTD. AND CANNOT BE REPRINTED OR REPRODUCED WITHOUT PRIOR APPROVAL OF G3.



REVISIONS:

No.	DESCRIPTION	DATE


**TENDER DRAWINGS**

DRAWING TITLE:


**PLAY GROUND  
ILLUMINATION LAYOUT**

DRAWN BY: <b>M.Raffeh</b>	DATE: <b>SEP 2021</b>
CHECKED BY: <b>Eng.Ghulam Daraz Shaikh</b>	
Approved BY: <b>Syed Ali Abbas Gillani</b>	
DRAWING NO: <b>0249/PARK/002</b>	REV: <b>0</b>
SCALE (A3): <b>N.T.S</b>	SHEET: <b>00/00</b>



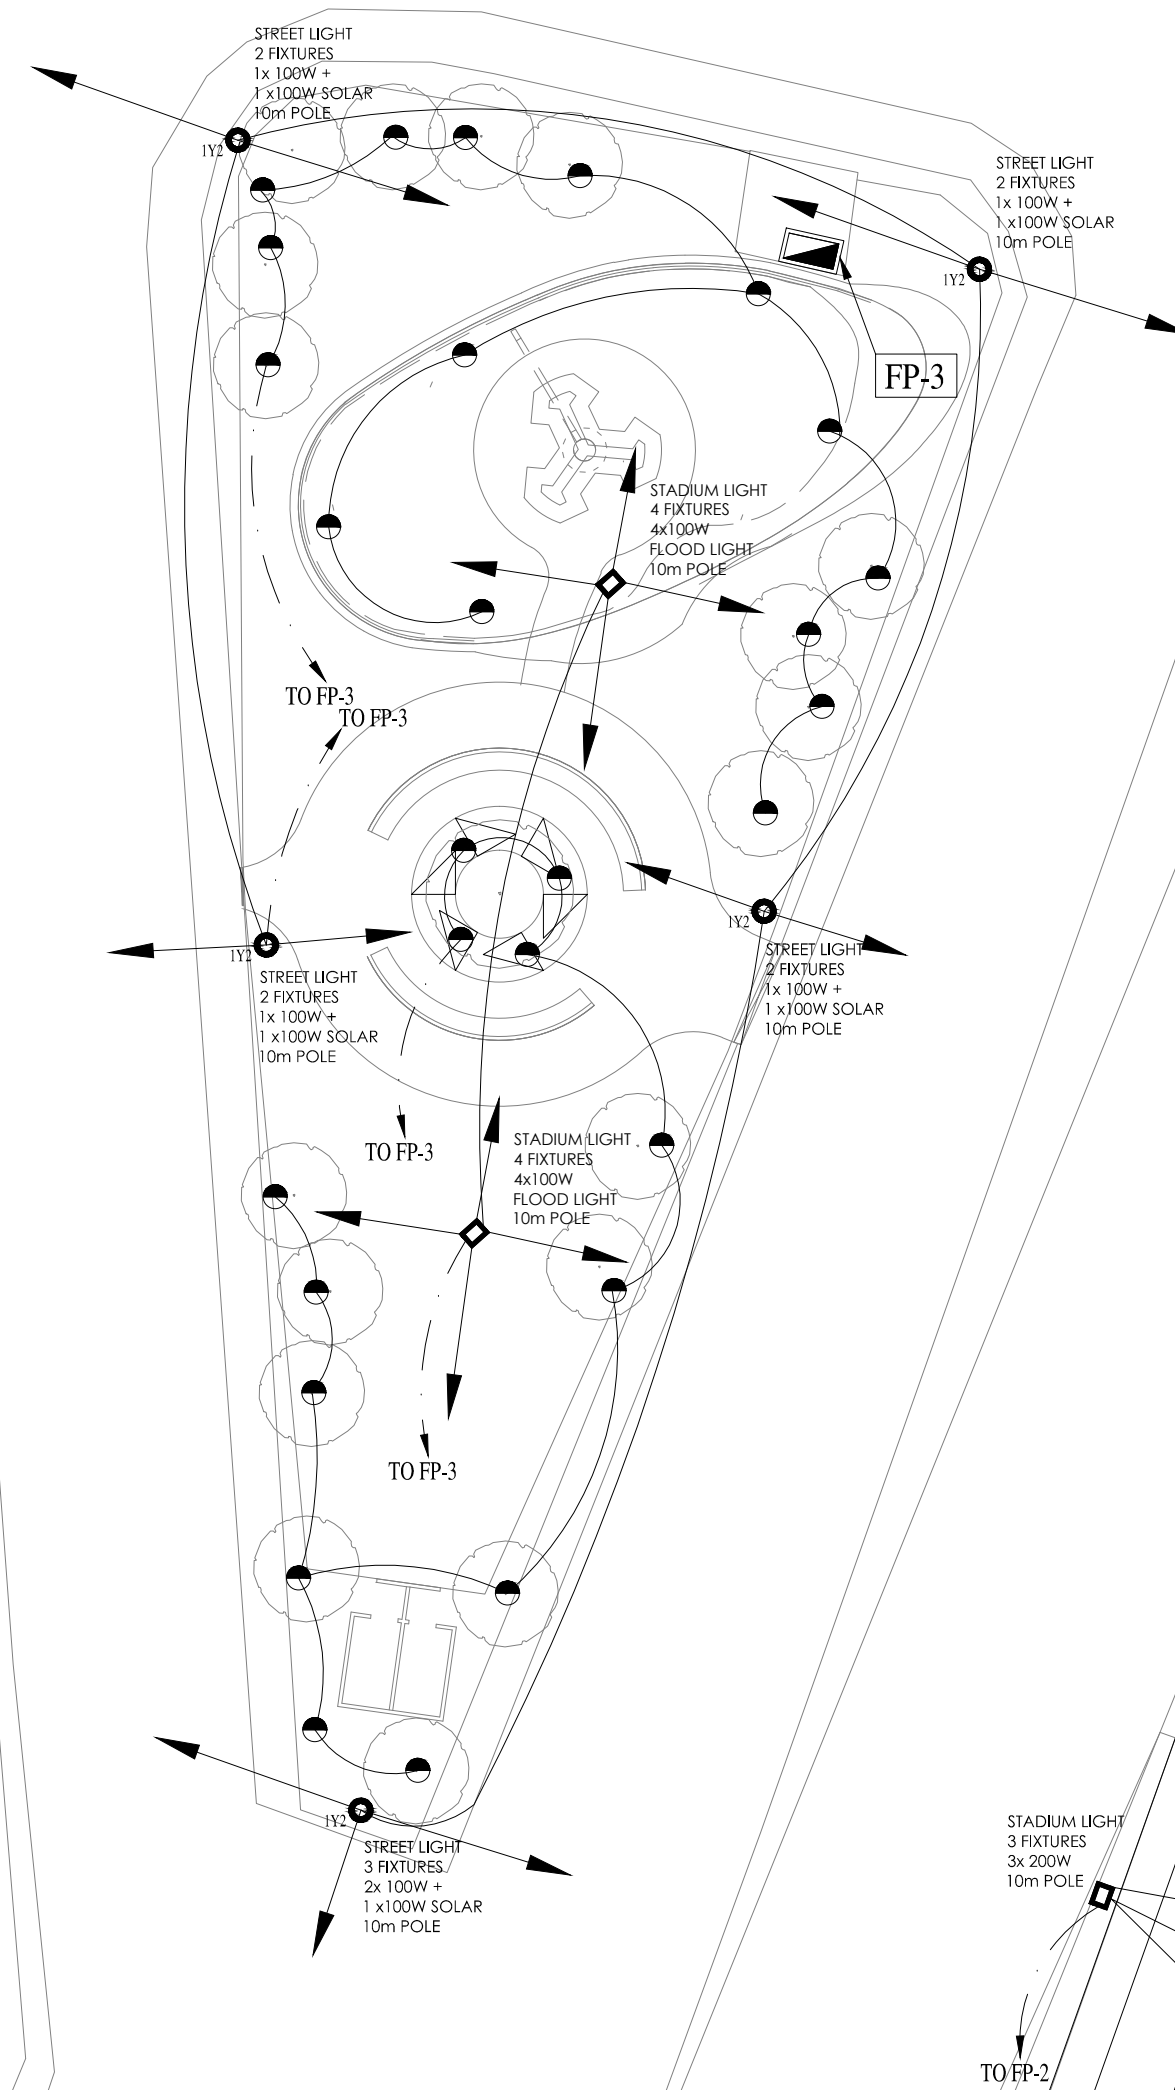

CLIENT:

 **PROJECT IMPLEMENTATION UNIT (PIU) KNIP**

 **CONSULTANTS:**  
G3 ENGINEERING CONSULTANTS (PVT)LTD.  
House No.57-M Gulberg-III, Lahore, Pakistan  
Tel : (92-42) 35441641, 35441642  
Fax : (92-42) 35441645  
E-mail : info@g3ec.com  
URL : www.g3ec.com

**PROJECT:**  
**Karachi Neighbourhood Improvement Project (KNIP)**

**SUB PROJECT:**  
**Redevelopment of Kakri Sports Complex and Neighborhood Improvement**

**NOTES:**  
1. ALL DIMENSIONS ARE IN FEET UNLESS OTHERWISE SPECIFIED.  
2. THIS DRAWING IS AN INTELLECTUAL PROPERTY OF G3 ENGINEERING CONSULTANTS (PVT.) LTD. AND CANNOT BE REPRINTED OR REPRODUCED WITHOUT PRIOR APPROVAL OF G3.

**REVISIONS:**

No.	DESCRIPTION	DATE

**TENDER DRAWINGS**

**DRAWING TITLE:**  
**GENERAL PARK ILLUMINATION LAYOUT**

<b>DRAWN BY:</b> M.Raffeh	<b>DATE:</b> SEP 2021
<b>CHECKED BY:</b> Eng.Ghulam Daraz Shaikh	
<b>Approved BY:</b> Syed Ali Abbas Gillani	
<b>DRAWING NO:</b> 0249/PARK/003	<b>REV:</b> 0
<b>SCALE (A3):</b> N.T.S	<b>SHEET:</b> 00/00



CLIENT:

**PROJECT  
IMPLEMENTATION  
UNIT (PIU) KNIP**



CONSULTANTS:

G3 ENGINEERING  
CONSULTANTS (PVT)LTD.  
House No.57-M Gulberg-III, Lahore, Pakistan



Tel : (92-42) 35441641, 35441642  
Fax : (92-42) 35441645  
E-mail : info@g3ec.com  
URL : www.g3ec.com

PROJECT:

**Karachi Neighbourhood  
Improvement Project (KNIP)**

SUB PROJECT:

**Redevelopment of Kakri Sports  
Complex and Neighborhood  
Improvement**

NOTES:

1. ALL DIMENSIONS ARE IN FEET UNLESS OTHERWISE SPECIFIED.
2. THIS DRAWING IS AN INTELLECTUAL PROPERTY OF G3 ENGINEERING CONSULTANTS (PVT.) LTD. AND CANNOT BE REPRINTED OR REPRODUCED WITHOUT PRIOR APPROVAL OF G3.


REVISIONS:

No.	DESCRIPTION	DATE


**TENDER DRAWINGS**

DRAWING TITLE:  
**PLAY GROUND  
POWER DISTRIBUTION  
SYSTEM**


 
DRAWN BY: <b>M.Raffeh</b>	DATE: <b>SEP 2021</b>
CHECKED BY: <b>Eng.Ghulam Daraz Shaikh</b>	
Approved BY: <b>Syed Ali Abbas Gillani</b>	
DRAWING NO: <b>0249/PARK/004</b>	REV: <b>0</b>
SCALE (A3): <b>N.T.S</b>	SHEET: <b>00/00</b>

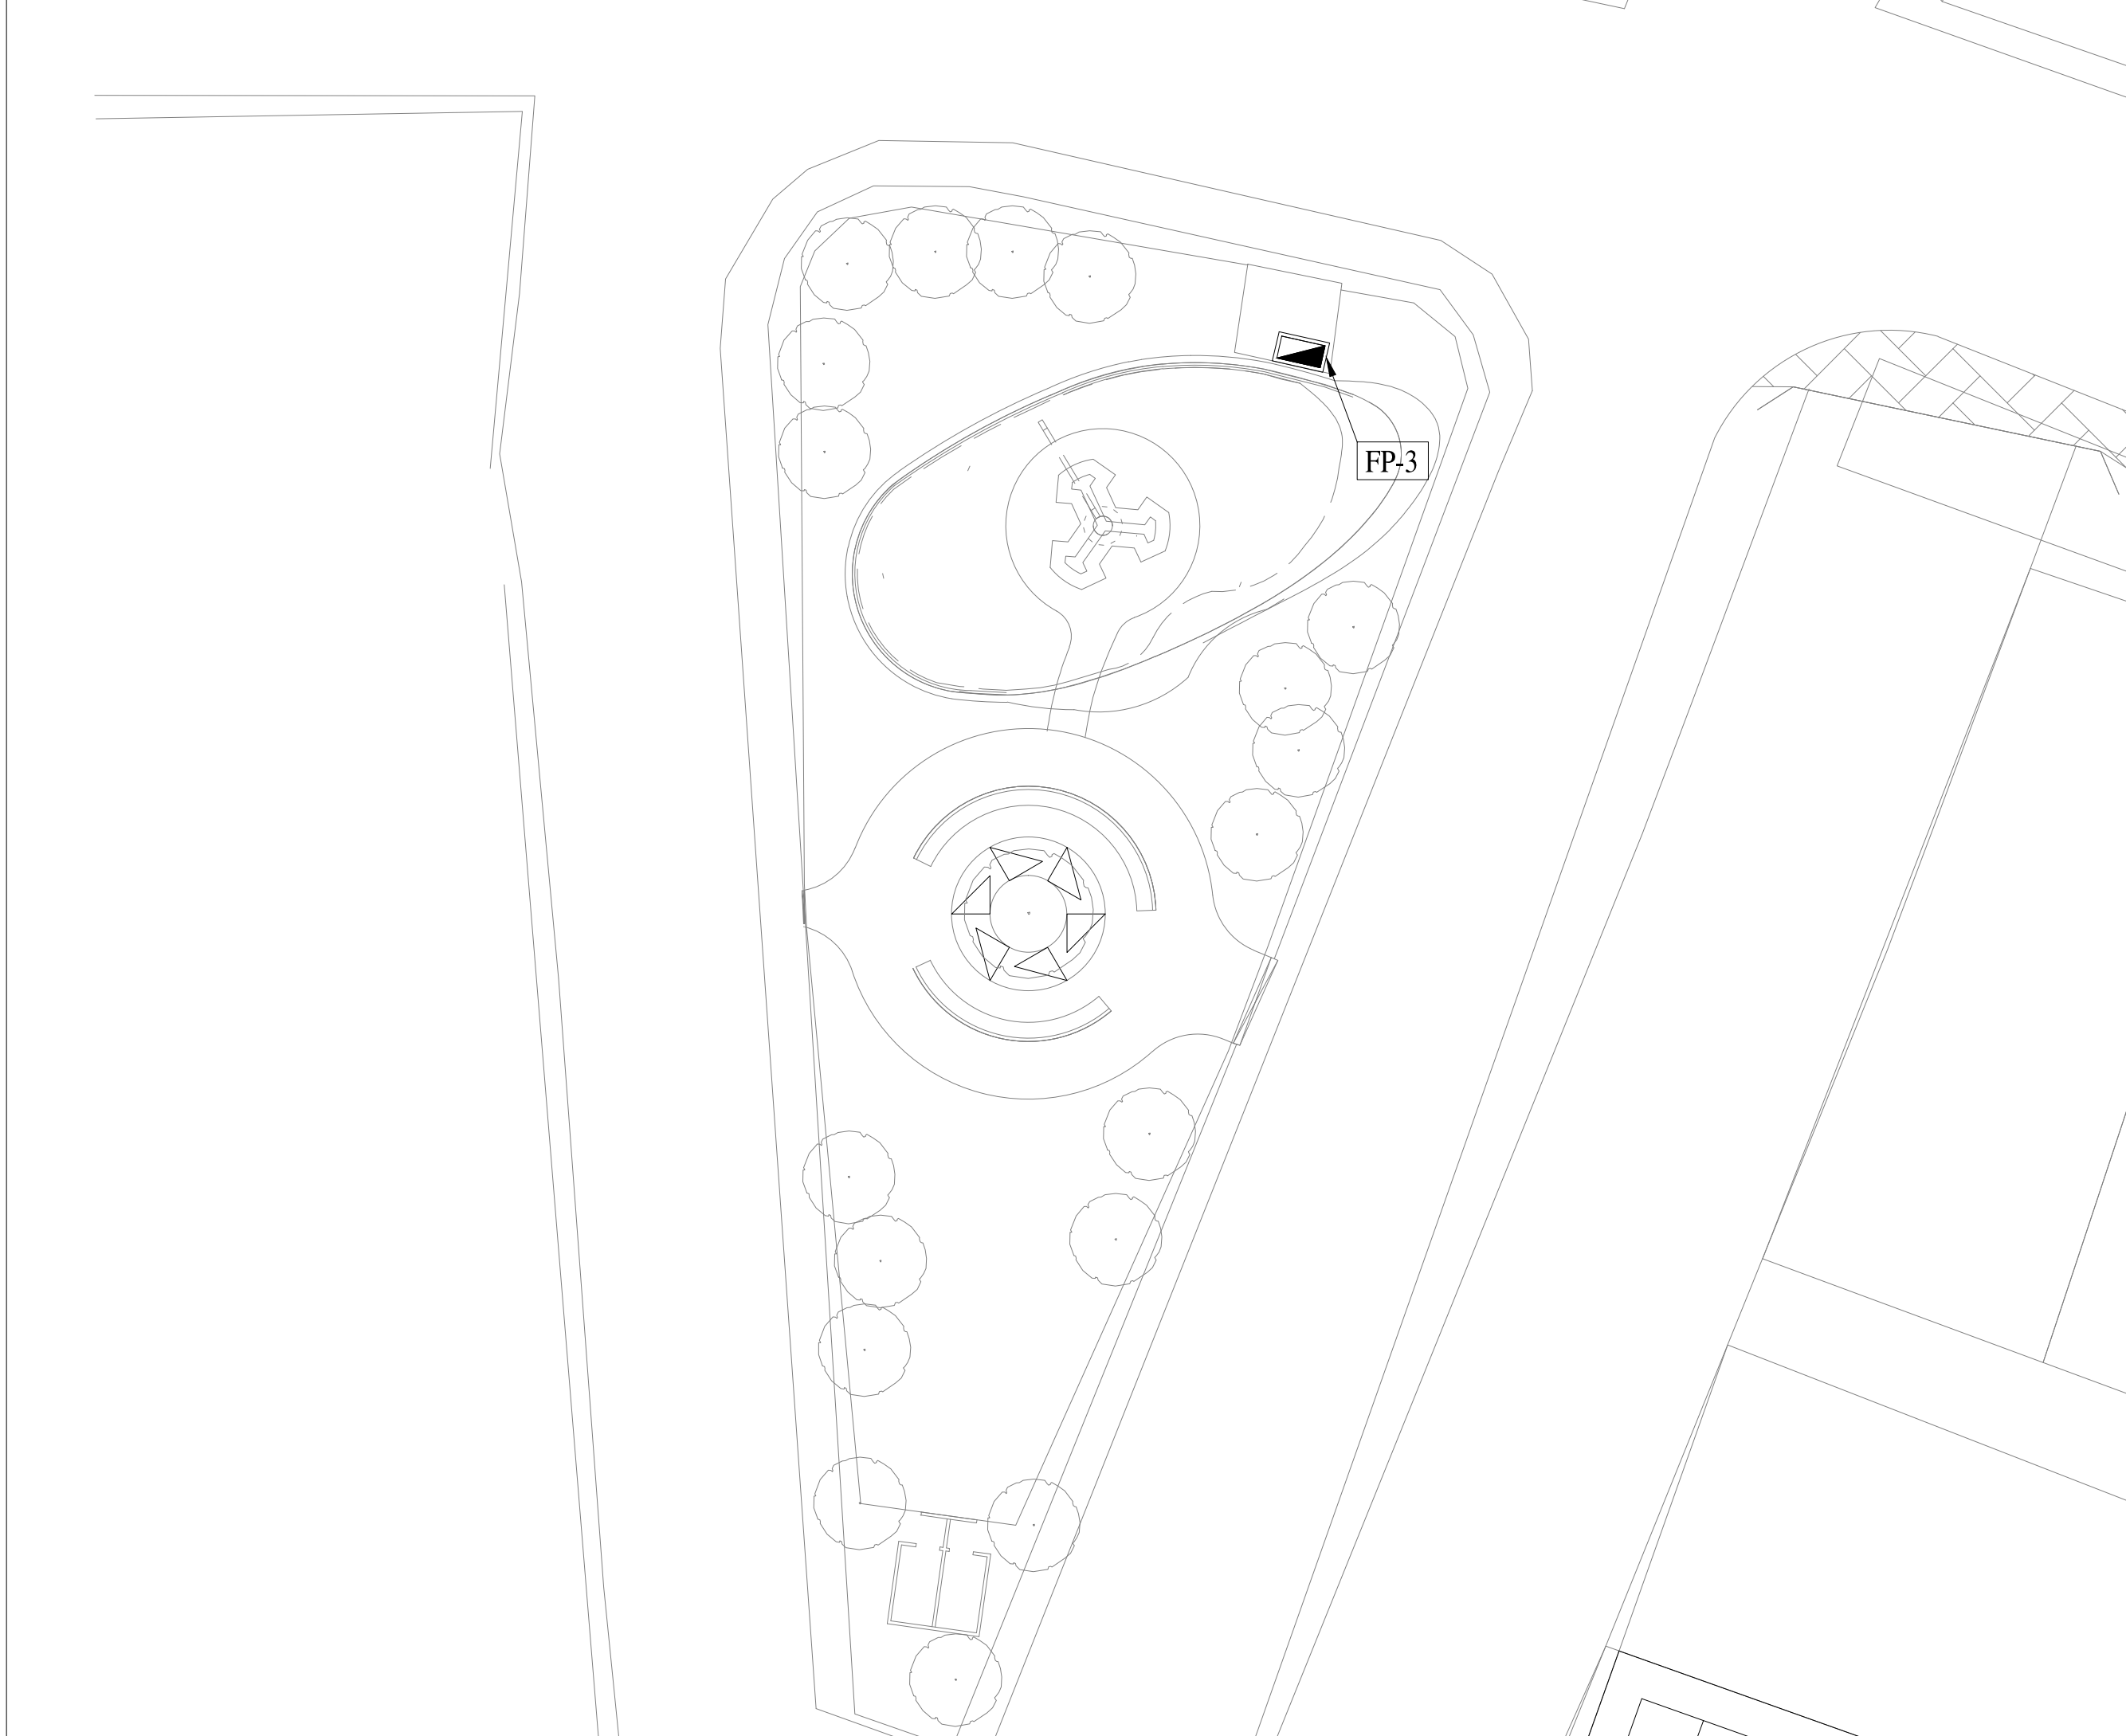

CLIENT:



PROJECT  
IMPLEMENTATION  
UNIT (PIU) KNIP

CONSULTANTS:  
  
G3 ENGINEERING  
CONSULTANTS (PVT)LTD.  
House No.57-M Gulberg-III, Lahore, Pakistan  
  
Tel : (92-42) 35441641, 35441642  
Fax : (92-42) 35441645  
E-mail : info@g3ec.com  
URL : www.g3ec.com

PROJECT:

Karachi Neighbourhood  
Improvement Project (KNIP)

SUB PROJECT:

Redevelopment of Kakri Sports  
Complex and Neighborhood  
Improvement

NOTES:

1. ALL DIMENSIONS ARE IN FEET UNLESS  
OTHERWISE SPECIFIED.  
2. THIS DRAWING IS AN INTELLECTUAL PROPERTY  
OF G3 ENGINEERING CONSULTANTS (PVT.) LTD.  
AND CANNOT BE REPRINTED OR REPRODUCED  
WITHOUT PRIOR APPROVAL OF G3.

REVISIONS:

No.	DESCRIPTION	DATE

TENDER DRAWINGS

DRAWING TITLE:

GENERAL PARK  
POWER DISTRIBUTION  
SYSTEM

DRAWN BY:

M.Raffeh

DATE:

SEP 2021

CHECKED BY:

Eng.Ghulam Daraz Shaikh

Approved BY:

Syed Ali Abbas Gillani

DRAWING NO:

0249/PARK/005

REV:

0

SCALE (A3):

N.T.S

SHEET:

00/00





CLIENT:

 PROJECT  
IMPLEMENTATION  
UNIT (PIU) KNIP



CONSULTANTS:

G3 ENGINEERING  
CONSULTANTS (PVT) LTD.  
House No.57-M Gulberg-III, Lahore, Pakistan



Tel : (92-42) 35441641, 35441642  
Fax : (92-42) 35441645  
E-mail : info@g3ec.com  
URL : www.g3ec.com

PROJECT:

**Karachi Neighbourhood  
Improvement Project (KNIP)**

SUB PROJECT:

**Redevelopment of Kakri Sports  
Complex and Neighborhood  
Improvement**

NOTES:

1. ALL DIMENSIONS ARE IN FEET UNLESS OTHERWISE SPECIFIED.
2. THIS DRAWING IS AN INTELLECTUAL PROPERTY OF G3 ENGINEERING CONSULTANTS (PVT.) LTD. AND CANNOT BE REPRINTED OR REPRODUCED WITHOUT PRIOR APPROVAL OF G3.

REVISIONS:

No.	DESCRIPTION	DATE

**TENDER DRAWINGS**

DRAWING TITLE:

**PLAY GROUND  
CCTV LAYOUT**

DRAWN BY:

M.Raffeh

DATE:

SEP 2021

CHECKED BY:

Eng.Ghulam Daraz Shaikh

Approved BY:

Syed Ali Abbas Gillani

DRAWING NO:

0249/PARK/006

REV:

0


SCALE (A3):

N.T.S


SHEET:

00/00

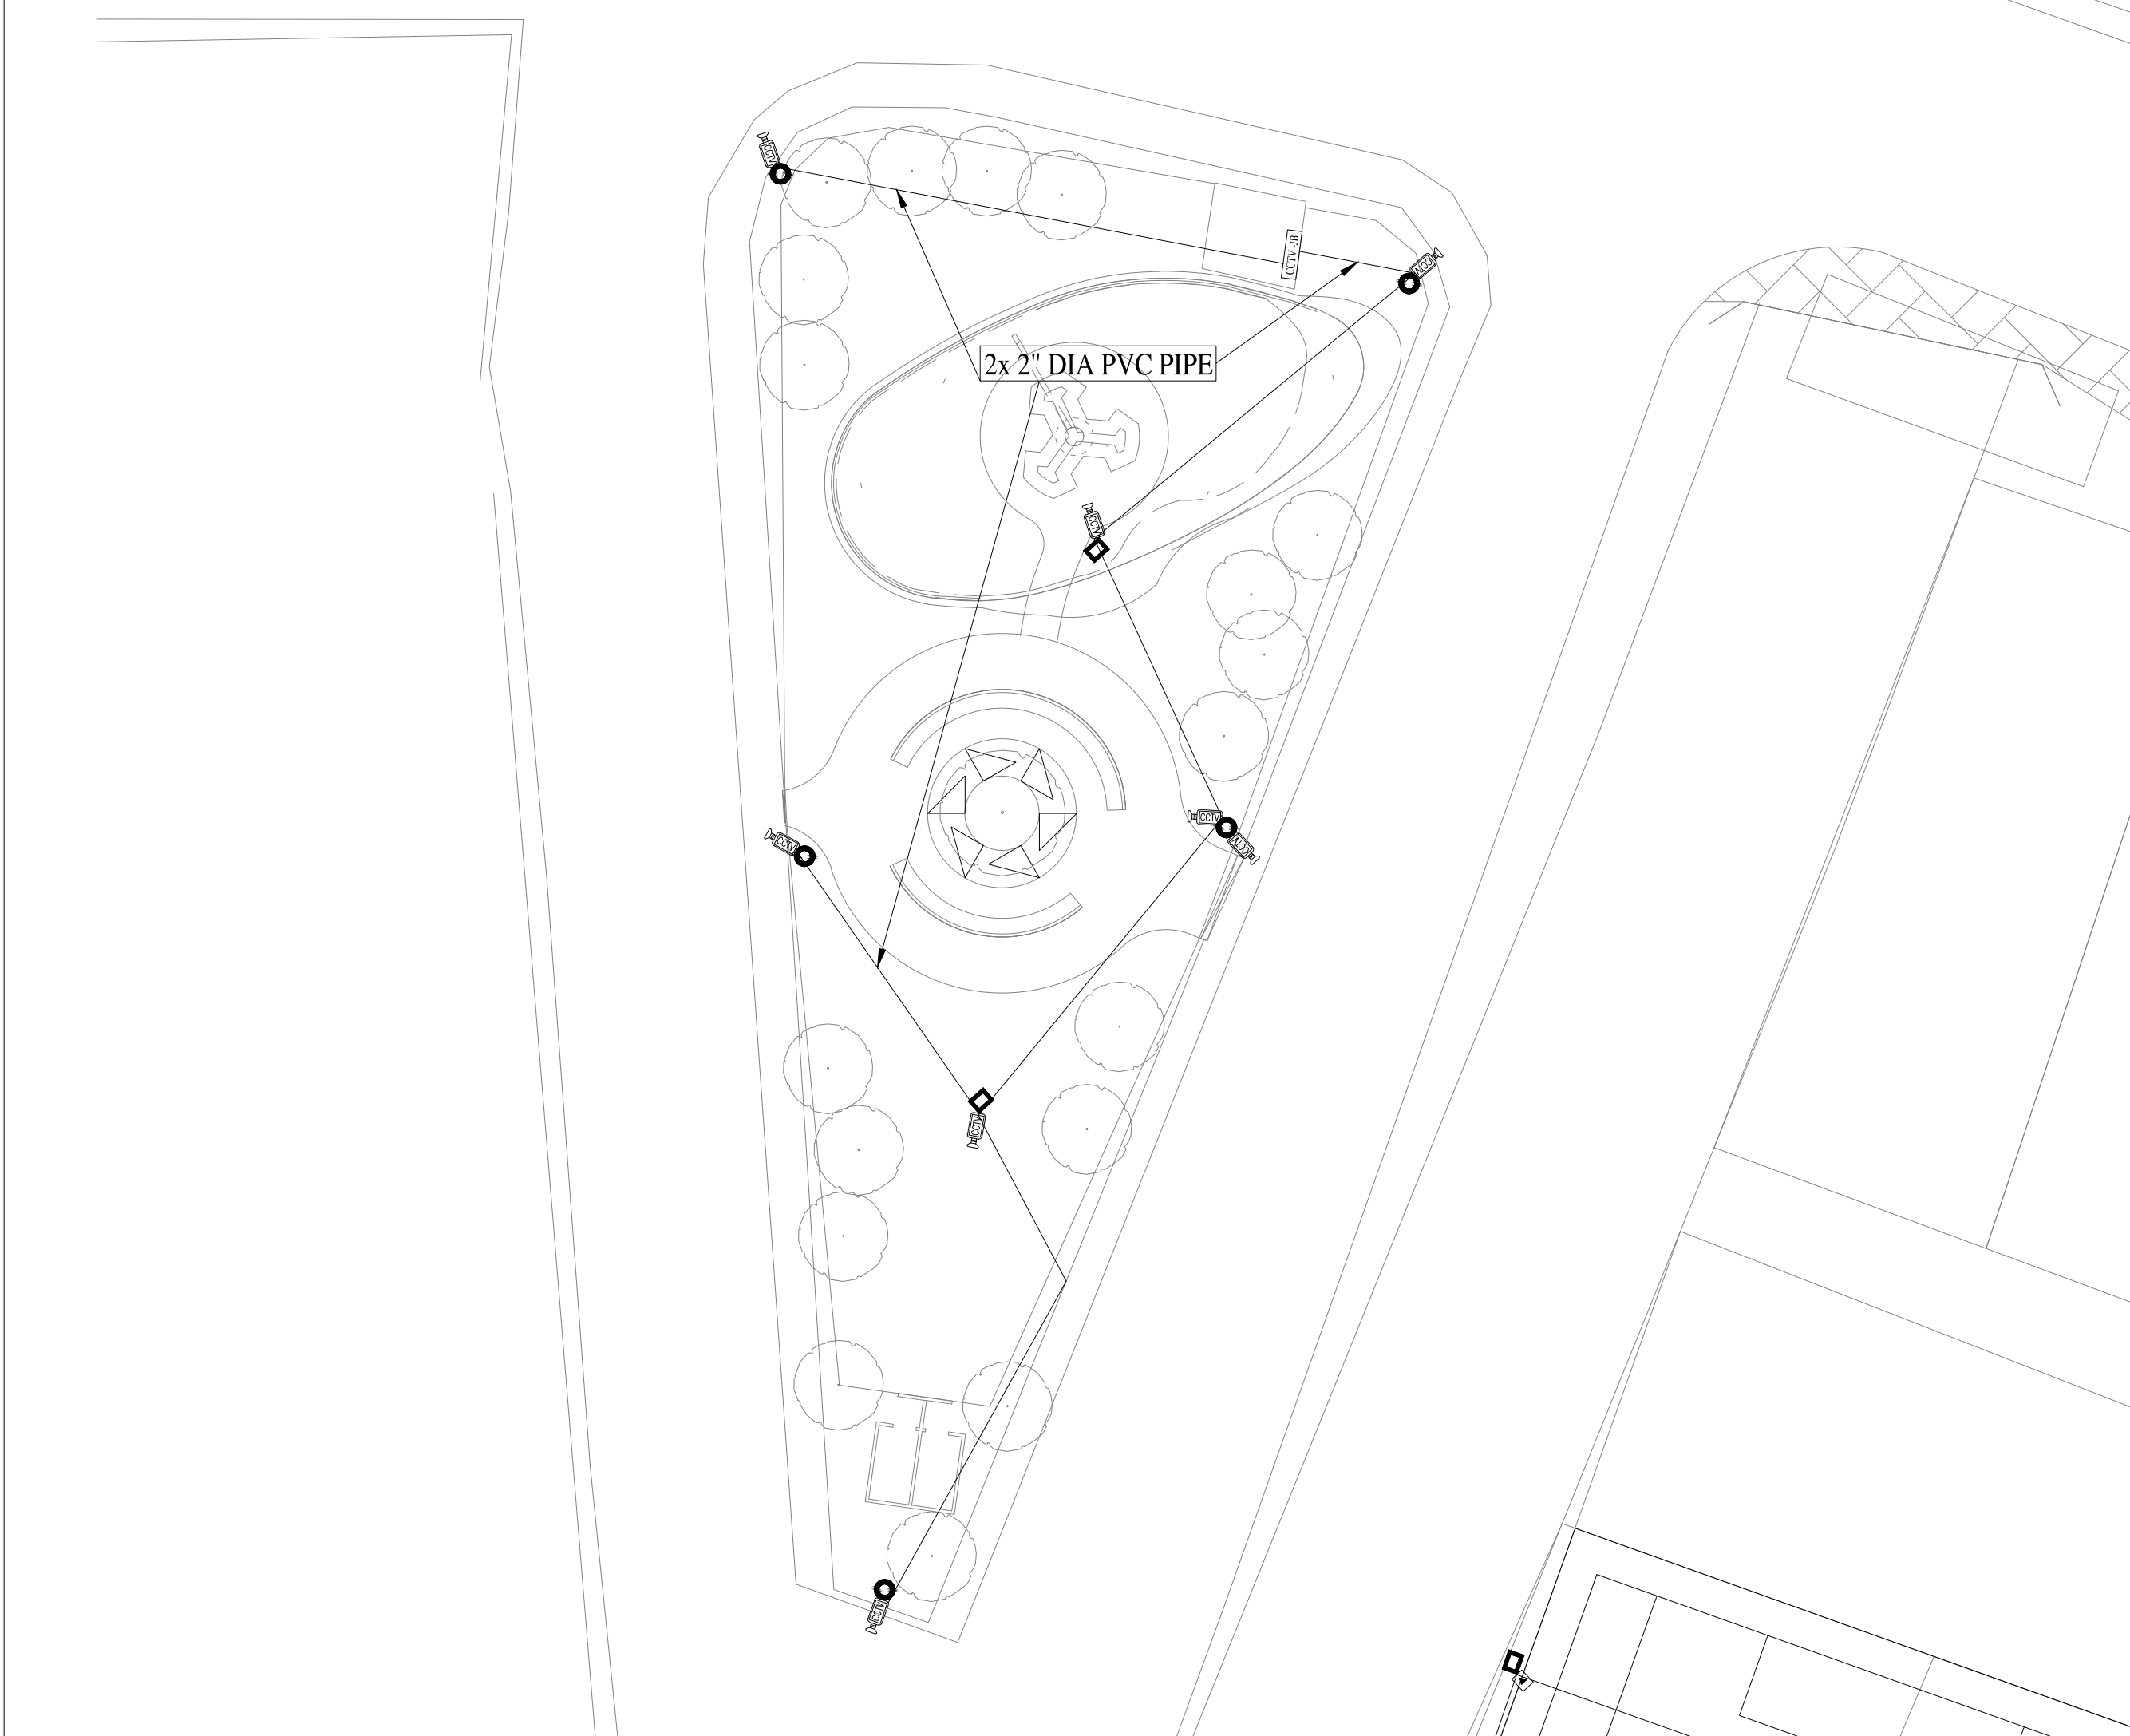


 


CLIENT:



PROJECT  
IMPLEMENTATION  
UNIT (PIU) KNIP





CONSULTANTS:  
  
G3 ENGINEERING  
CONSULTANTS (PVT)LTD.  
House No.57-M Gulberg-III, Lahore, Pakistan  
  
Tel : (92-42) 35441641, 35441642  
Fax : (92-42) 35441645  
E-mail : info@g3ec.com  
URL : www.g3ec.com

PROJECT:

Karachi Neighbourhood  
Improvement Project (KNIP)

SUB PROJECT:

Redevelopment of Kakri Sports  
Complex and Neighborhood  
Improvement

NOTES:

1. ALL DIMENSIONS ARE IN FEET UNLESS  
OTHERWISE SPECIFIED.  
2. THIS DRAWING IS AN INTELLECTUAL PROPERTY  
OF G3 ENGINEERING CONSULTANTS (PVT.) LTD.  
AND CANNOT BE REPRINTED OR REPRODUCED  
WITHOUT PRIOR APPROVAL OF G3.

REVISIONS:

No.	DESCRIPTION	DATE

TENDER DRAWINGS

DRAWING TITLE:

GENERAL GROUND  
CCTV LAYOUT

DRAWN BY:

M.Raffeh

DATE:

SEP 2021

CHECKED BY:

Eng.Ghulam Daraz Shaikh

Approved BY:

Syed Ali Abbas Gillani

DRAWING NO:

0249/PARK/007

REV:


0

SCALE (A3):

N.T.S

SHEET:

00/00

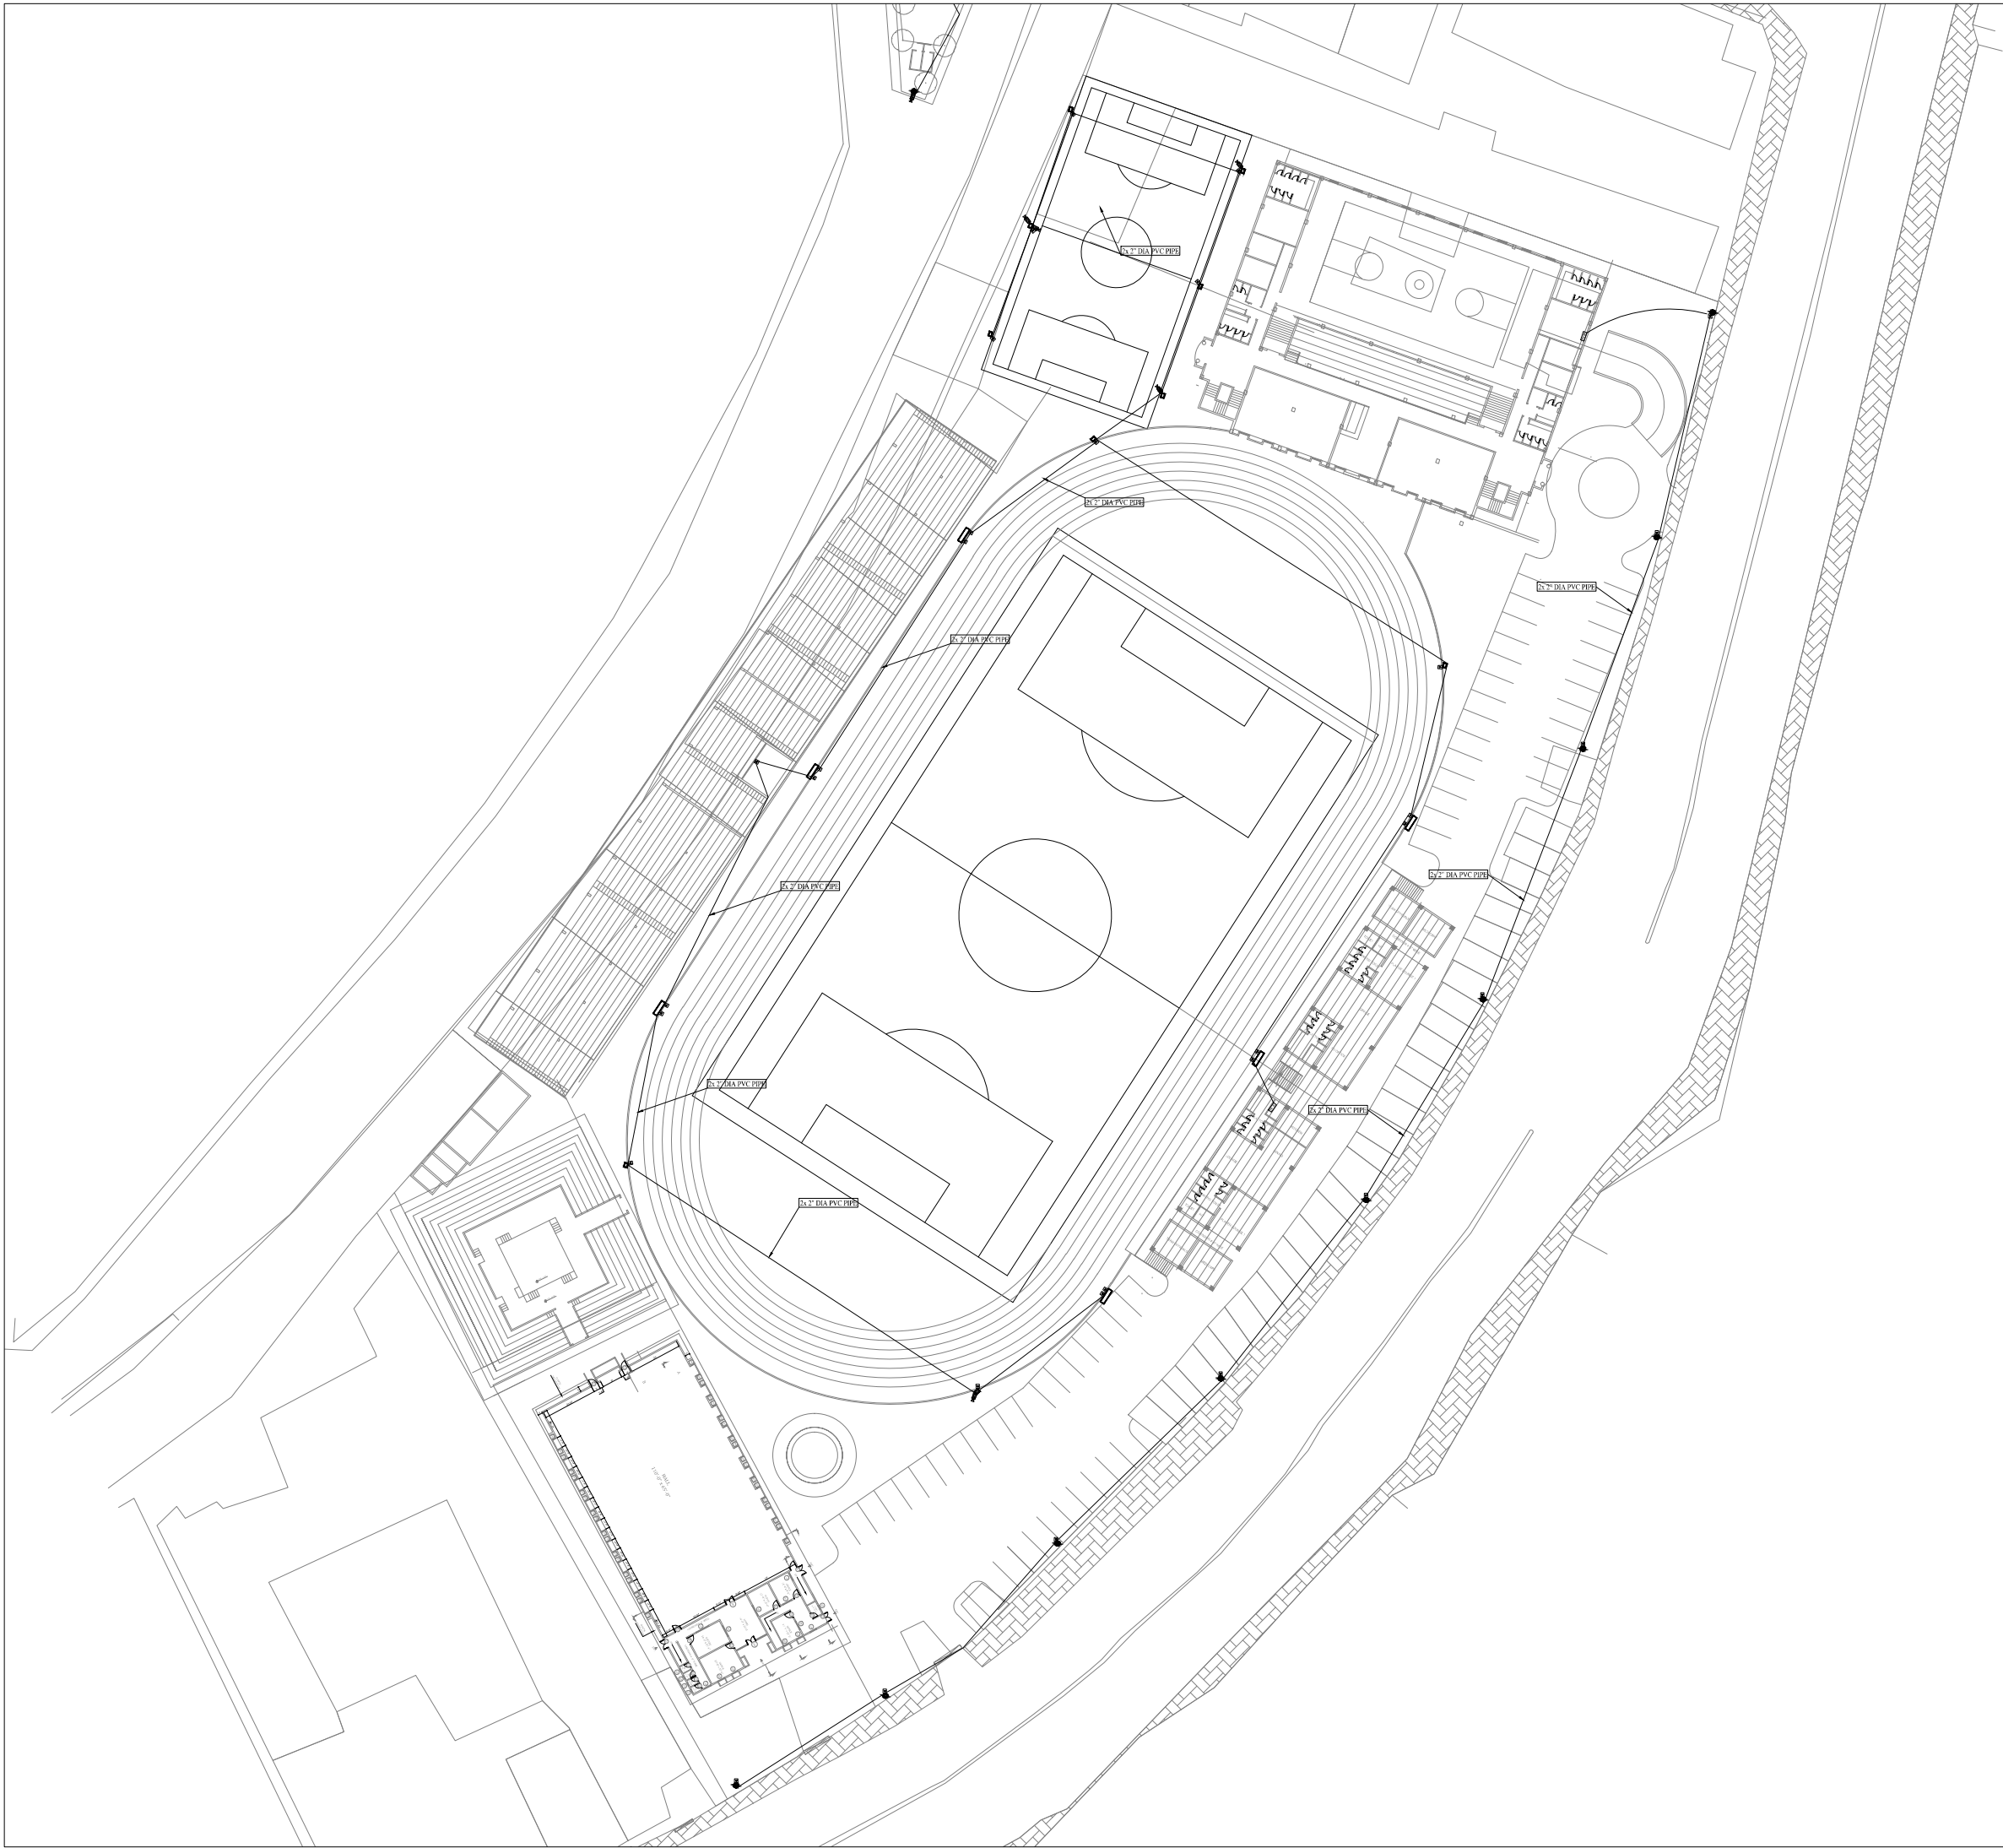

CLIENT:

 PROJECT  
IMPLEMENTATION  
UNIT (PIU) KNIP



CONSULTANTS:

G3 ENGINEERING  
CONSULTANTS (PVT) LTD.  
House No.57-M Gulberg-III, Lahore, Pakistan



Tel : (92-42) 35441641, 35441642  
Fax : (92-42) 35441645  
E-mail : info@g3ec.com  
URL : www.g3ec.com

PROJECT:

**Karachi Neighbourhood  
Improvement Project (KNIP)**

SUB PROJECT:

**Redevelopment of Kakri Sports  
Complex and Neighborhood  
Improvement**

NOTES:

1. ALL DIMENSIONS ARE IN FEET UNLESS OTHERWISE SPECIFIED.
2. THIS DRAWING IS AN INTELLECTUAL PROPERTY OF G3 ENGINEERING CONSULTANTS (PVT.) LTD. AND CANNOT BE REPRINTED OR REPRODUCED WITHOUT PRIOR APPROVAL OF G3.

REVISIONS:

No.	DESCRIPTION	DATE

**TENDER DRAWINGS**

DRAWING TITLE:

**PLAY GROUND  
PUBLIC ADDRESS SYSTEM**

DRAWN BY:

M.Raffeh

DATE:

SEP 2021

CHECKED BY:

Eng.Ghulam Daraz Shaikh

Approved BY:

Syed Ali Abbas Gillani

DRAWING NO:

0249/PARK/008

REV:


0

SCALE (A3):

N.T.S

SHEET:


00/00

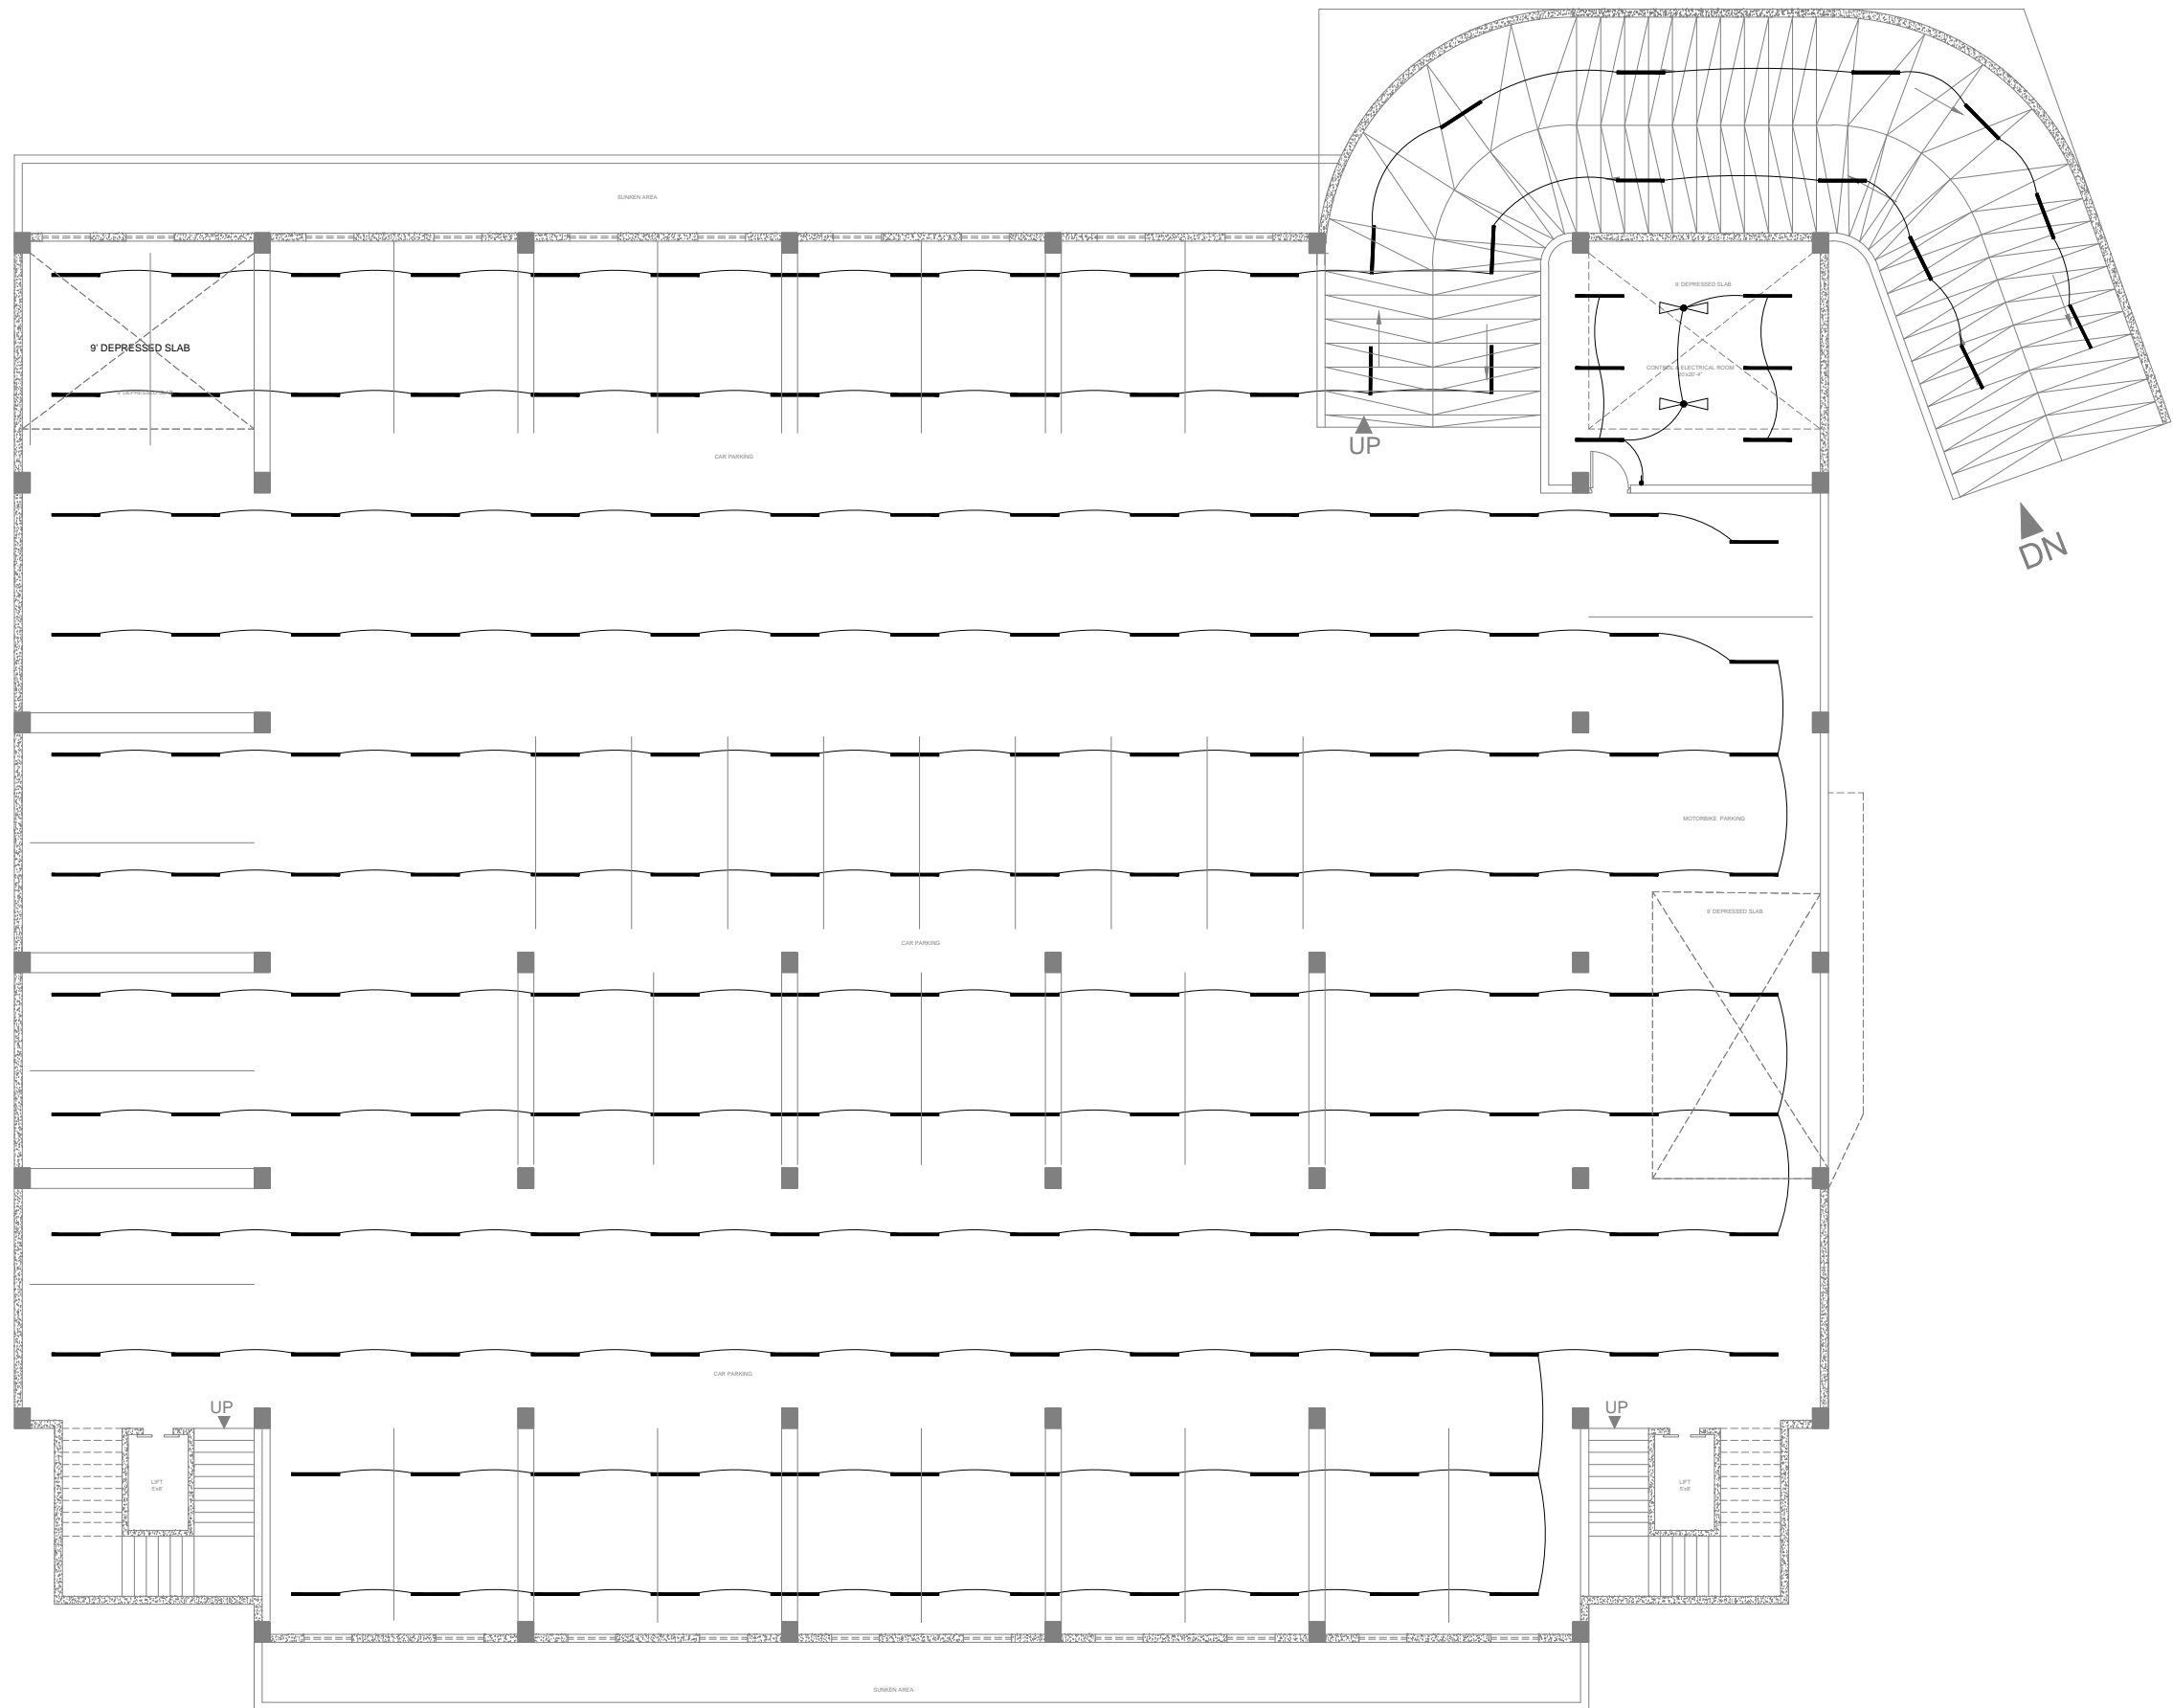

**BASEMENT FLOOR PLAN**  
COVERED AREA 17,500 SFT

CLIENT:

**PROJECT IMPLEMENTATION UNIT (PIU) KNIP**

 

CONSULTANTS:

**G3 ENGINEERING CONSULTANTS (PVT) LTD.**  
House No.57-M Gulberg-III, Lahore, Pakistan

Tel : (92-42) 35441641, 35441642  
Fax : (92-42) 35441645  
E-mail : info@g3ec.com  
URL : www.g3ec.com

**PROJECT:**

**Karachi Neighbourhood Improvement Project (KNIP)**

**SUB PROJECT:**

**Redevelopment of Kakri Sports Complex and Neighborhood Improvement**

**NOTES:**

1. ALL DIMENSIONS ARE IN FEET UNLESS OTHERWISE SPECIFIED.
2. THIS DRAWING IS AN INTELLECTUAL PROPERTY OF G3 ENGINEERING CONSULTANTS (PVT.) LTD. AND CANNOT BE REPRINTED OR REPRODUCED WITHOUT PRIOR APPROVAL OF G3.

**REVISIONS:**


No.	DESCRIPTION	DATE

**TENDER DRAWINGS**


**DRAWING TITLE:**  
**PURPOSED MULTIPURPOSE HALL BASEMENT ILLUMINATION LAYOUT**

DRAWN BY: <b>M.Raffeh</b>	DATE: <b>SEP 2021</b>
CHECKED BY: <b>Eng.Ghulam Daraz Shaikh</b>	
Approved BY: <b>Syed Ali Abbas Gillani</b>	
DRAWING NO: <b>0249/MPH/009</b>	REV: <b>0</b>
SCALE (A3): <b>N.T.S</b>	SHEET: <b>00/00</b>



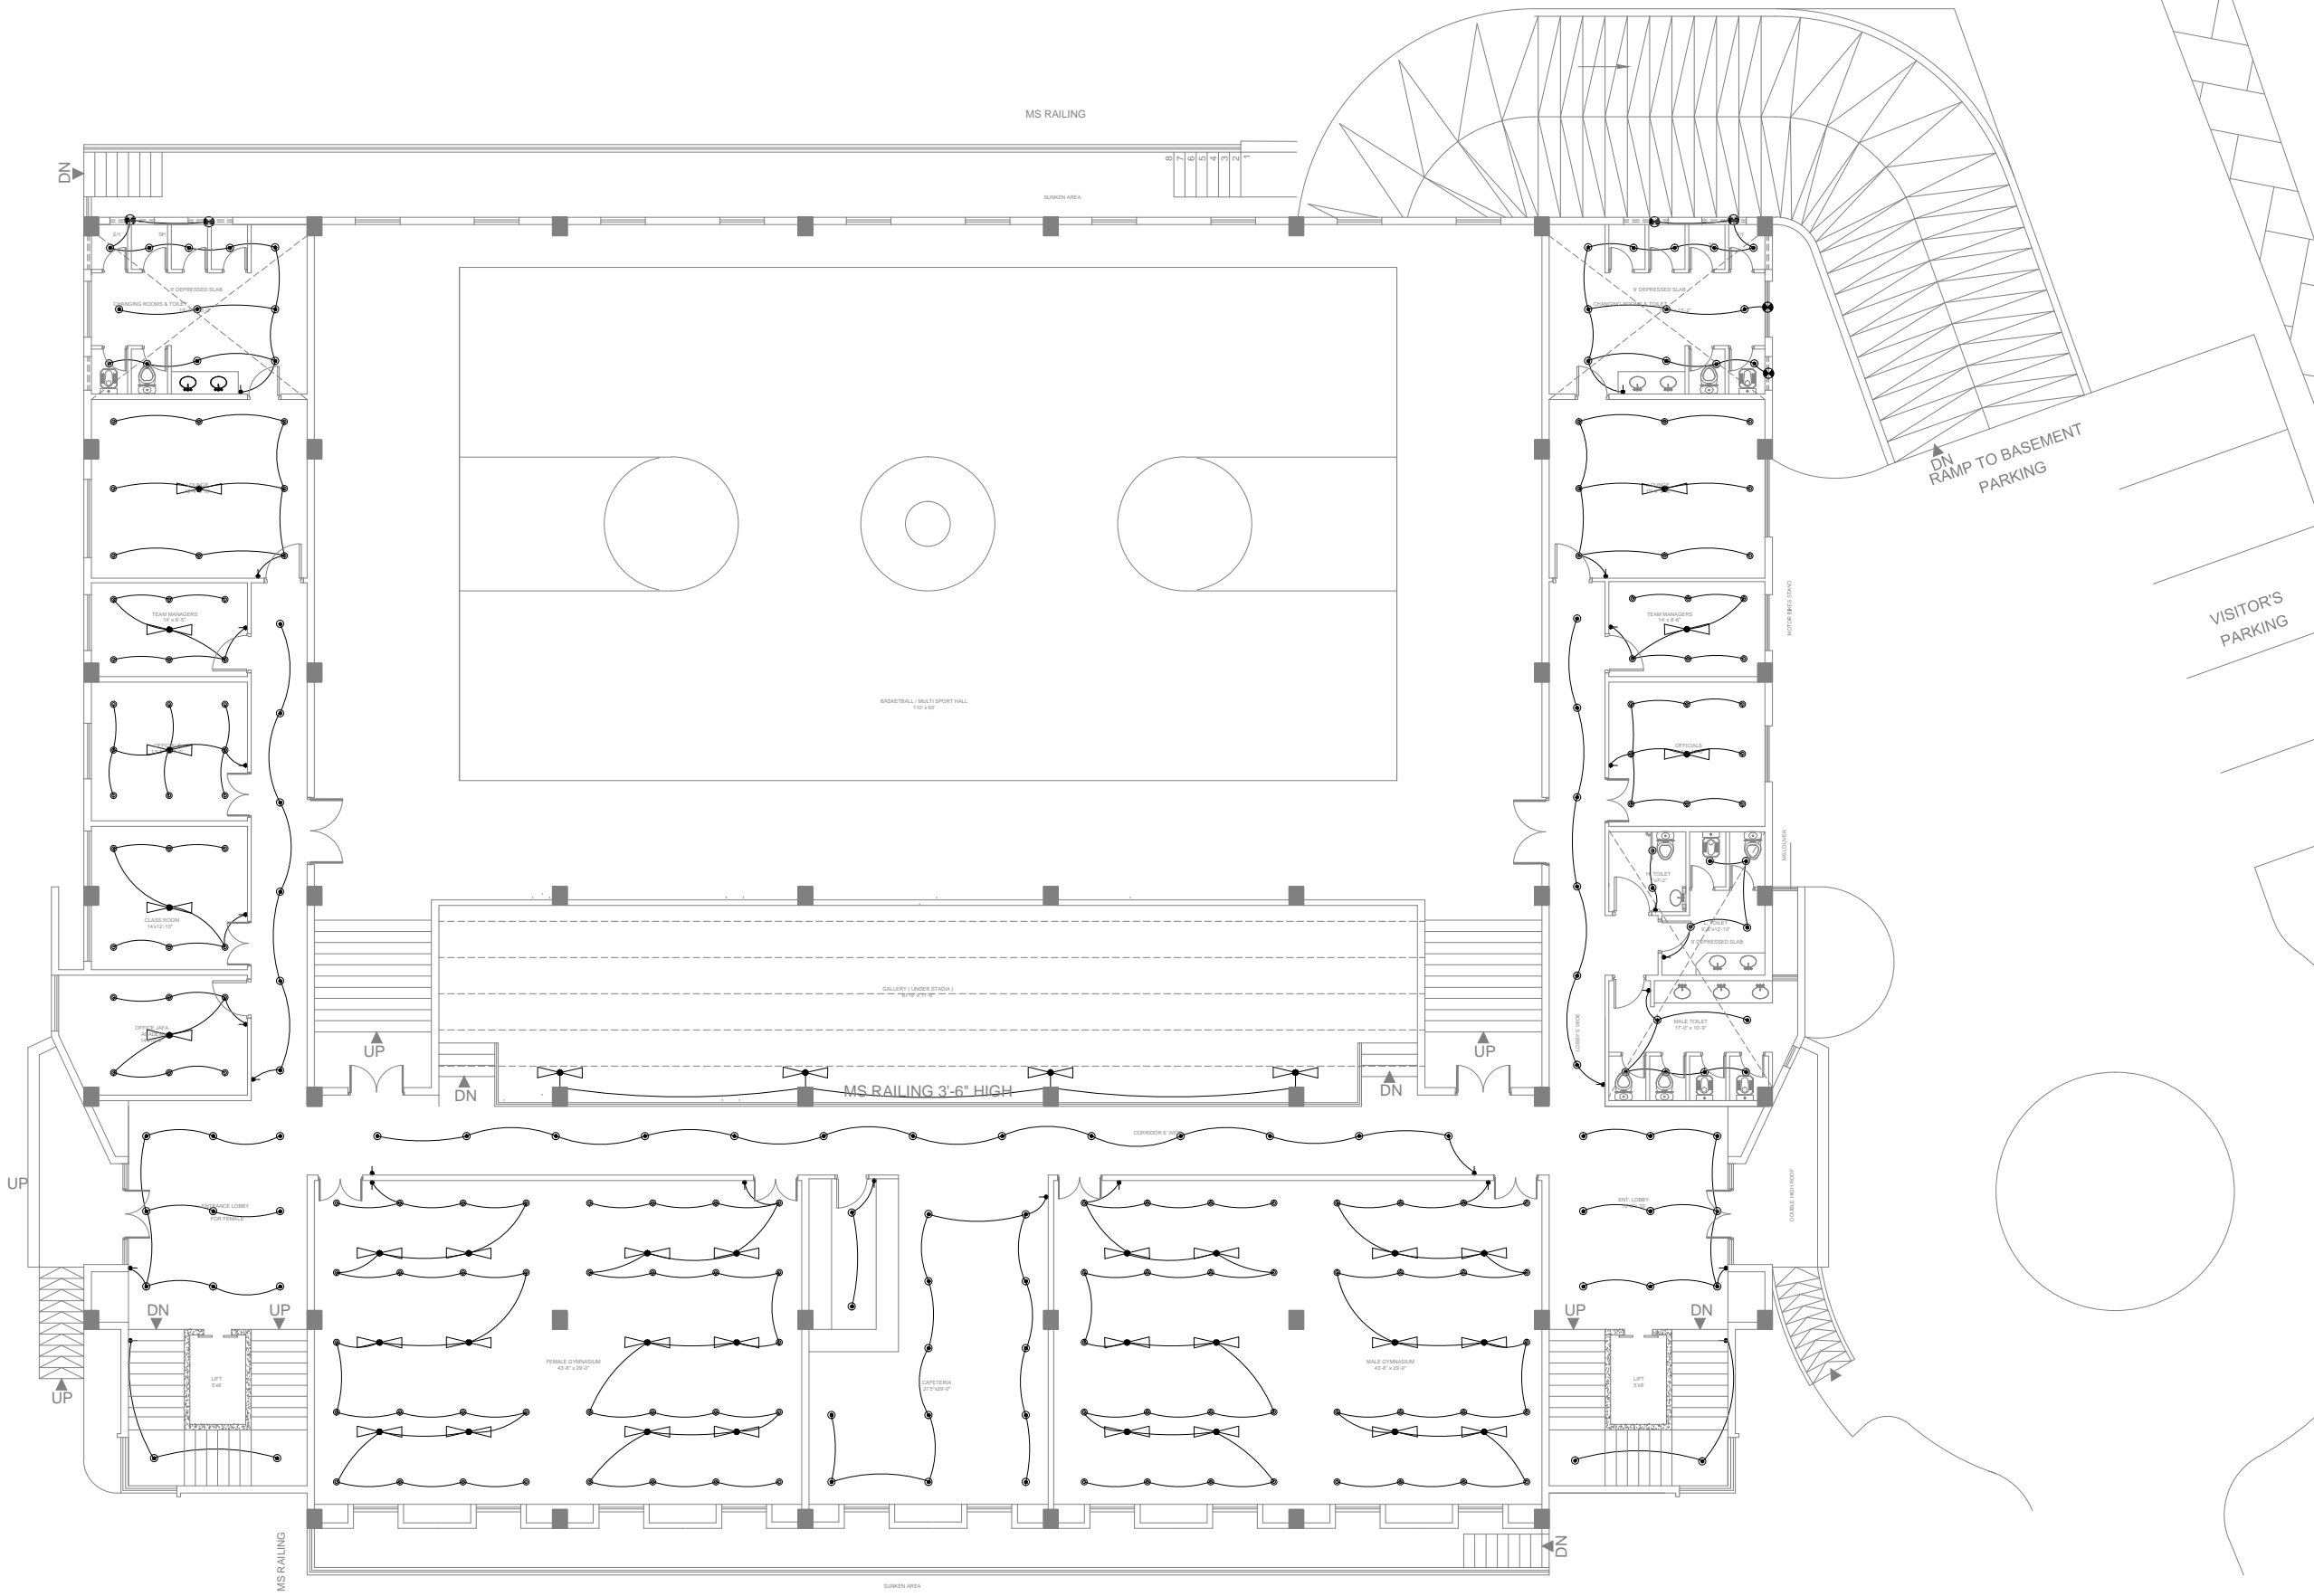

GROUND FLOOR PLAN  
COVERED AREA 10,975 SFT

CLIENT:  
 PROJECT IMPLEMENTATION UNIT (PIU) KNIP

 CONSULTANTS:  
G3 ENGINEERING CONSULTANTS (PVT) LTD.  
House No.57-M Gulberg-III, Lahore, Pakistan  
Tel : (92-42) 35441641, 35441642  
Fax : (92-42) 35441645  
E-mail : info@g3ec.com  
URL : www.g3ec.com

PROJECT:  
**Karachi Neighbourhood Improvement Project (KNIP)**



SUB PROJECT:  
**Redevelopment of Kakri Sports Complex and Neighborhood Improvement**

NOTES:  
1. ALL DIMENSIONS ARE IN FEET UNLESS OTHERWISE SPECIFIED.  
2. THIS DRAWING IS AN INTELLECTUAL PROPERTY OF G3 ENGINEERING CONSULTANTS (PVT.) LTD. AND CANNOT BE REPRINTED OR REPRODUCED WITHOUT PRIOR APPROVAL OF G3.


REVISIONS:		
No.	DESCRIPTION	DATE

**TENDER DRAWINGS**

DRAWING TITLE:  
**PURPOSED MULTIPURPOSE HALL GROUND FLOOR ILLUMINATION LAYOUT**

DRAWN BY: <b>M.Raffeh</b>	DATE: <b>SEP 2021</b>
CHECKED BY: <b>Eng.Ghulam Daraz Shaikh</b>	
Approved BY: <b>Syed Ali Abbas Gillani</b>	
DRAWING NO: <b>0249/MPH/010</b>	REV: <b>0</b>
SCALE (A3): <b>N.T.S</b>	SHEET: <b>00/00</b>

CLIENT:

 PROJECT  
IMPLEMENTATION  
UNIT (PIU) KNIP



CONSULTANTS:

G3 ENGINEERING  
CONSULTANTS (PVT) LTD.  
House No.57-M Gulberg-III, Lahore, Pakistan

Tel : (92-42) 35441641, 35441642  
Fax : (92-42) 35441645  
E-mail : info@g3ec.com  
URL : www.g3ec.com

PROJECT:

**Karachi Neighbourhood  
Improvement Project (KNIP)**

SUB PROJECT:

**Redevelopment of Kakri Sports  
Complex and Neighborhood  
Improvement**

NOTES:

1. ALL DIMENSIONS ARE IN FEET UNLESS OTHERWISE SPECIFIED.
2. THIS DRAWING IS AN INTELLECTUAL PROPERTY OF G3 ENGINEERING CONSULTANTS (PVT.) LTD. AND CANNOT BE REPRINTED OR REPRODUCED WITHOUT PRIOR APPROVAL OF G3.


REVISIONS:

No.	DESCRIPTION	DATE


**TENDER DRAWINGS**

DRAWING TITLE:  
**PURPOSED MULTIPURPOSE  
HALL FIRST FLOOR  
ILLUMINATION LAYOUT**

DRAWN BY: <b>M.Raffeh</b>	DATE: <b>SEP 2021</b>
CHECKED BY: <b>Eng.Ghulam Daraz Shaikh</b>	
Approved BY: <b>Syed Ali Abbas Gillani</b>	
DRAWING NO: <b>0249/MPH/011</b>	REV: <b>0</b>
SCALE (A3): <b>N.T.S</b>	SHEET: <b>00/00</b>

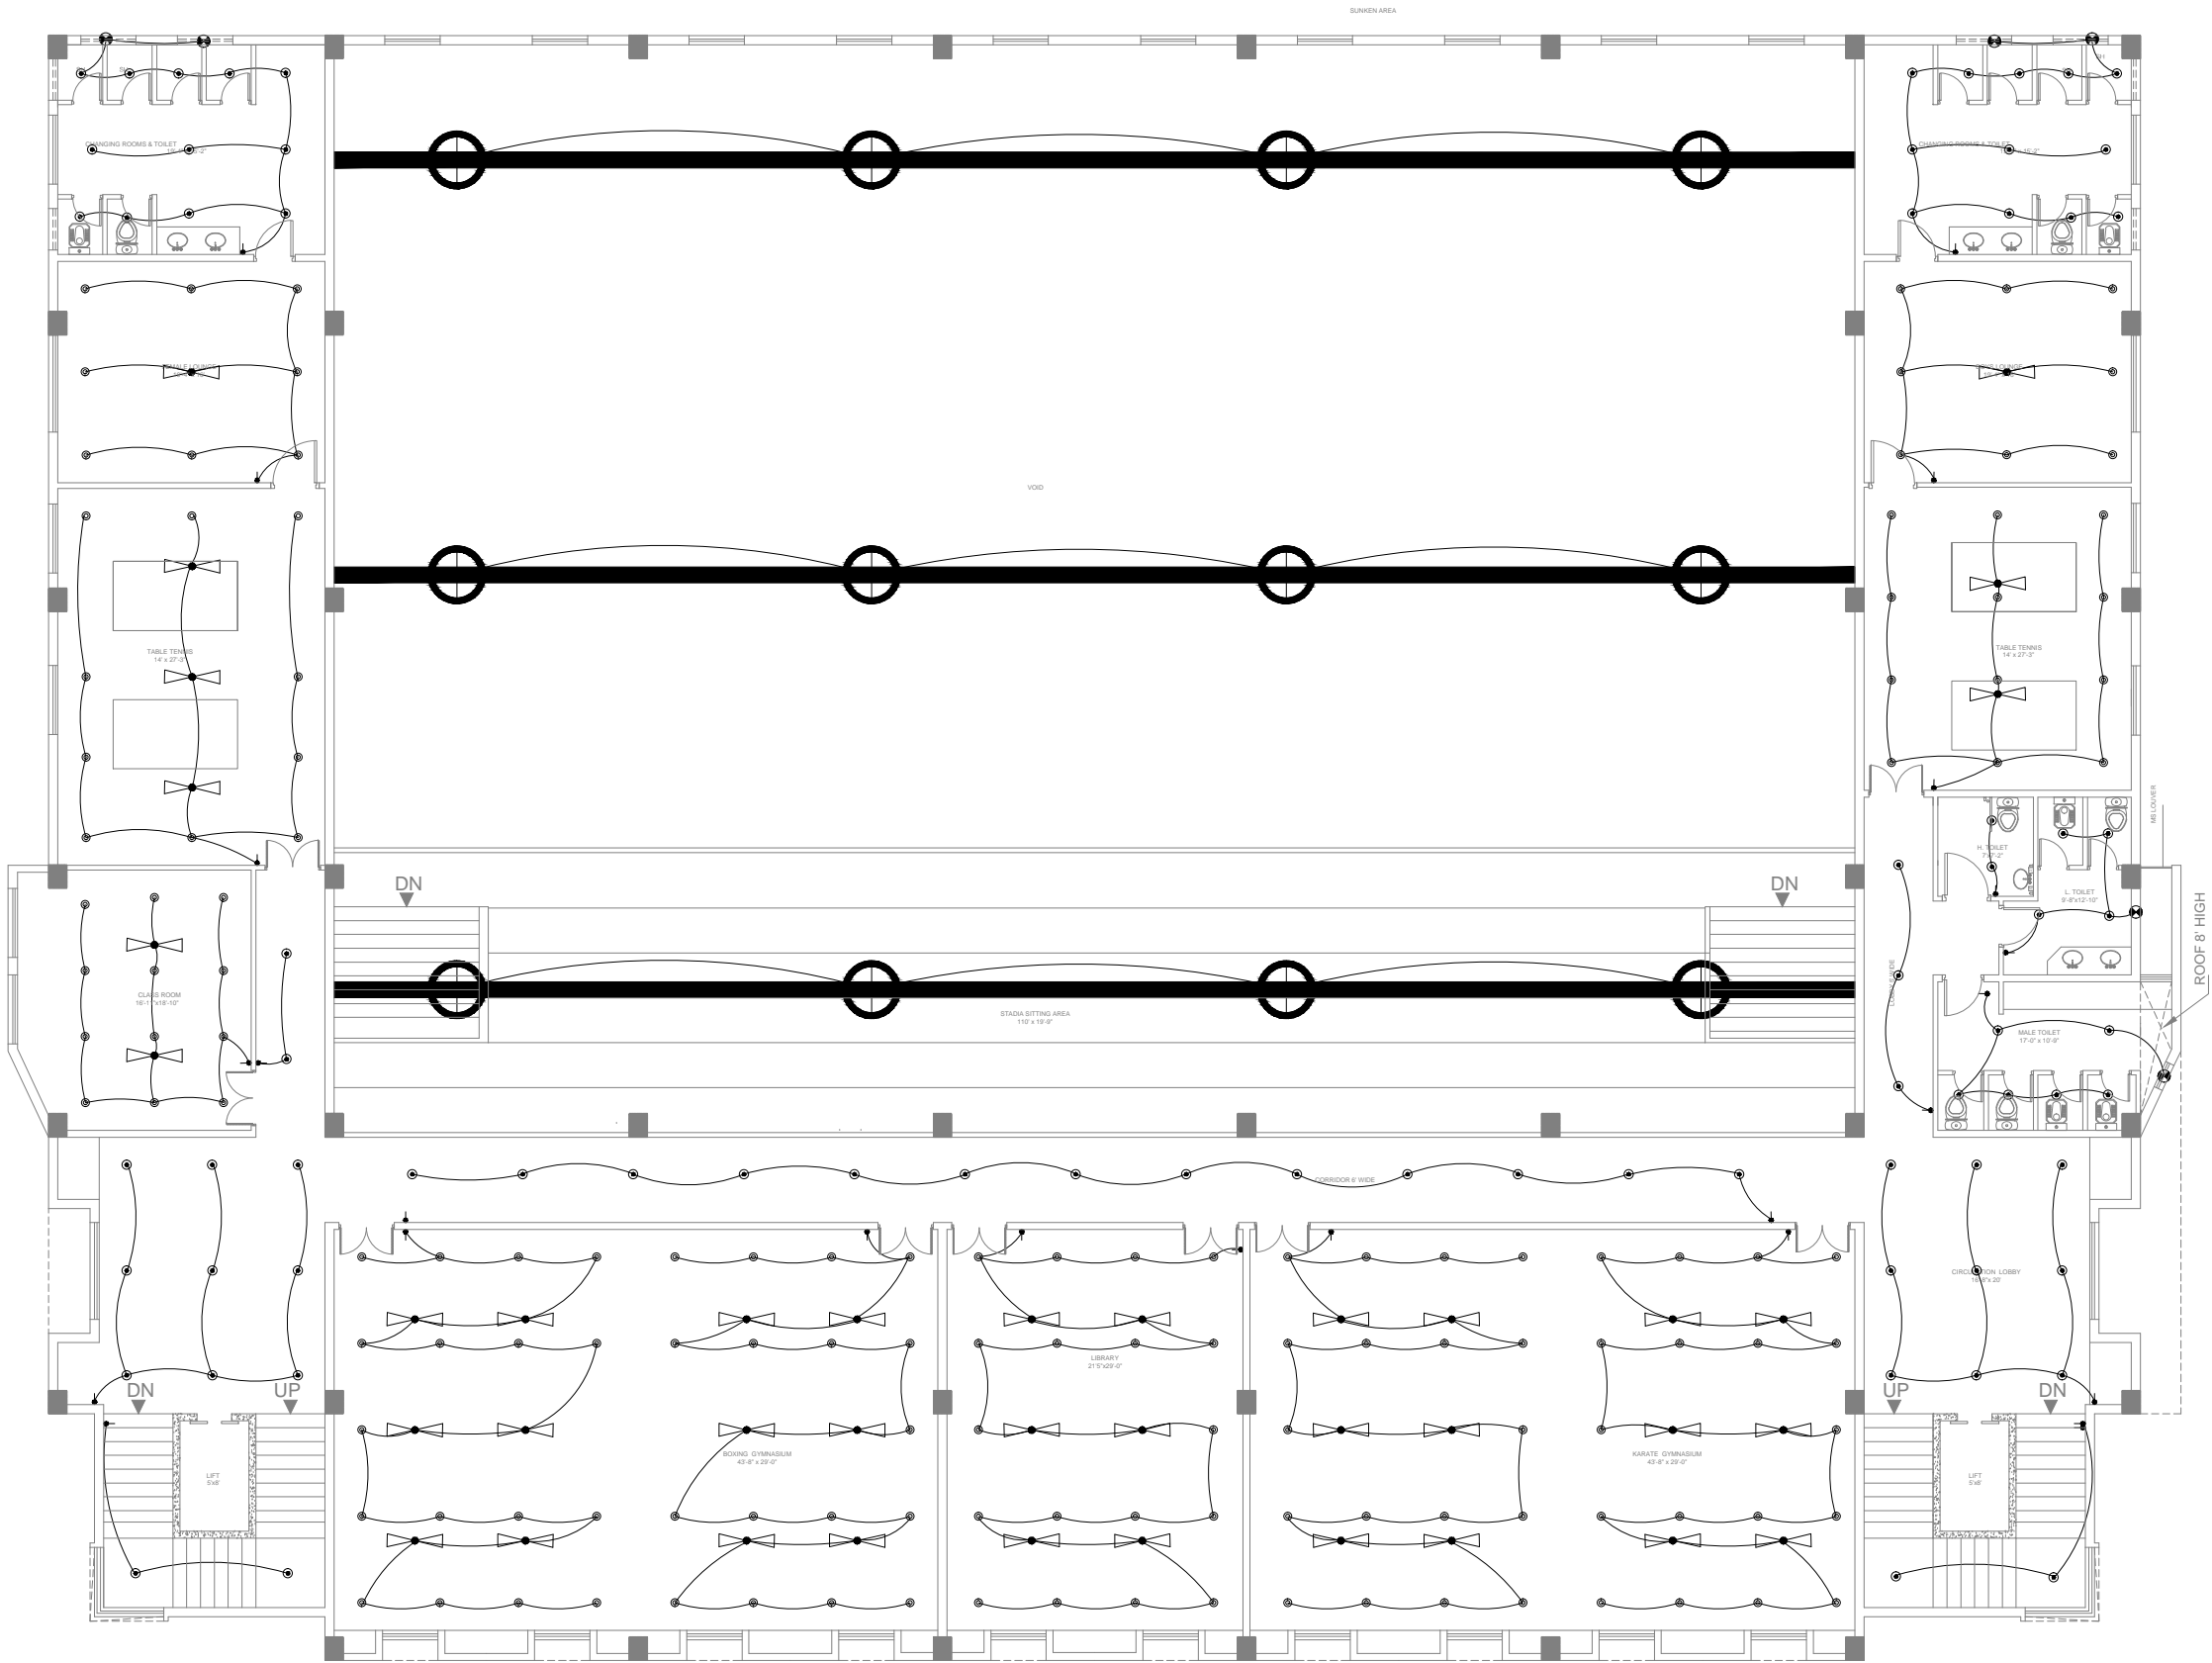

**FIRST FLOOR PLAN**  
COVERED AREA 17,700 SFT

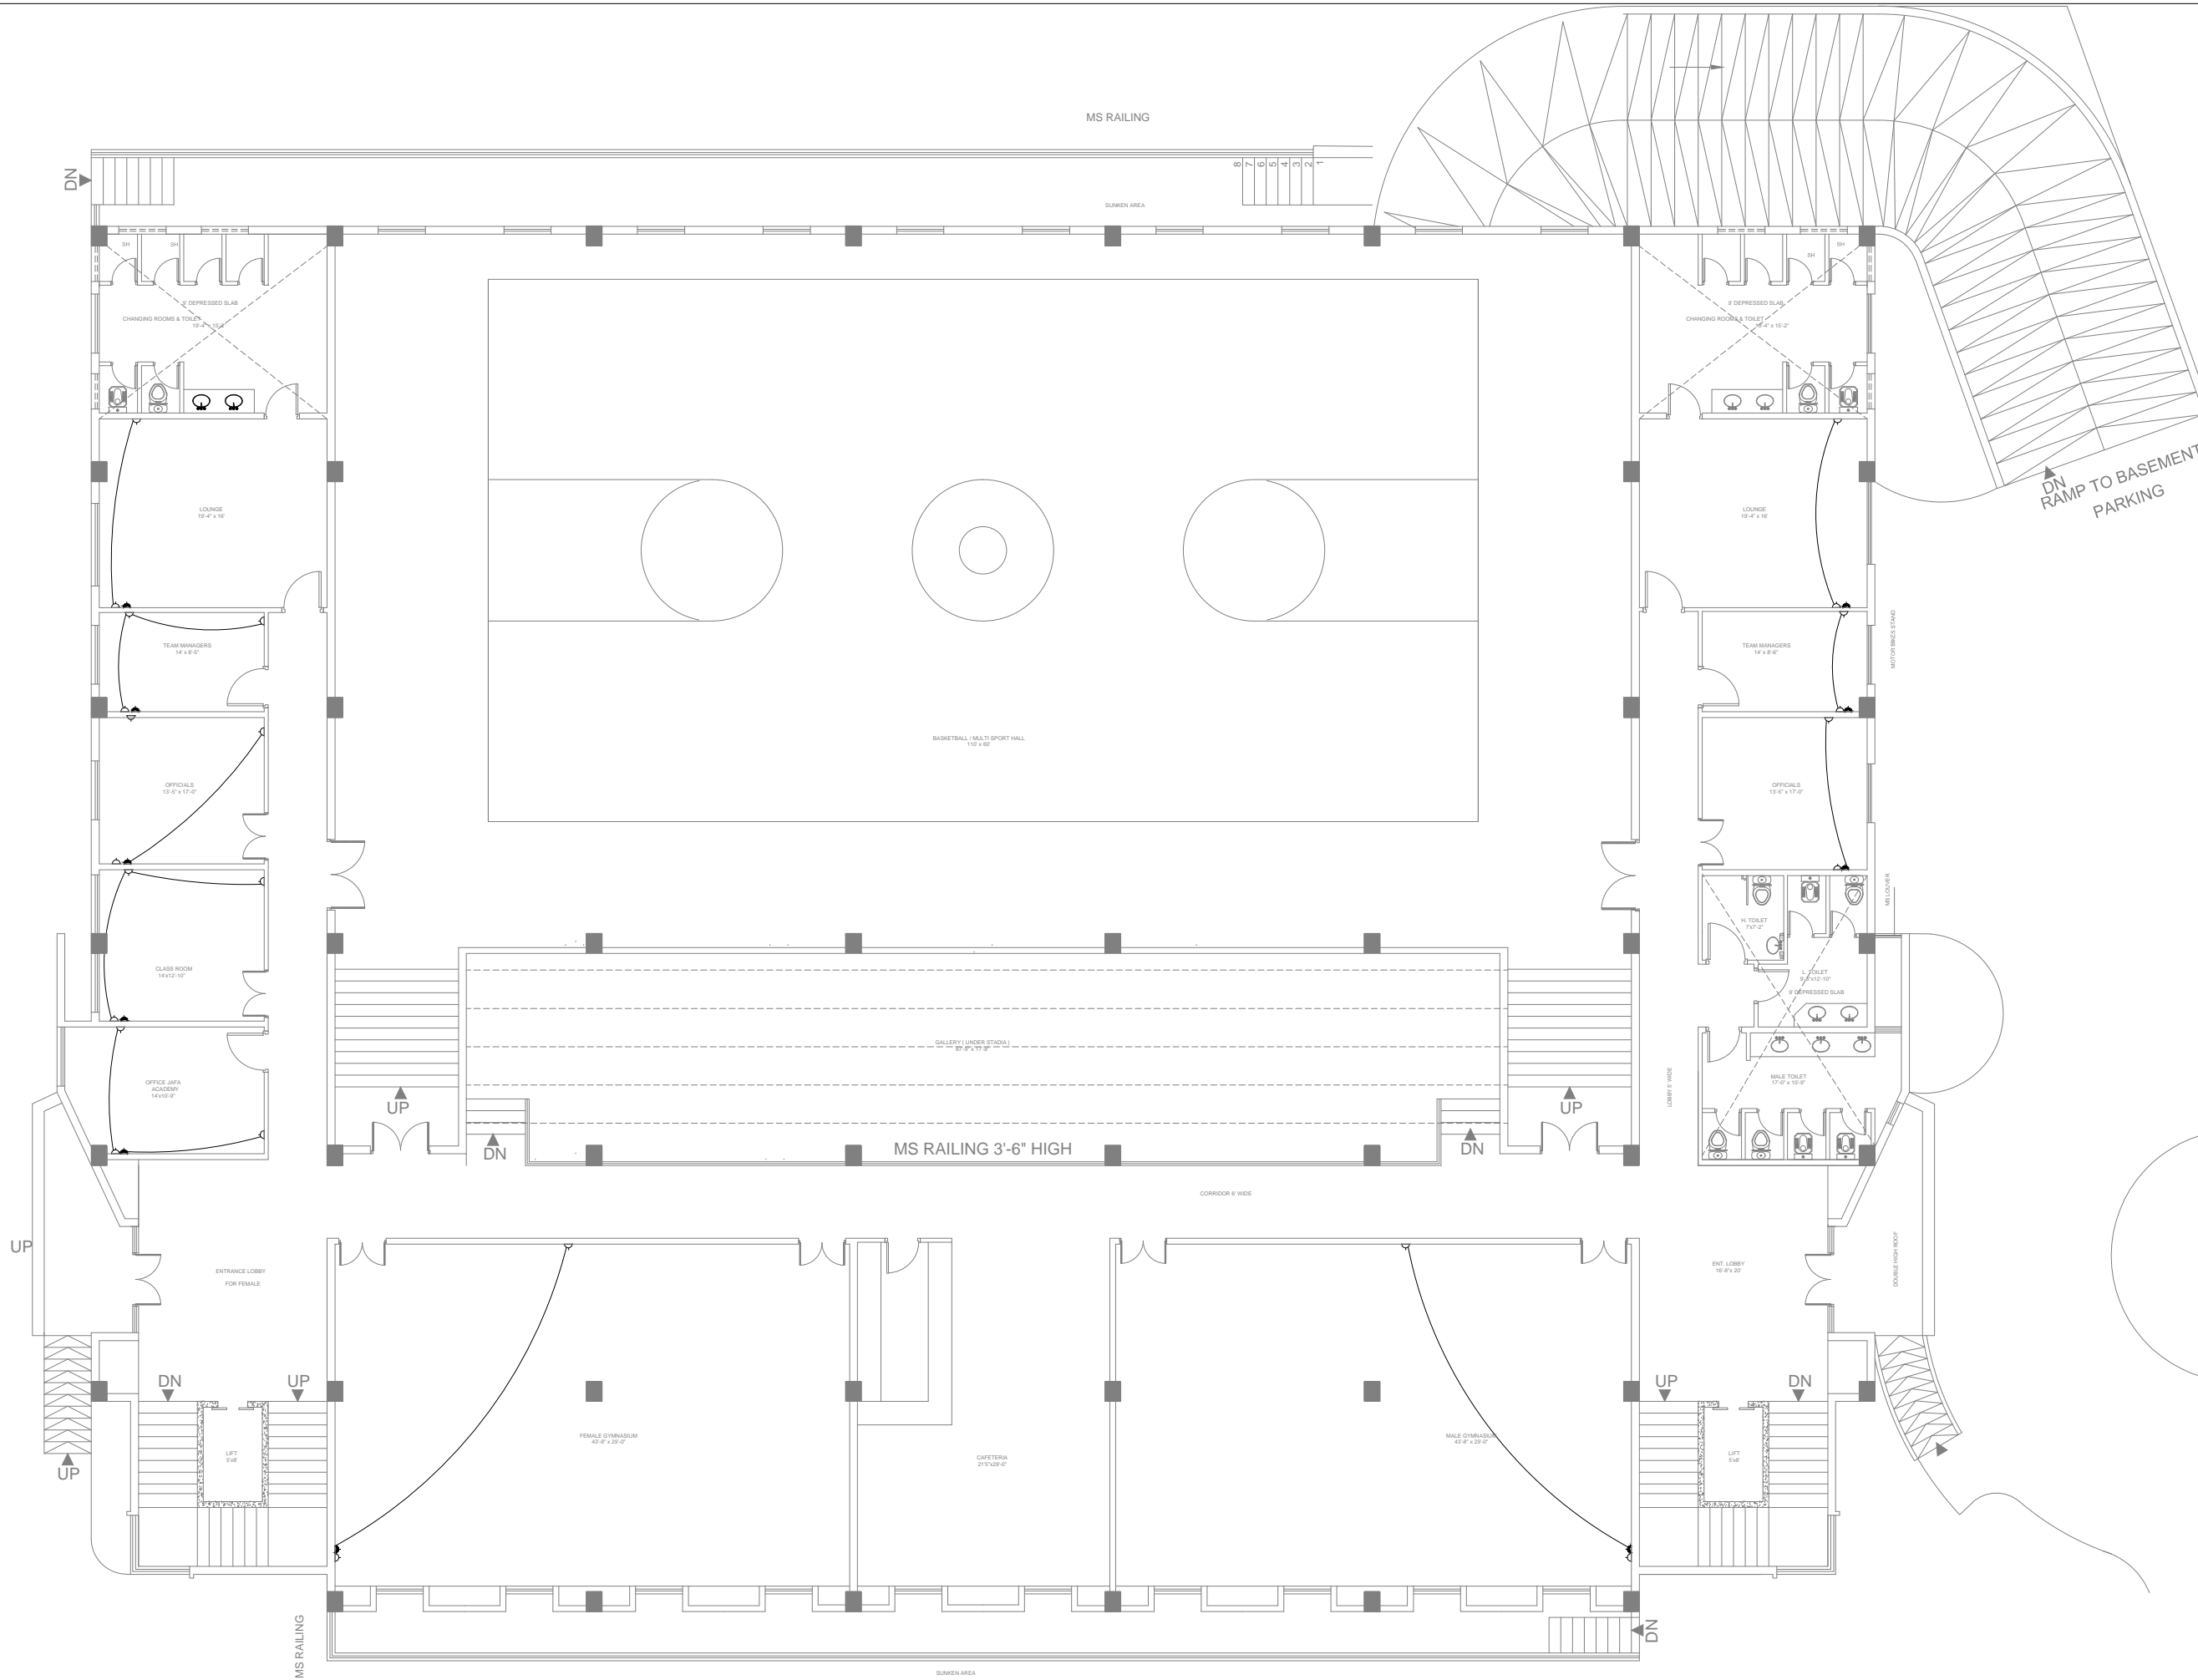

GROUND FLOOR PLAN  
COVERED AREA 10,975 SFT

CLIENT:

PROJECT  
IMPLEMENTATION  
UNIT (PIU) KNIP



CONSULTANTS:  
G3 ENGINEERING  
CONSULTANTS (PVT) LTD.  
House No.57-M Gulberg-III, Lahore, Pakistan  
Tel : (92-42) 35441641, 35441642  
Fax : (92-42) 35441645  
E-mail : info@g3ec.com  
URL : www.g3ec.com

PROJECT:  
Karachi Neighbourhood  
Improvement Project (KNIP)

SUB PROJECT:  
Redevelopment of Kakri Sports  
Complex and Neighborhood  
Improvement


NOTES:  
1. ALL DIMENSIONS ARE IN FEET UNLESS  
OTHERWISE SPECIFIED.  
2. THIS DRAWING IS AN INTELLECTUAL PROPERTY  
OF G3 ENGINEERING CONSULTANTS (PVT.) LTD.  
AND CANNOT BE REPRINTED OR REPRODUCED  
WITHOUT PRIOR APPROVAL OF G3.

REVISIONS:		
No.	DESCRIPTION	DATE

TENDER DRAWINGS


DRAWING TITLE: PURPOSED MULTIPURPOSE HALL GROUND FLOOR POWER DISTRIBUTION LAYOUT	
DRAWN BY: M.Raffeh	DATE: SEP 2021
CHECKED BY: Eng.Ghulam Daraz Shaikh	
Approved BY: Syed Ali Abbas Gillani	
DRAWING NO: 0249/MPH/012	REV: 0
SCALE (A3): N.T.S	SHEET: 00/00



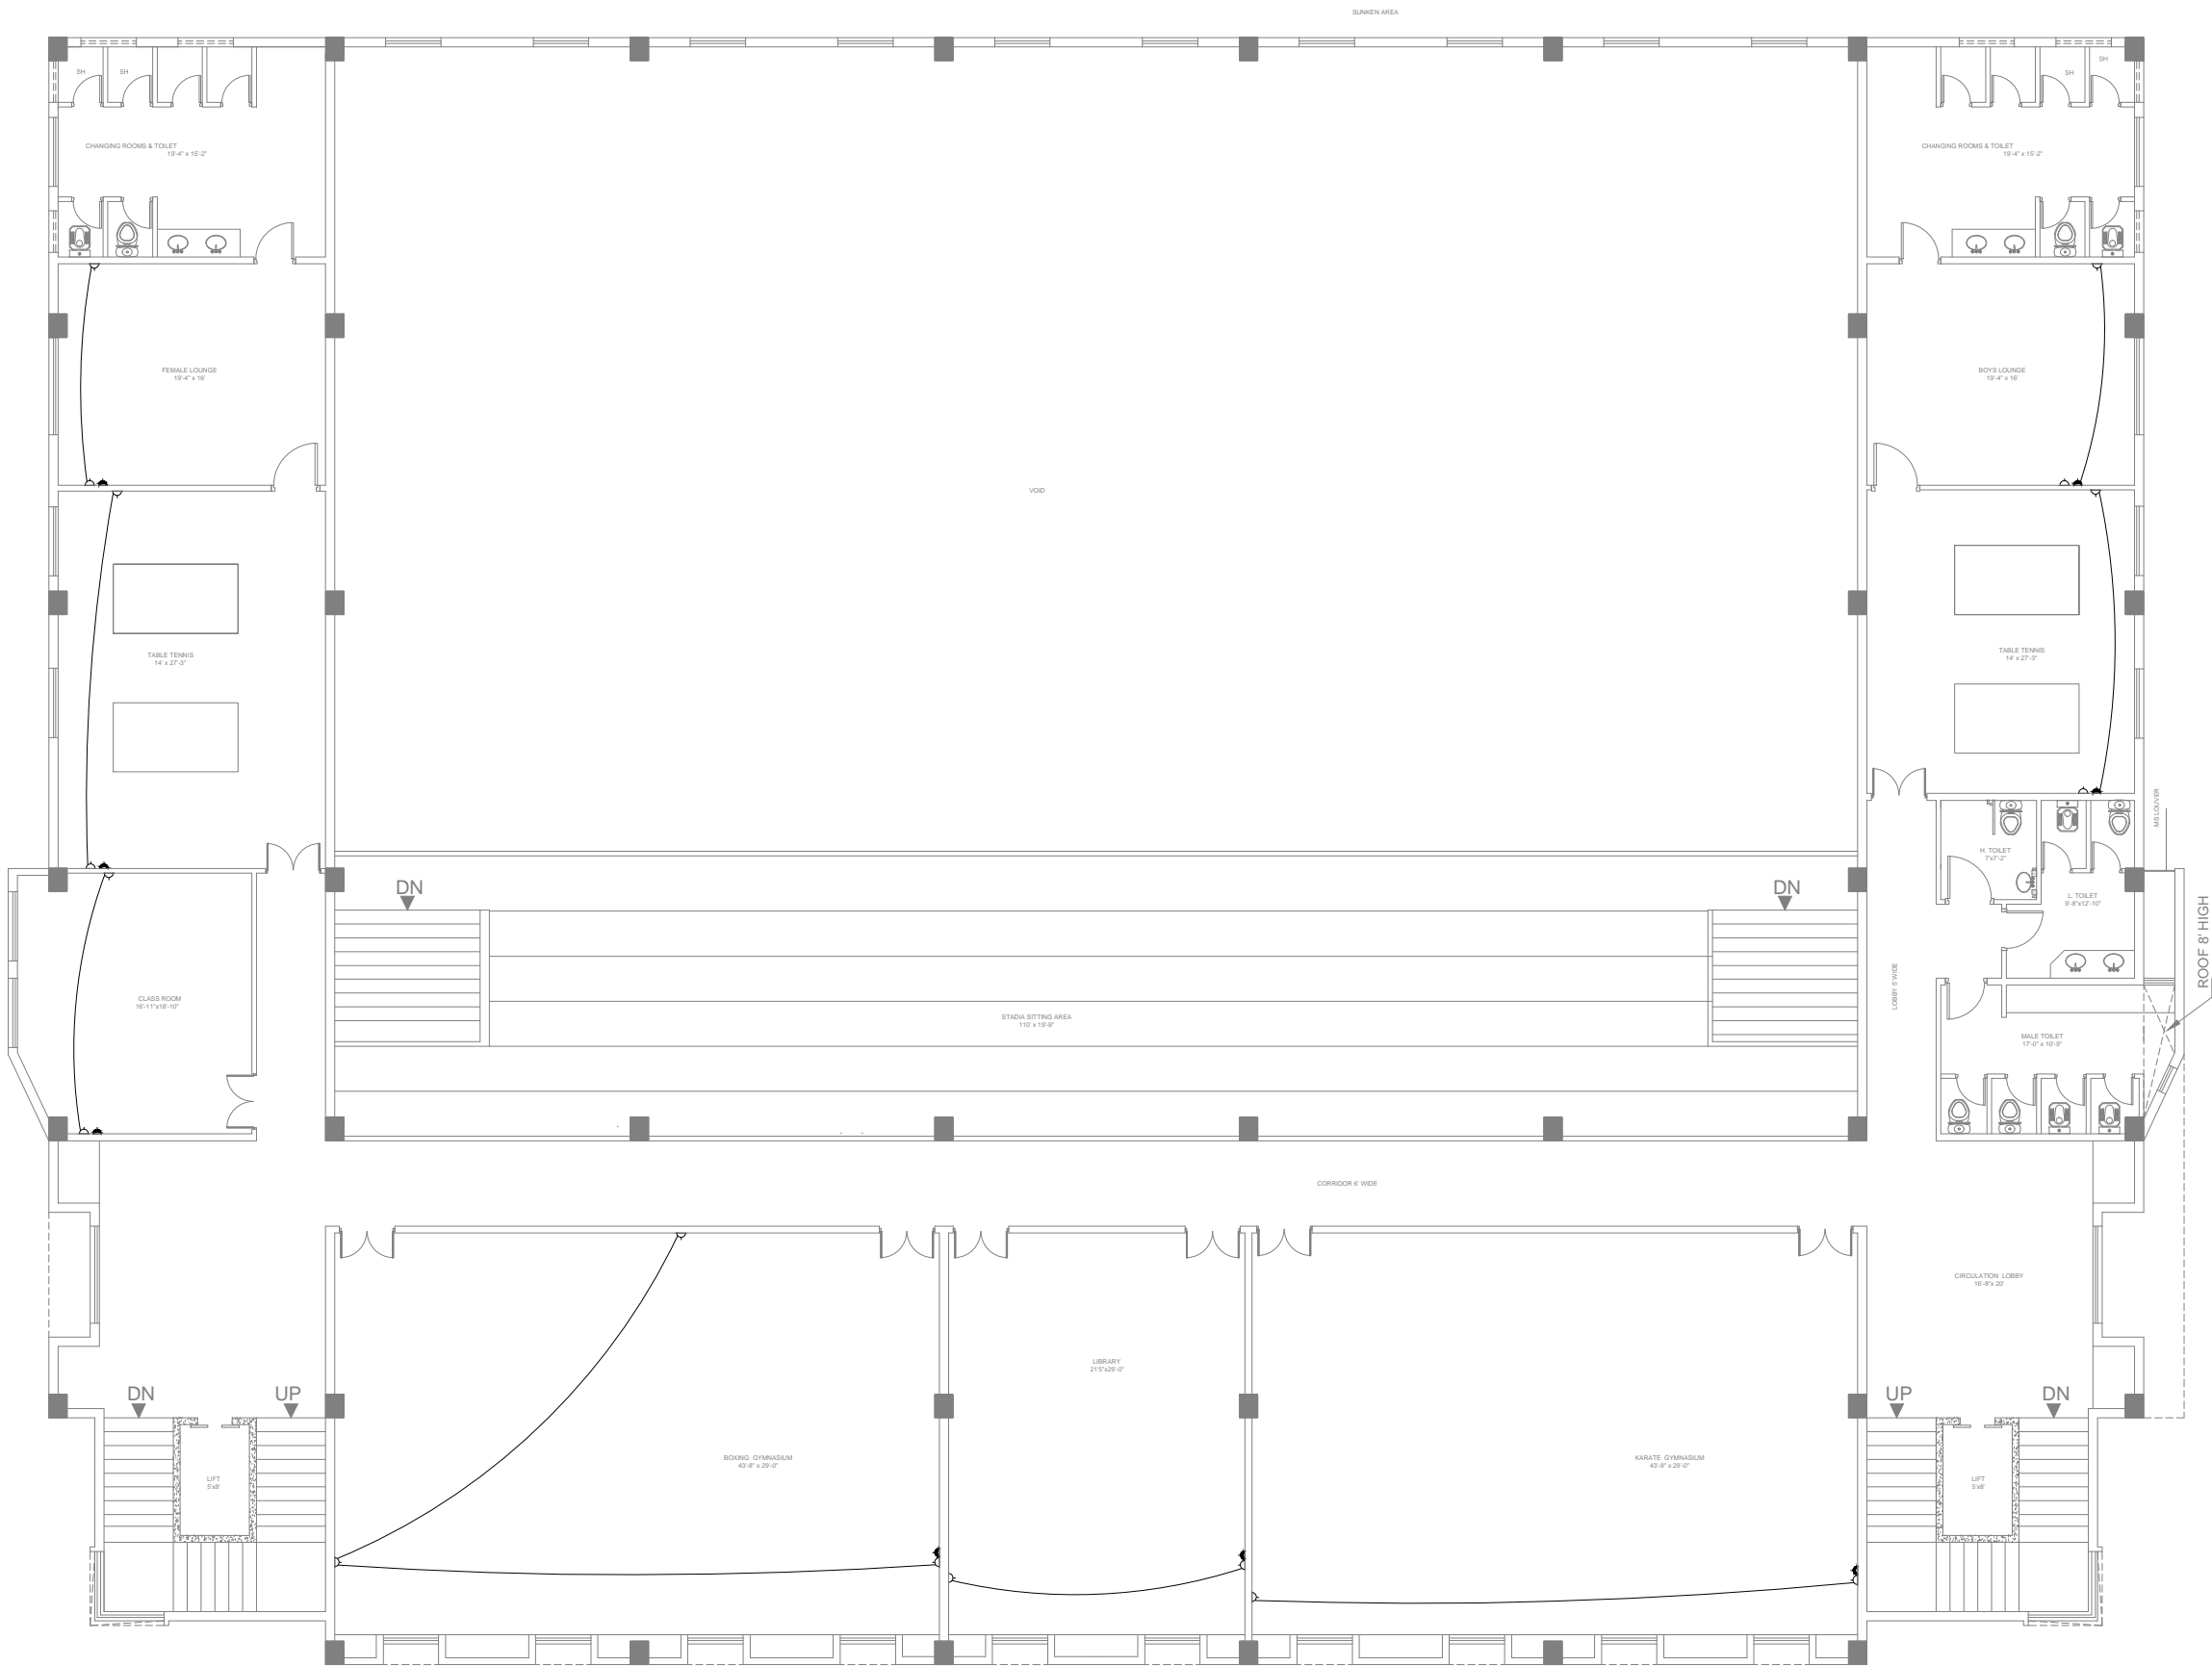

FIRST FLOOR PLAN  
COVERED AREA 17,700 SFT

CLIENT:

 PROJECT  
IMPLEMENTATION  
UNIT (PIU) KNIP



**CONSULTANTS:**  
G3 ENGINEERING  
CONSULTANTS (PVT) LTD.  
House No.57-M Gulberg-III, Lahore, Pakistan  
Tel : (92-42) 35441641, 35441642  
Fax : (92-42) 35441645  
E-mail : info@g3ec.com  
URL : www.g3ec.com

PROJECT:  
**Karachi Neighbourhood  
Improvement Project (KNIP)**

SUB PROJECT:  
**Redevelopment of Kakri Sports  
Complex and Neighborhood  
Improvement**

NOTES:  
1. ALL DIMENSIONS ARE IN FEET UNLESS  
OTHERWISE SPECIFIED.  
2. THIS DRAWING IS AN INTELLECTUAL PROPERTY  
OF G3 ENGINEERING CONSULTANTS (PVT.) LTD.  
AND CANNOT BE REPRINTED OR REPRODUCED  
WITHOUT PRIOR APPROVAL OF G3.

REVISIONS:		
No.	DESCRIPTION	DATE

TENDER DRAWINGS

DRAWING TITLE:  
PURPOSED MULTIPURPOSE  
HALL FIRST FLOOR  
POWER DISTRIBUTION  
LAYOUT

DRAWN BY:  
M.Raffeh

DATE:  
SEP 2021

CHECKED BY:  
Eng.Ghulam Daraz Shaikh


Approved BY:  
Syed Ali Abbas Gillani

DRAWING NO:  
0249/MPH/013

REV:  
0

SCALE (A3):  
N.T.S

SHEET:  
00/00

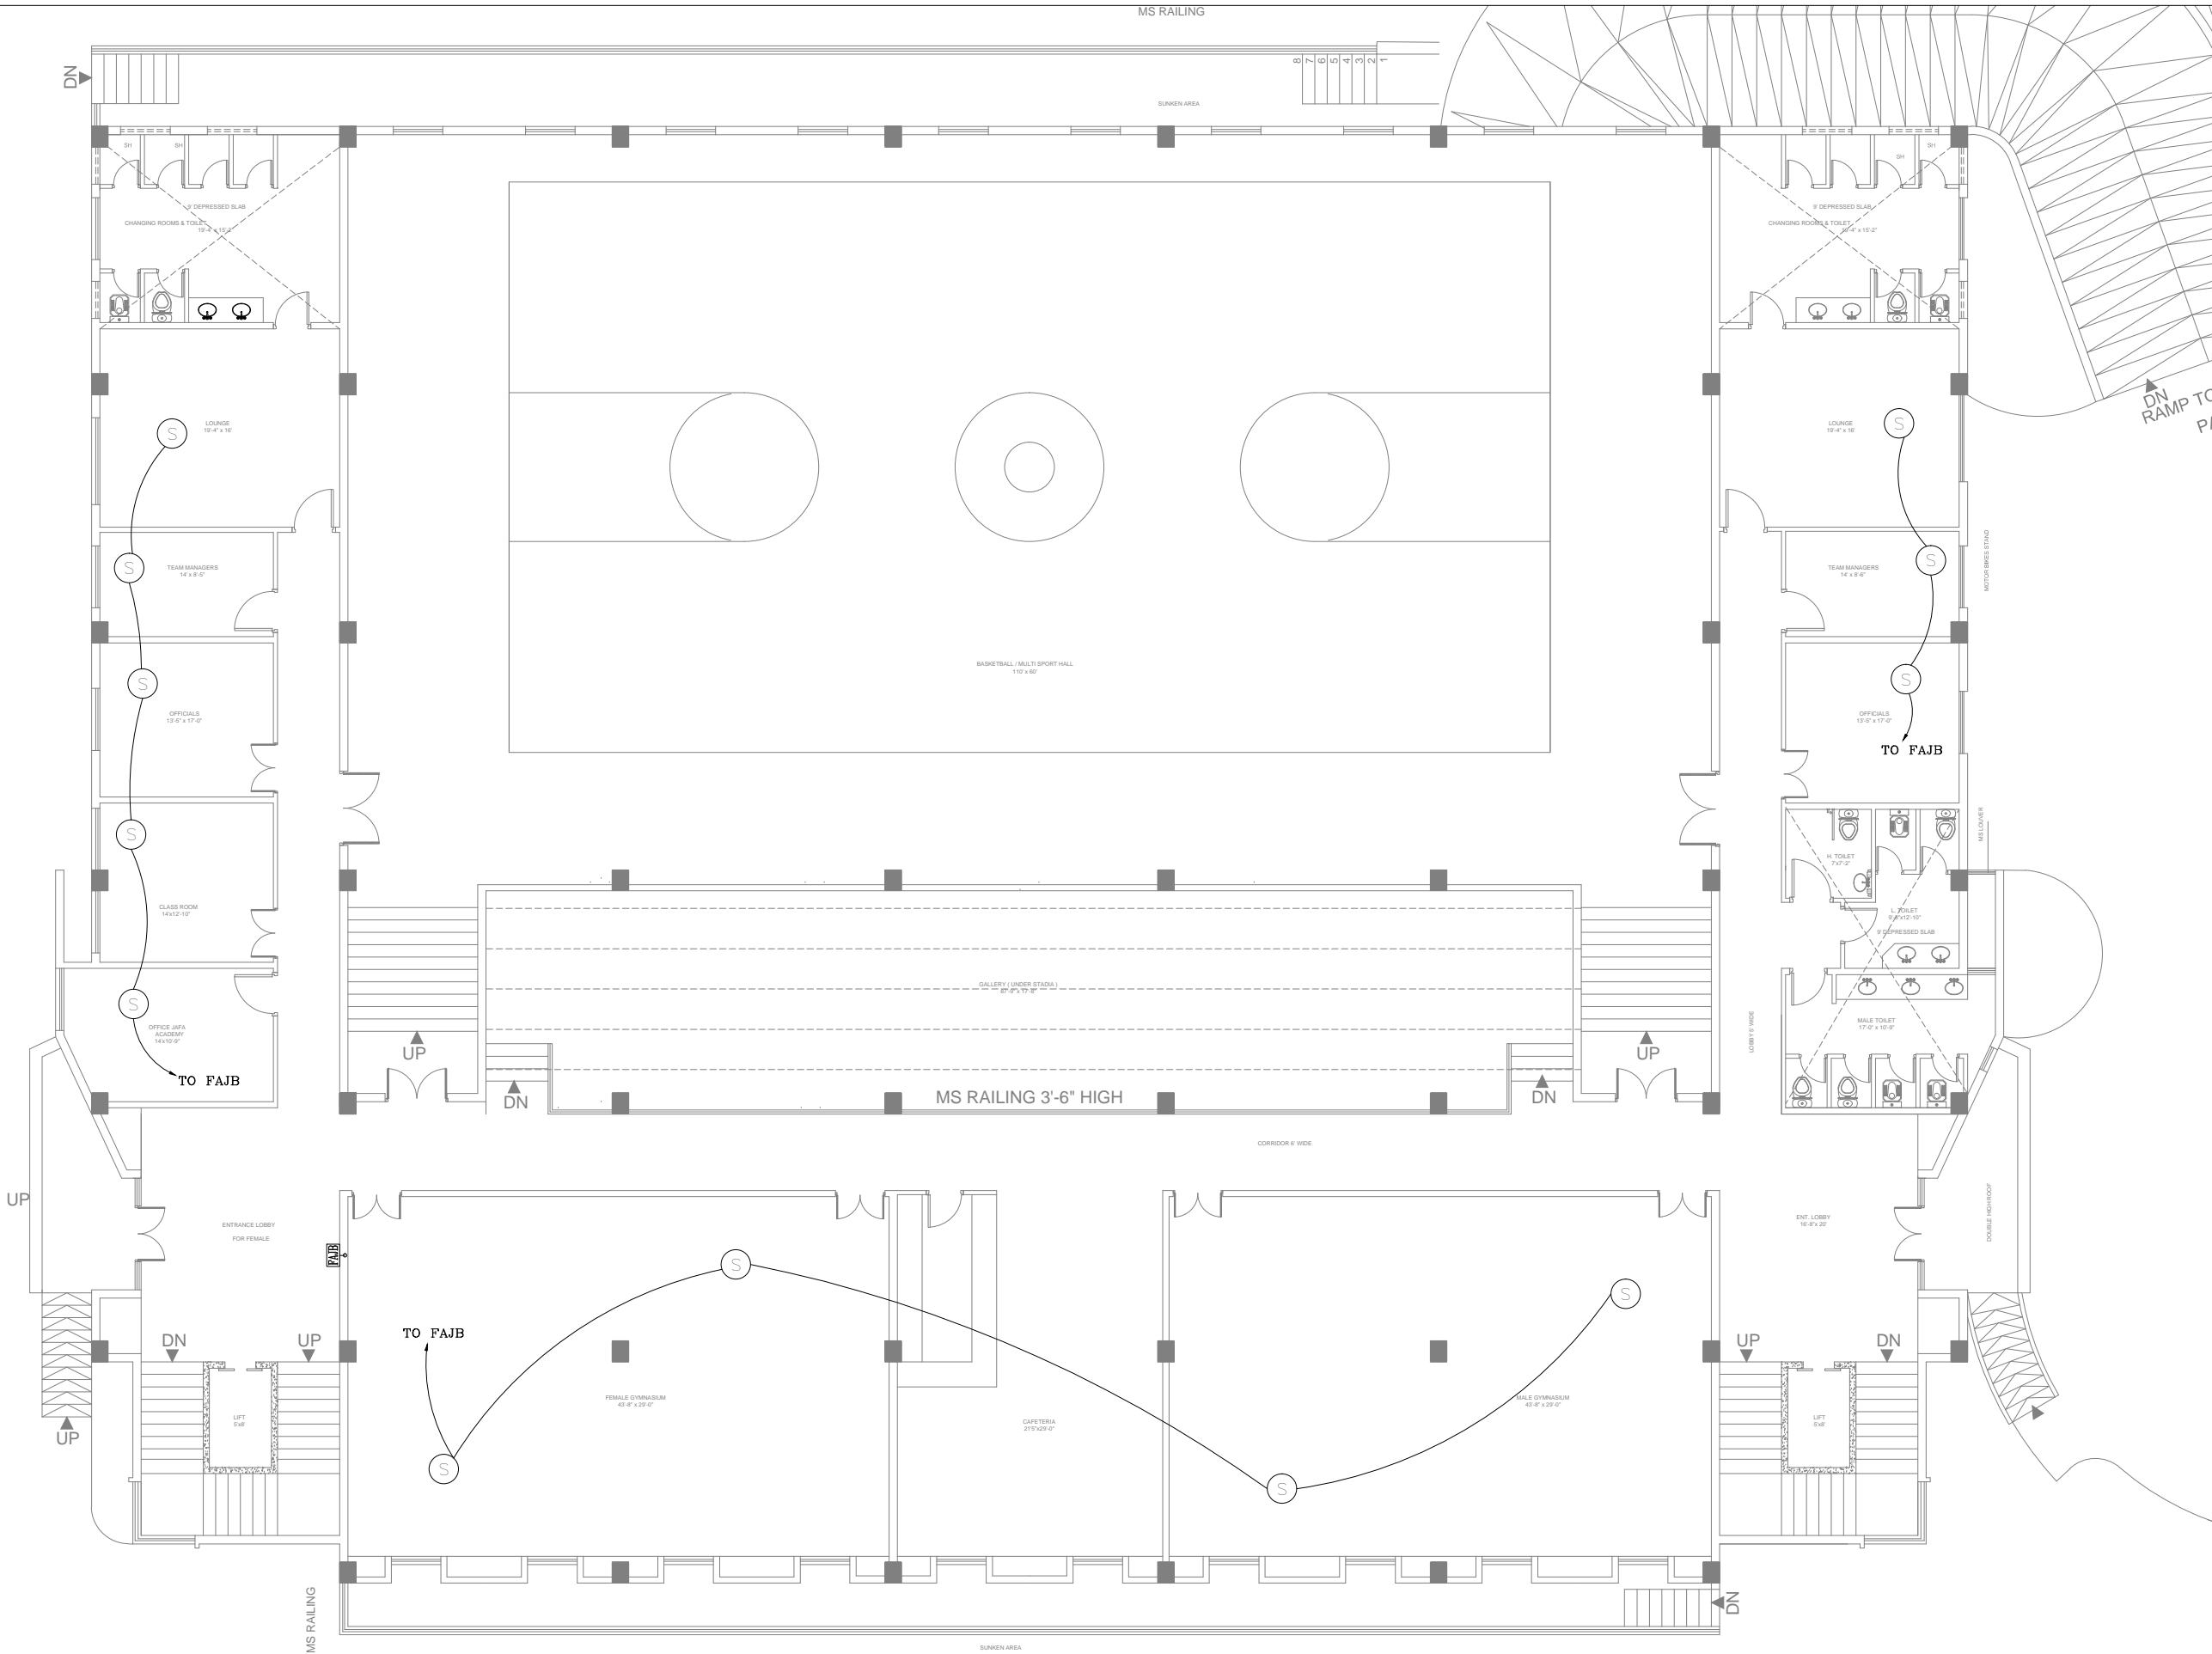

GROUND FLOOR PLAN  
COVERED AREA 10,975 SFT

CLIENT:

PROJECT  
IMPLEMENTATION  
UNIT (PIU) KNIP



CONSULTANTS:  
G3 ENGINEERING  
CONSULTANTS (PVT) LTD.  
House No.57-M Gulberg-III, Lahore, Pakistan  
Tel : (92-42) 35441641, 35441642  
Fax : (92-42) 35441645  
E-mail : info@g3ec.com  
URL : www.g3ec.com

PROJECT:  
**Karachi Neighbourhood  
Improvement Project (KNIP)**

SUB PROJECT:  
**Redevelopment of Kakri Sports  
Complex and Neighborhood  
Improvement**

NOTES:  
1. ALL DIMENSIONS ARE IN FEET UNLESS  
OTHERWISE SPECIFIED.  
2. THIS DRAWING IS AN INTELLECTUAL PROPERTY  
OF G3 ENGINEERING CONSULTANTS (PVT.) LTD.  
AND CANNOT BE REPRINTED OR REPRODUCED  
WITHOUT PRIOR APPROVAL OF G3.

REVISIONS:		
No.	DESCRIPTION	DATE

TENDER DRAWINGS


DRAWING TITLE:  
**PURPOSED MULTIPURPOSE  
HALL GROUND FLOOR  
FIRE ALARM SYSTEM**

DRAWN BY: M.Raffeh	DATE: SEP 2021
CHECKED BY: Eng.Ghulam Daraz Shaikh	
Approved BY: Syed Ali Abbas Gillani	
DRAWING NO: 0249/MPH/014	REV: 0
SCALE (A3): N.T.S	SHEET: 00/00



DRAWN BY: M. Raffeh	DATE: SEP 2021
CHECKED BY: Eng. Ghulam Daraz Shaikh	
Approved BY: Syed Ali Abbas Gillani	
DRAWING NO: 0249/MPH/015	REV: 0
SCALE (A3): N.T.S	SHEET: 00/00



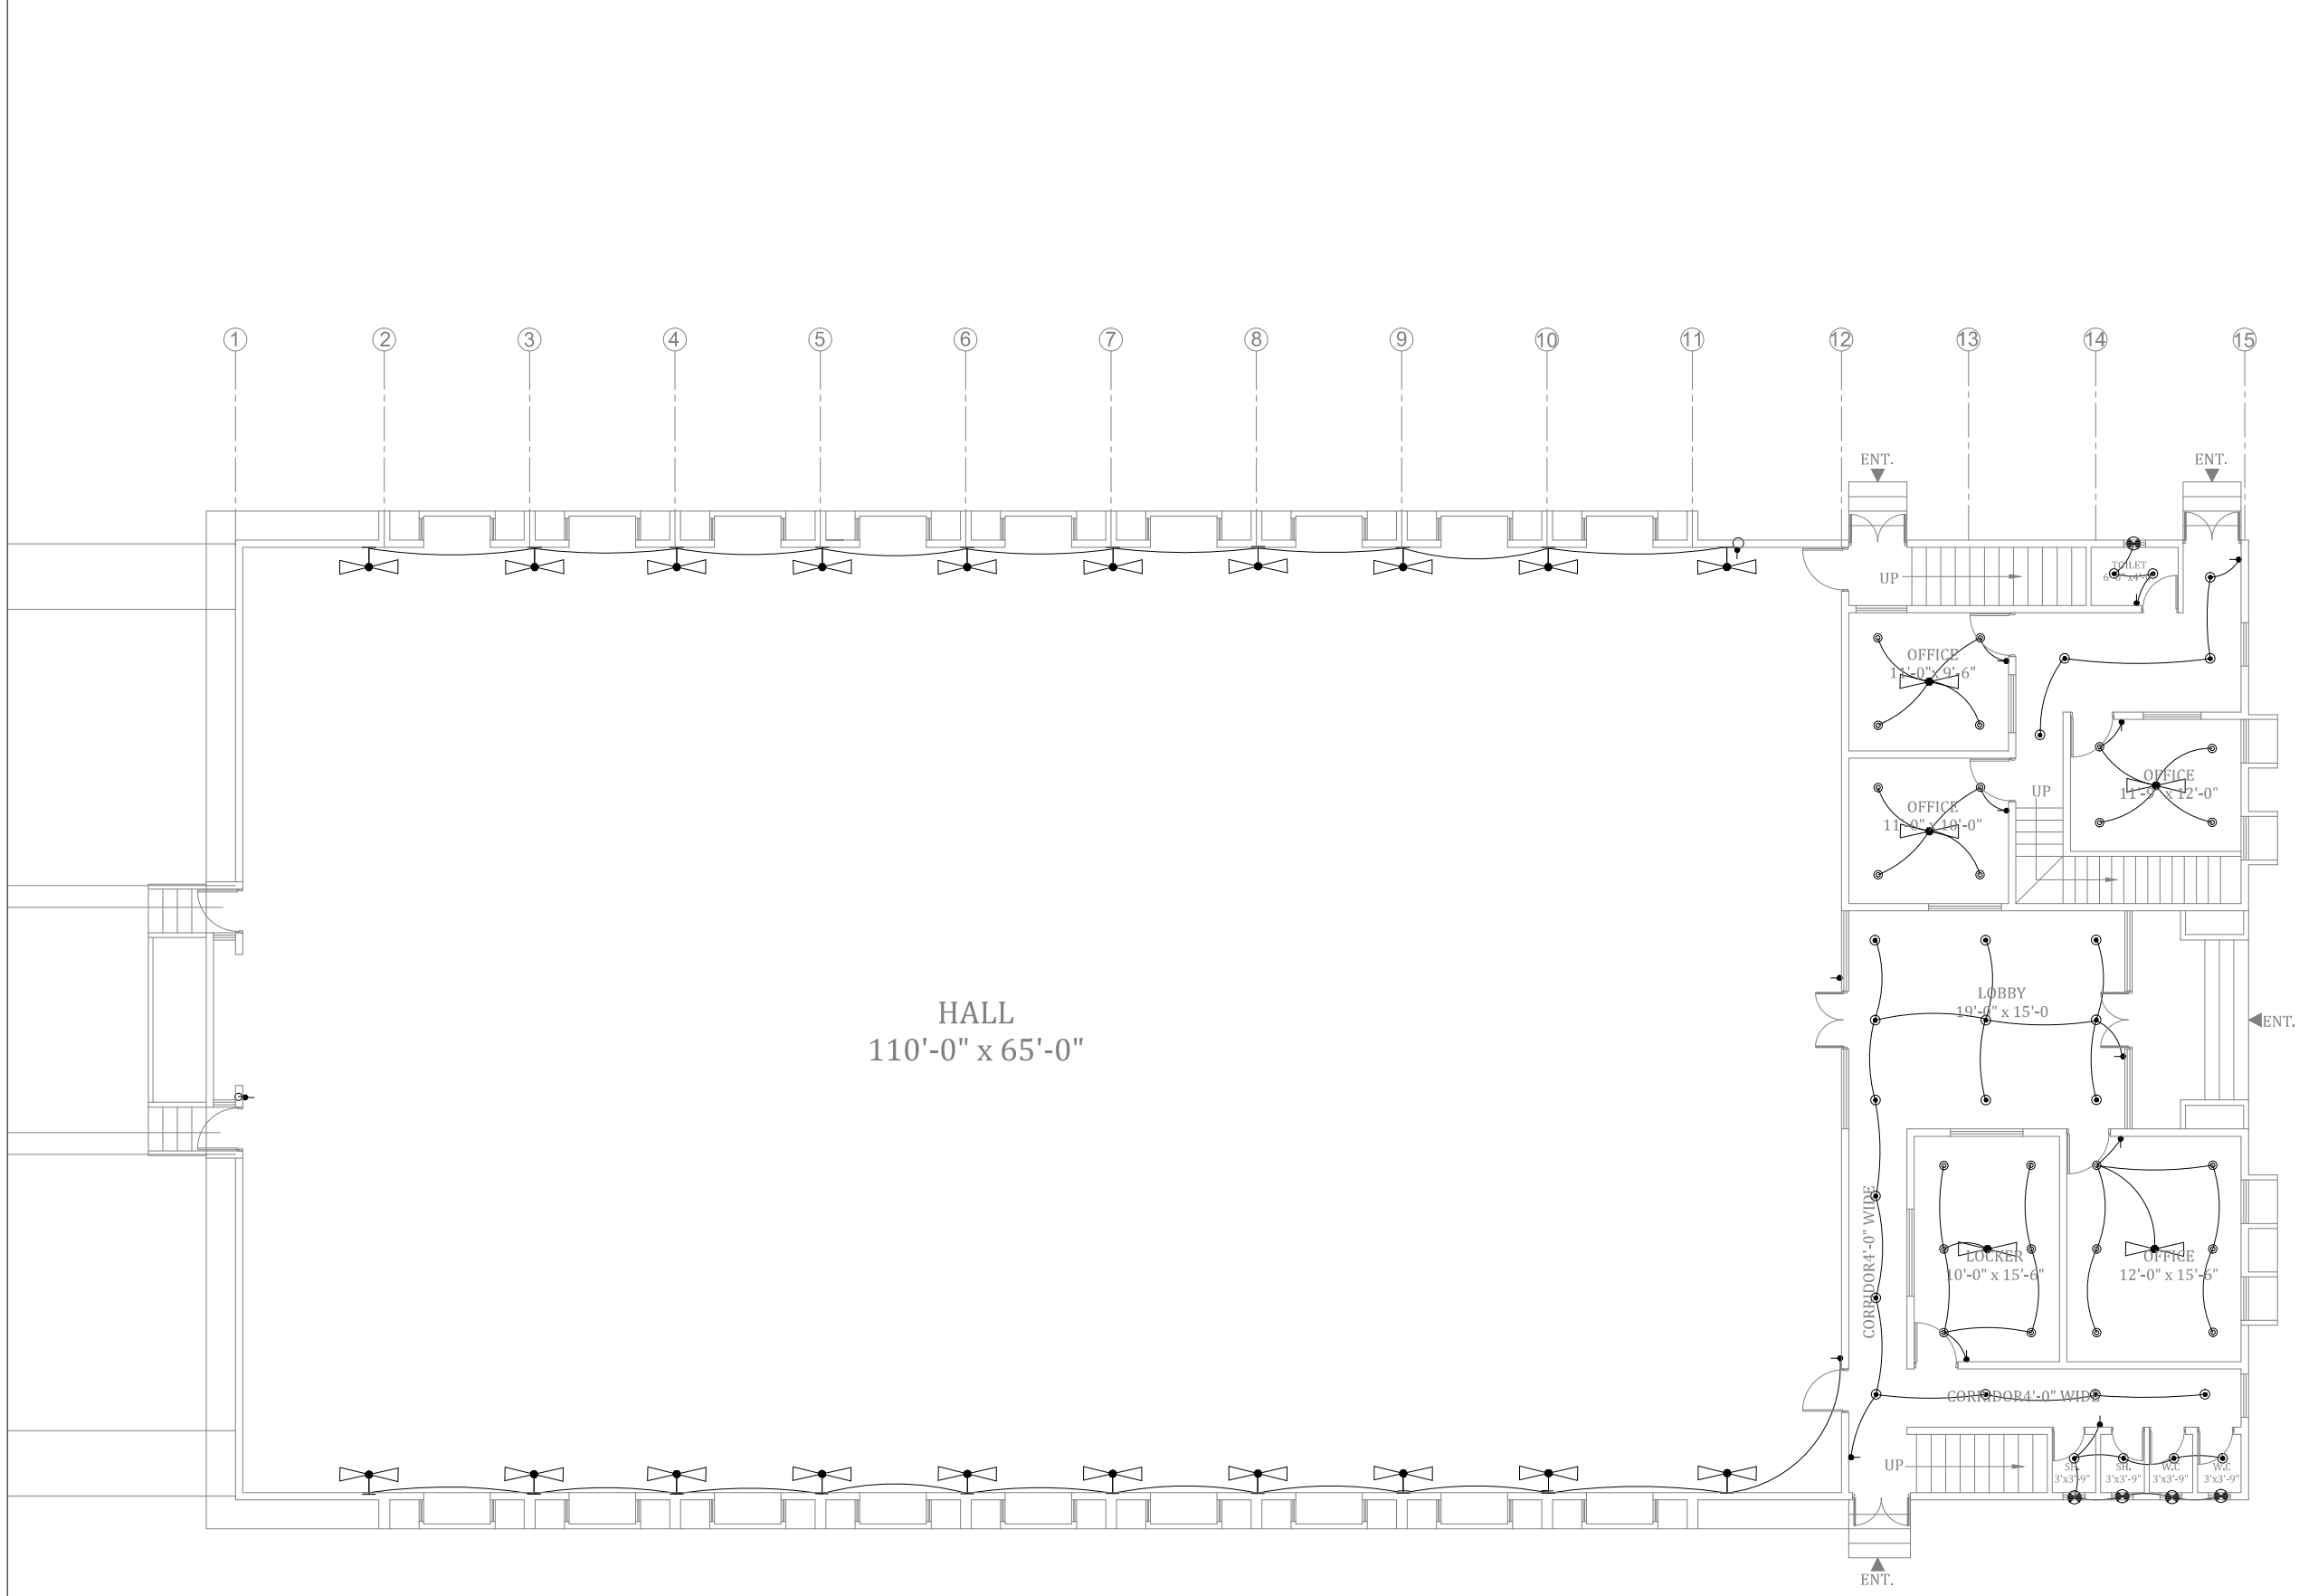

GROUND FLOOR PLAN

CLIENT:

PROJECT  
IMPLEMENTATION  
UNIT (PIU) KNIP



CONSULTANTS:  
G3 ENGINEERING  
CONSULTANTS (PVT.) LTD.  
House No.57-M Gulberg-III, Lahore, Pakistan  
Tel : (92-42) 35441641, 35441642  
Fax : (92-42) 35441645  
E-mail : info@g3ec.com  
URL : www.g3ec.com

PROJECT:  
**Karachi Neighbourhood  
Improvement Project (KNIP)**

SUB PROJECT:  
**Redevelopment of Kakri Sports  
Complex and Neighborhood  
Improvement**

NOTES:  
1. ALL DIMENSIONS ARE IN FEET UNLESS  
OTHERWISE SPECIFIED.  
2. THIS DRAWING IS AN INTELLECTUAL PROPERTY  
OF G3 ENGINEERING CONSULTANTS (PVT.) LTD.  
AND CANNOT BE REPRINTED OR REPRODUCED  
WITHOUT PRIOR APPROVAL OF G3.

REVISIONS:		
No.	DESCRIPTION	DATE

TENDER DRAWINGS

DRAWING TITLE:  
**EXISTING GYMNASIUM  
GROUND FLOOR  
ILLUMINATION LAYOUT**

DRAWN BY: M.Raffeh	DATE: SEP 2021
CHECKED BY: Eng.Ghulam Daraz Shaikh	
Approved BY: Syed Ali Abbas Gillani	
DRAWING NO: 0249/EMPH/016	REV: 0
SCALE (A3): N.T.S	SHEET: 00/00



016

**G3 ENGINEERING  
CONSULTANTS (PVT)LTD.**  
House No.57-M Gulberg-II, Lahore, Pakistan

Tel : (92-42) 35441641, 35441642  
Fax : (92-42) 35441645  
E-mail : [info@g3ec.com](mailto:info@g3ec.com)  
URL : [www.g3ec.com](http://www.g3ec.com)

## Karachi Neighbourhood Improvement Project (KNIP)

### Redevelopment of Kakri Sports Complex and Neighborhood Improvement

1. ALL DIMENSIONS ARE IN FEET UNLESS OTHERWISE SPECIFIED.
2. THIS DRAWING IS AN INTELLECTUAL PROPERTY OF G3 ENGINEERING CONSULTANTS (PVT.) LTD. AND CANNOT BE REPRINTED OR REPRODUCED WITHOUT PRIOR APPROVAL OF G3.

[illegible]


DRAWING TITLE:  
EXISTING GYMNASIUM  
First Floor Illumination  
LAYOUT

CHECKED BY:  
Eng.Ghulam Daraz Shaikh


Approved BY:  
Syed Ali Abbas Gillani

DRAWING NO: 0249/EMPH/017	REV: 0
------------------------------	-----------

SCALE (A3): N.T.S	SHEET: 00/00
----------------------	-----------------

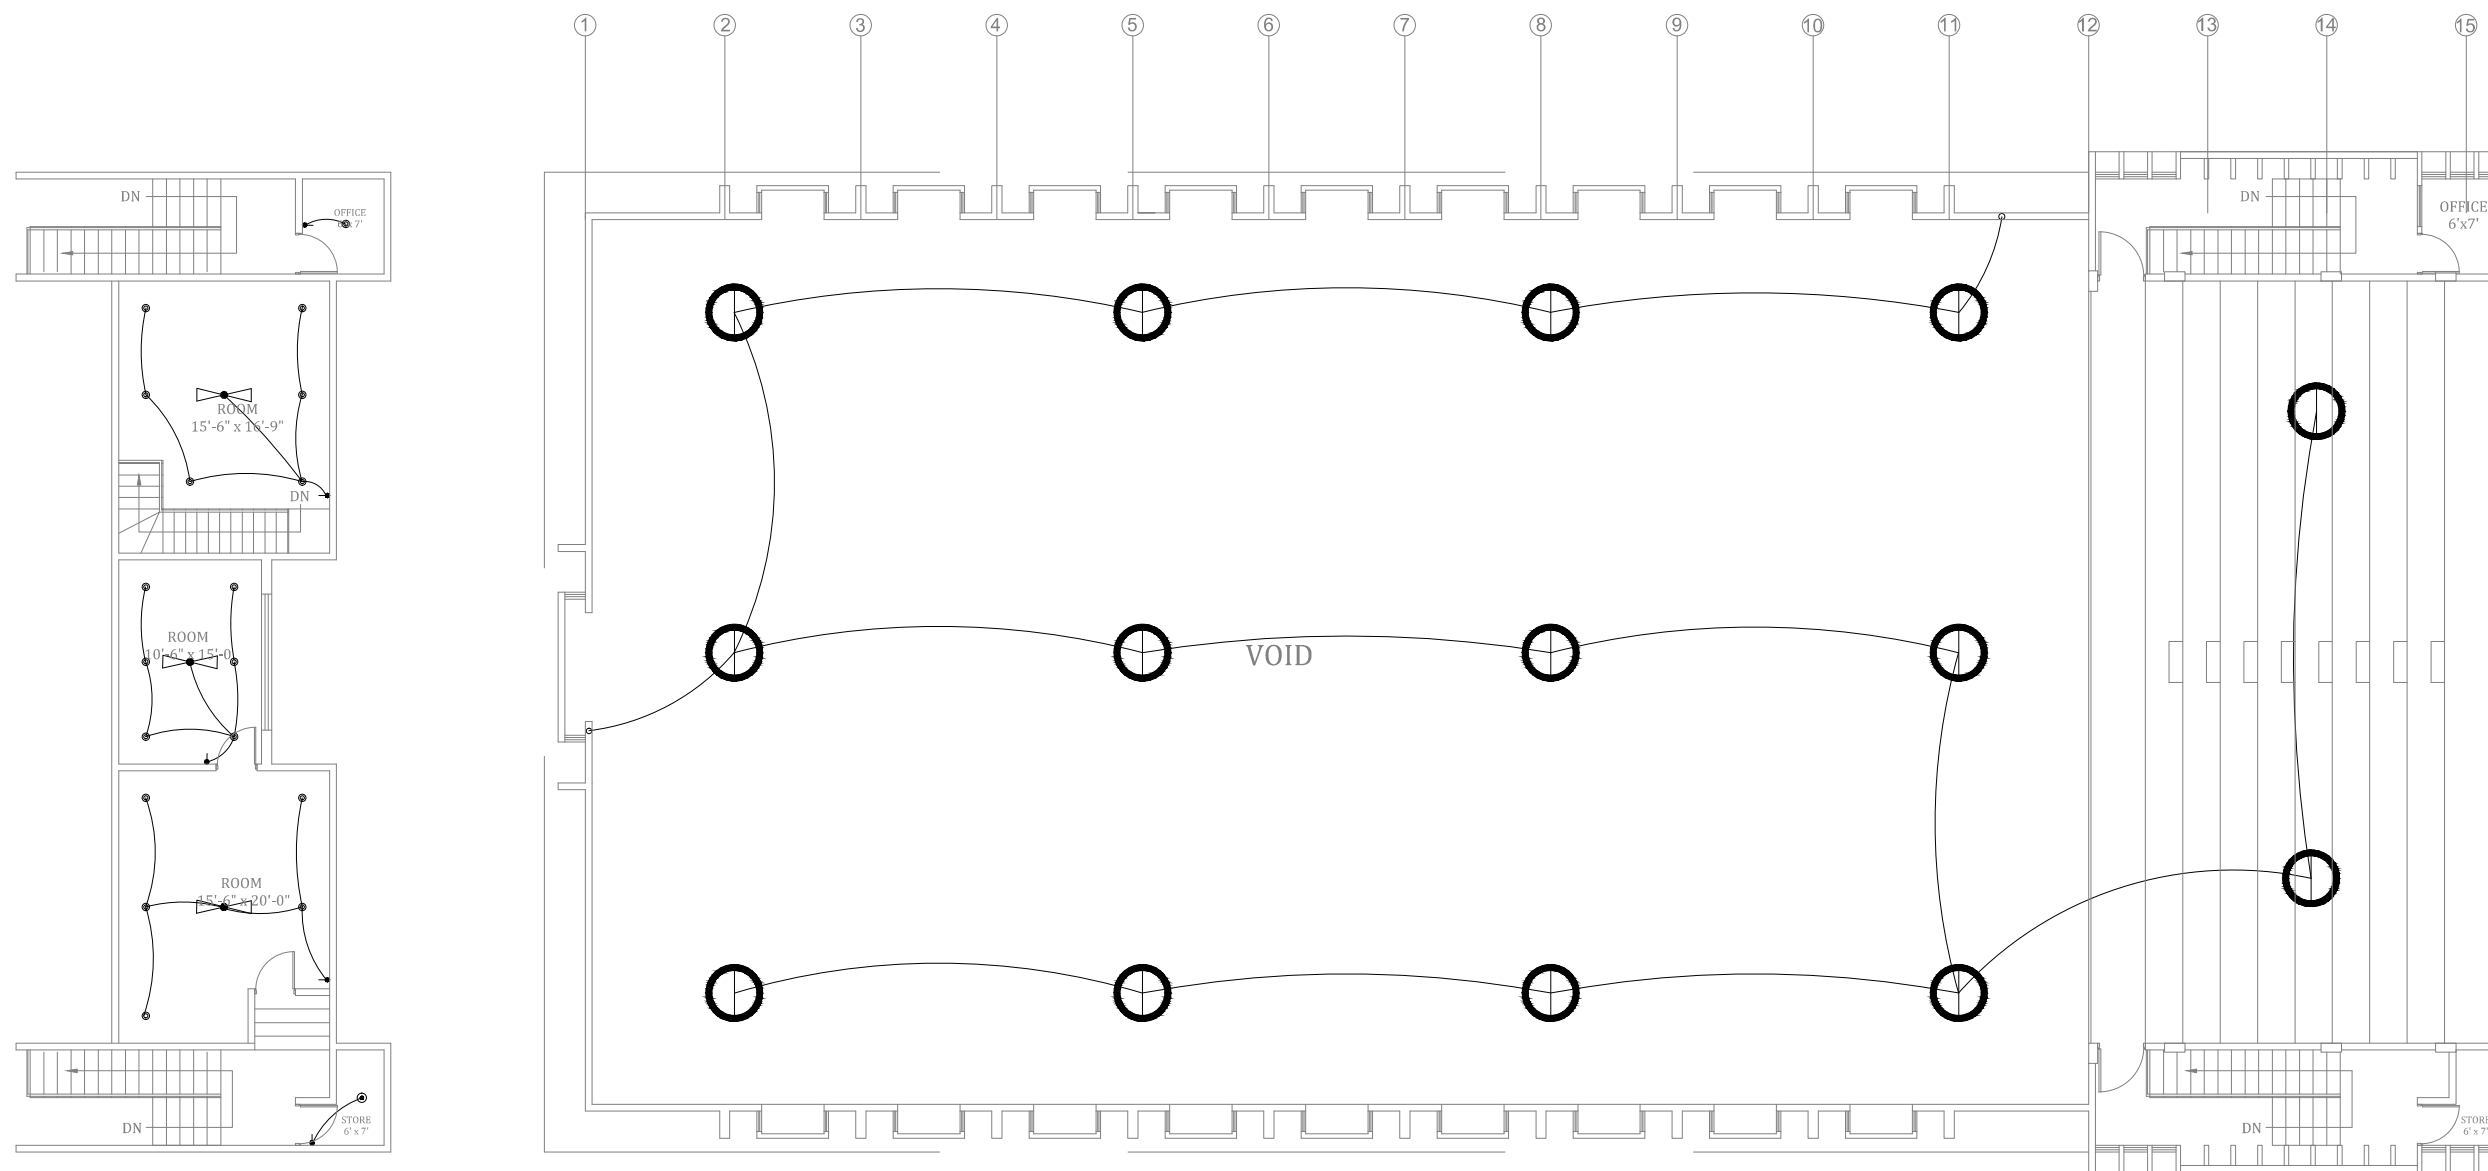

### FIRST FLOOR PLAN

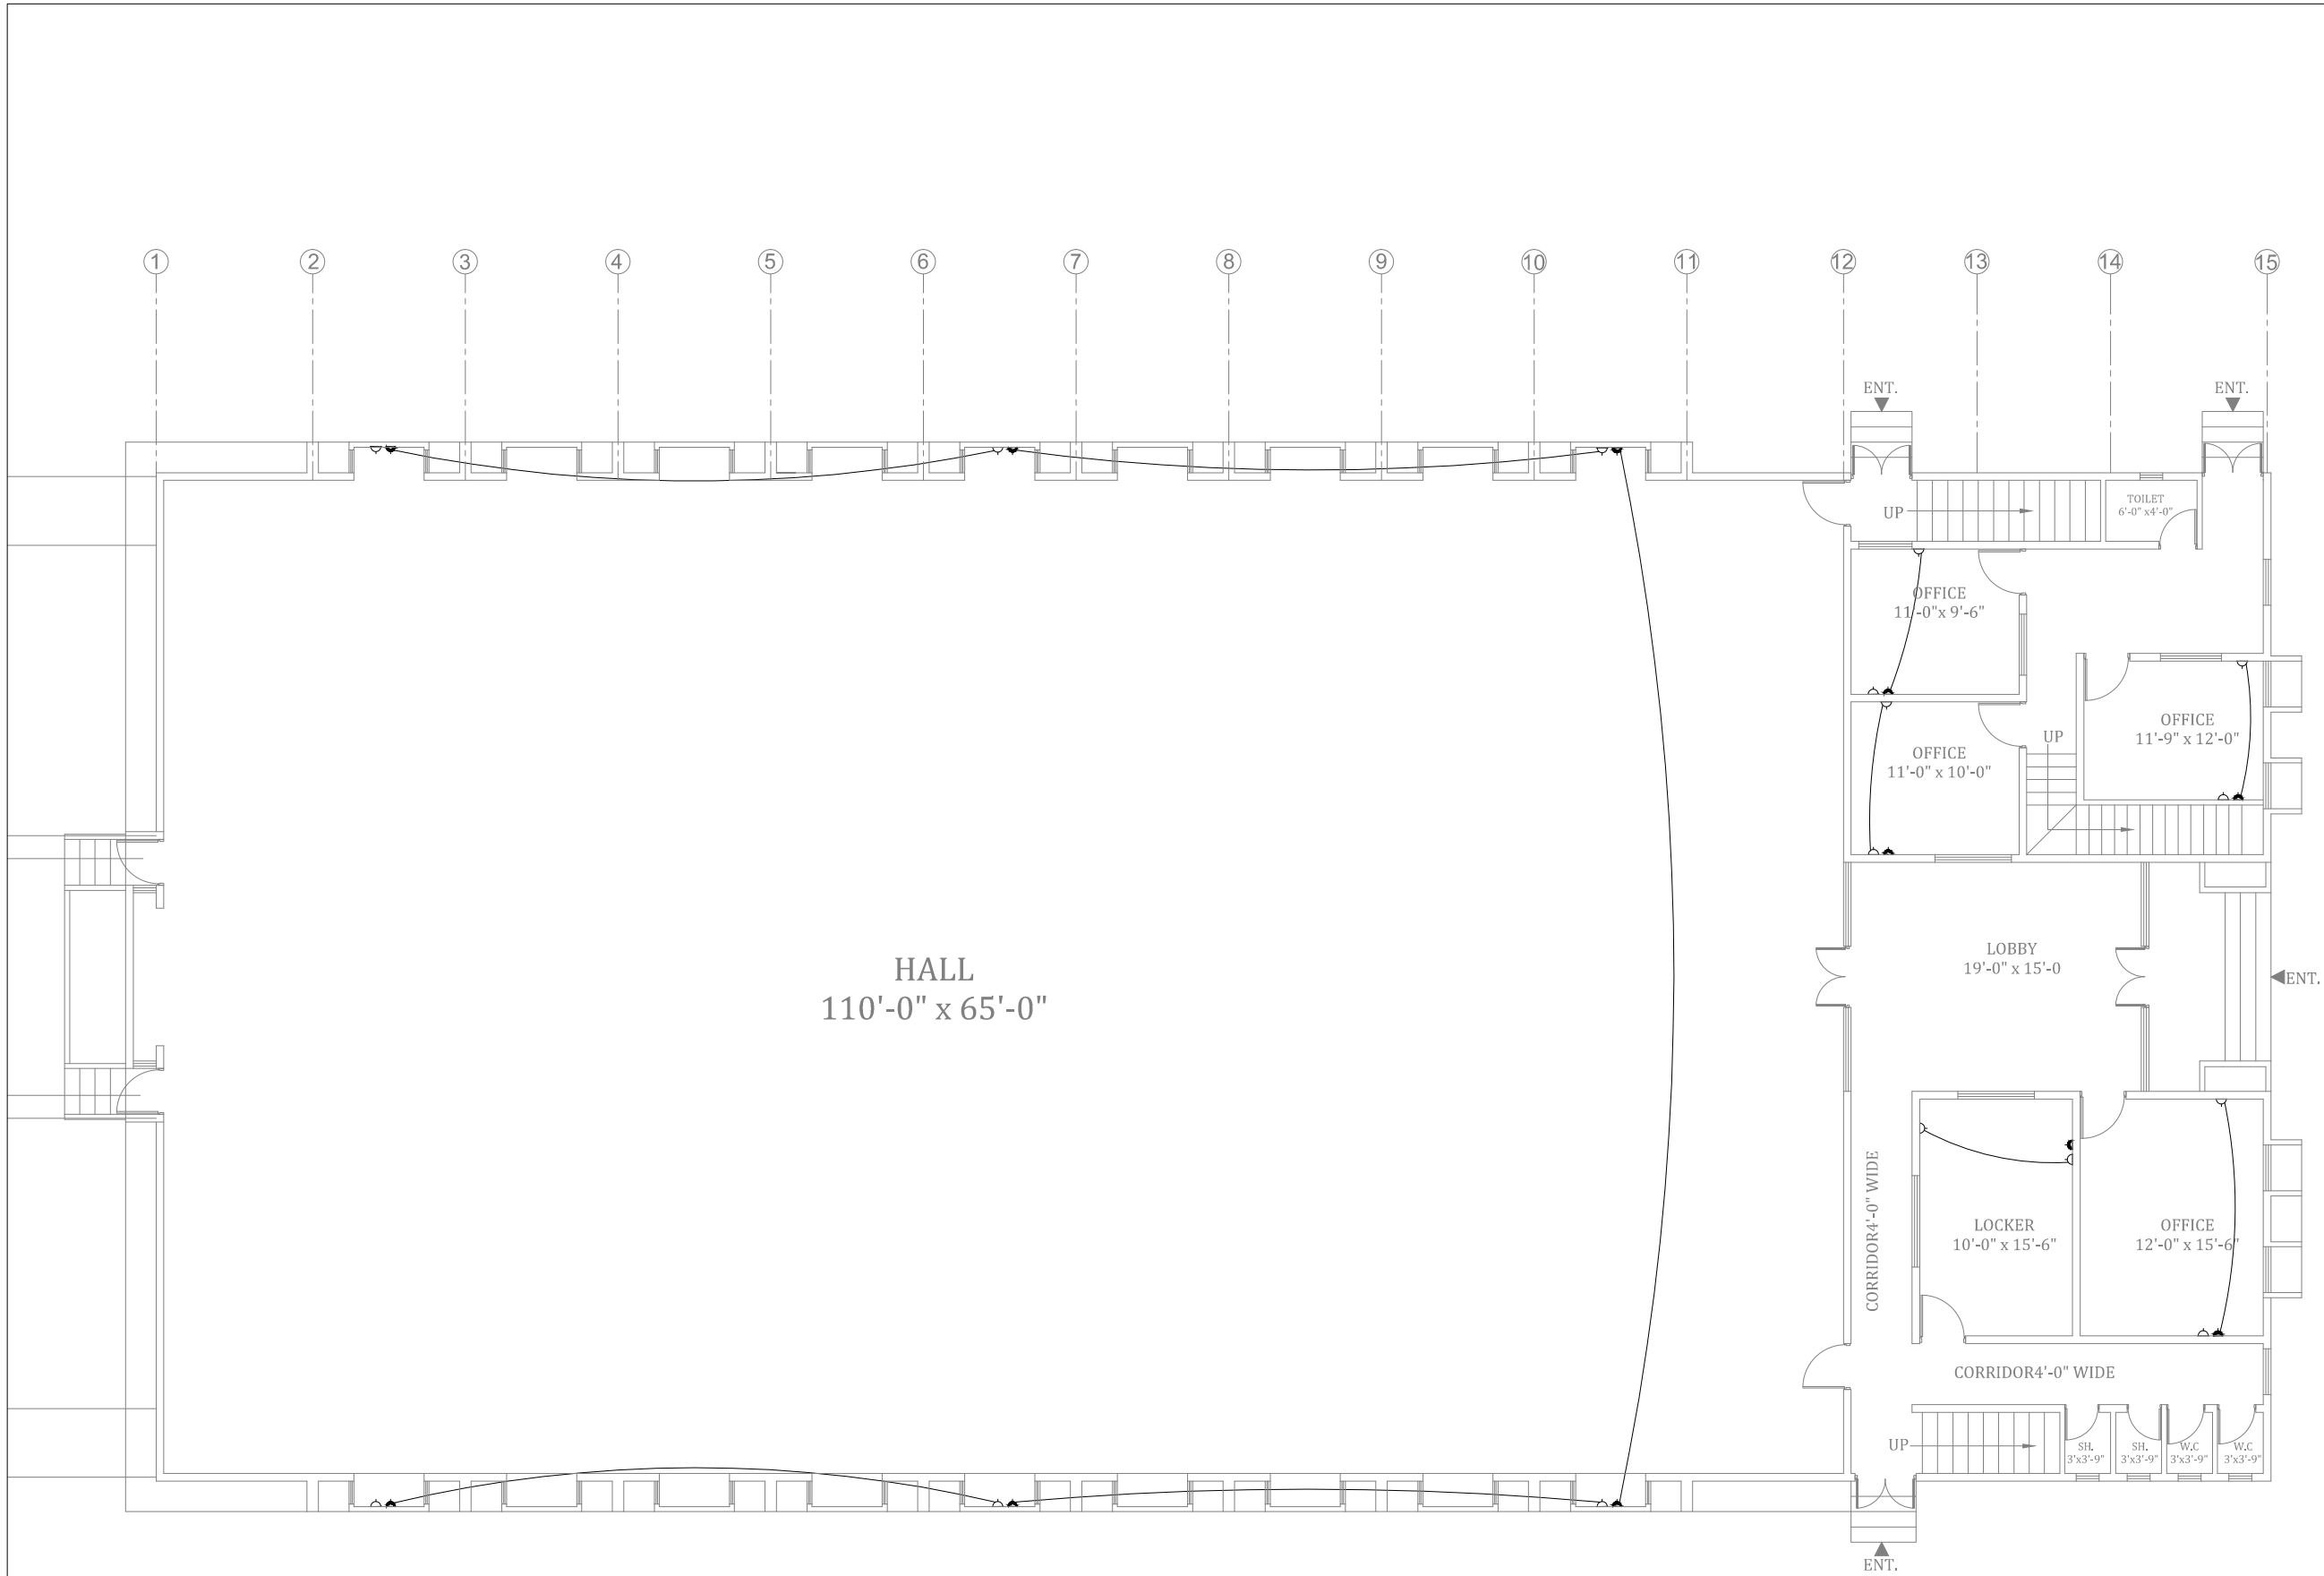

GROUND FLOOR PLAN

CLIENT:

PROJECT  
IMPLEMENTATION  
UNIT (PIU) KNIP



CONSULTANTS:  
G3 ENGINEERING  
CONSULTANTS (PVT) LTD.  
House No.57-M Gulberg-III, Lahore, Pakistan  
Tel : (92-42) 35441641, 35441642  
Fax : (92-42) 35441645  
E-mail : info@g3ec.com  
URL : www.g3ec.com

PROJECT:  
Karachi Neighbourhood  
Improvement Project (KNIP)

SUB PROJECT:  
Redevelopment of Kakri Sports  
Complex and Neighborhood  
Improvement



NOTES:  
1. ALL DIMENSIONS ARE IN FEET UNLESS  
OTHERWISE SPECIFIED.  
2. THIS DRAWING IS AN INTELLECTUAL PROPERTY  
OF G3 ENGINEERING CONSULTANTS (PVT.) LTD.  
AND CANNOT BE REPRINTED OR REPRODUCED  
WITHOUT PRIOR APPROVAL OF G3.

REVISIONS:		
No.	DESCRIPTION	DATE

TENDER DRAWINGS


DRAWING TITLE: EXISTING GYMNASIUM POWER DISTRIBUTION LAYOUT	
DRAWN BY: M.Raffeh	DATE: SEP 2021
CHECKED BY: Eng.Ghulam Daraz Shaikh	
Approved BY: Syed Ali Abbas Gillani	
DRAWING NO: 0249/EMPH/018	REV: 0
SCALE (A3): N.T.S	SHEET: 00/00



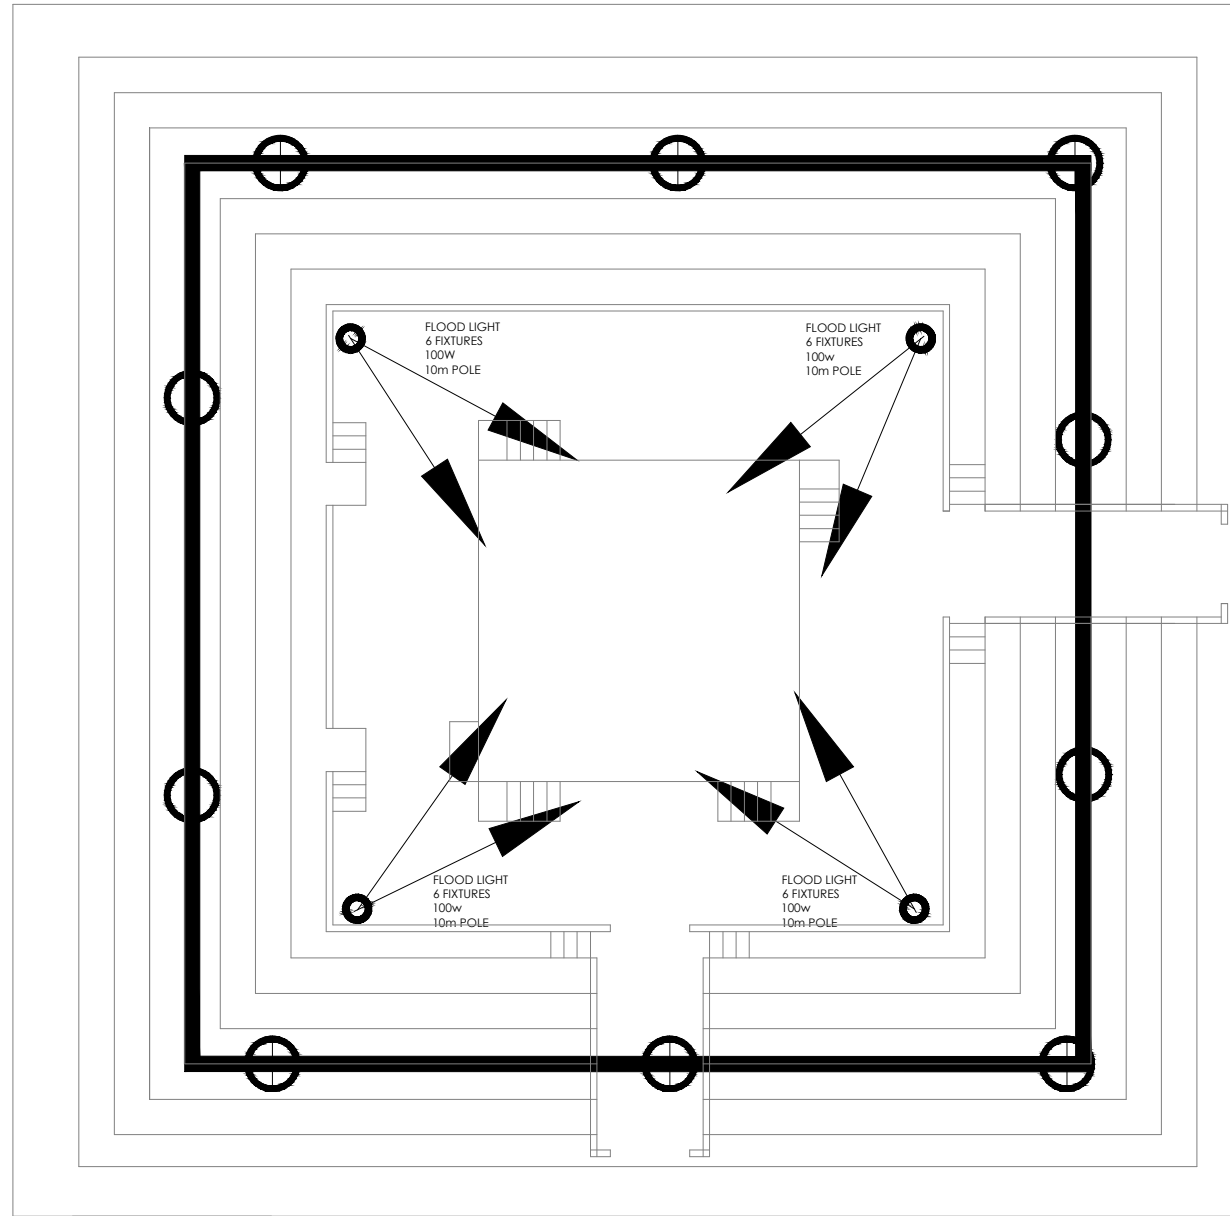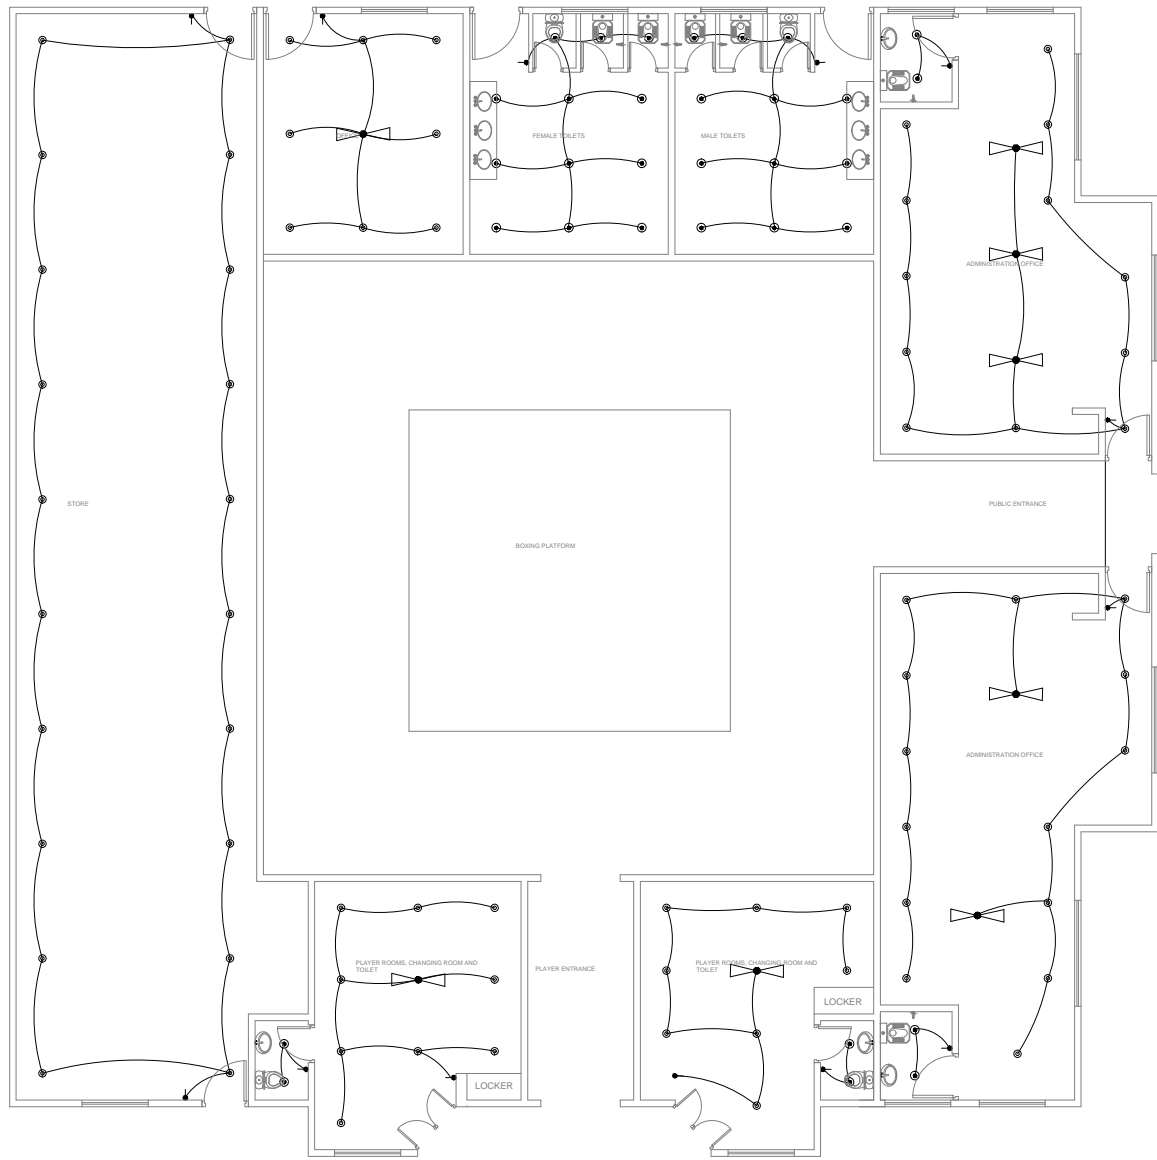

CLIENT:

 **PROJECT  
IMPLEMENTATION  
UNIT (PIU) KNIP**



CONSULTANTS:

G3 ENGINEERING  
CONSULTANTS (PVT) LTD.  
House No.57-M Gulberg-III, Lahore, Pakistan

Tel : (92-42) 35441641, 35441642  
Fax : (92-42) 35441645  
E-mail : info@g3ec.com  
URL : www.g3ec.com

PROJECT:

**Karachi Neighbourhood  
Improvement Project (KNIP)**

SUB PROJECT:

**Redevelopment of Kakri Sports  
Complex and Neighborhood  
Improvement**

NOTES:

1. ALL DIMENSIONS ARE IN FEET UNLESS OTHERWISE SPECIFIED.
2. THIS DRAWING IS AN INTELLECTUAL PROPERTY OF G3 ENGINEERING CONSULTANTS (PVT.) LTD. AND CANNOT BE REPRINTED OR REPRODUCED WITHOUT PRIOR APPROVAL OF G3.


REVISIONS:

No.	DESCRIPTION	DATE

**TENDER DRAWINGS**

DRAWING TITLE:  
**BOXING ARENA  
ILLUMINATION  
LAYOUT**

DRAWN BY: <b>M.Raffeh</b>	DATE: <b>SEP 2021</b>
CHECKED BY: <b>Eng.Ghulam Daraz Shaikh</b>	
Approved BY: <b>Syed Ali Abbas Gillani</b>	
DRAWING NO: <b>0249/BA/019</b>	REV: <b>0</b>
SCALE (A3): <b>N.T.S</b>	SHEET: <b>00/00</b>

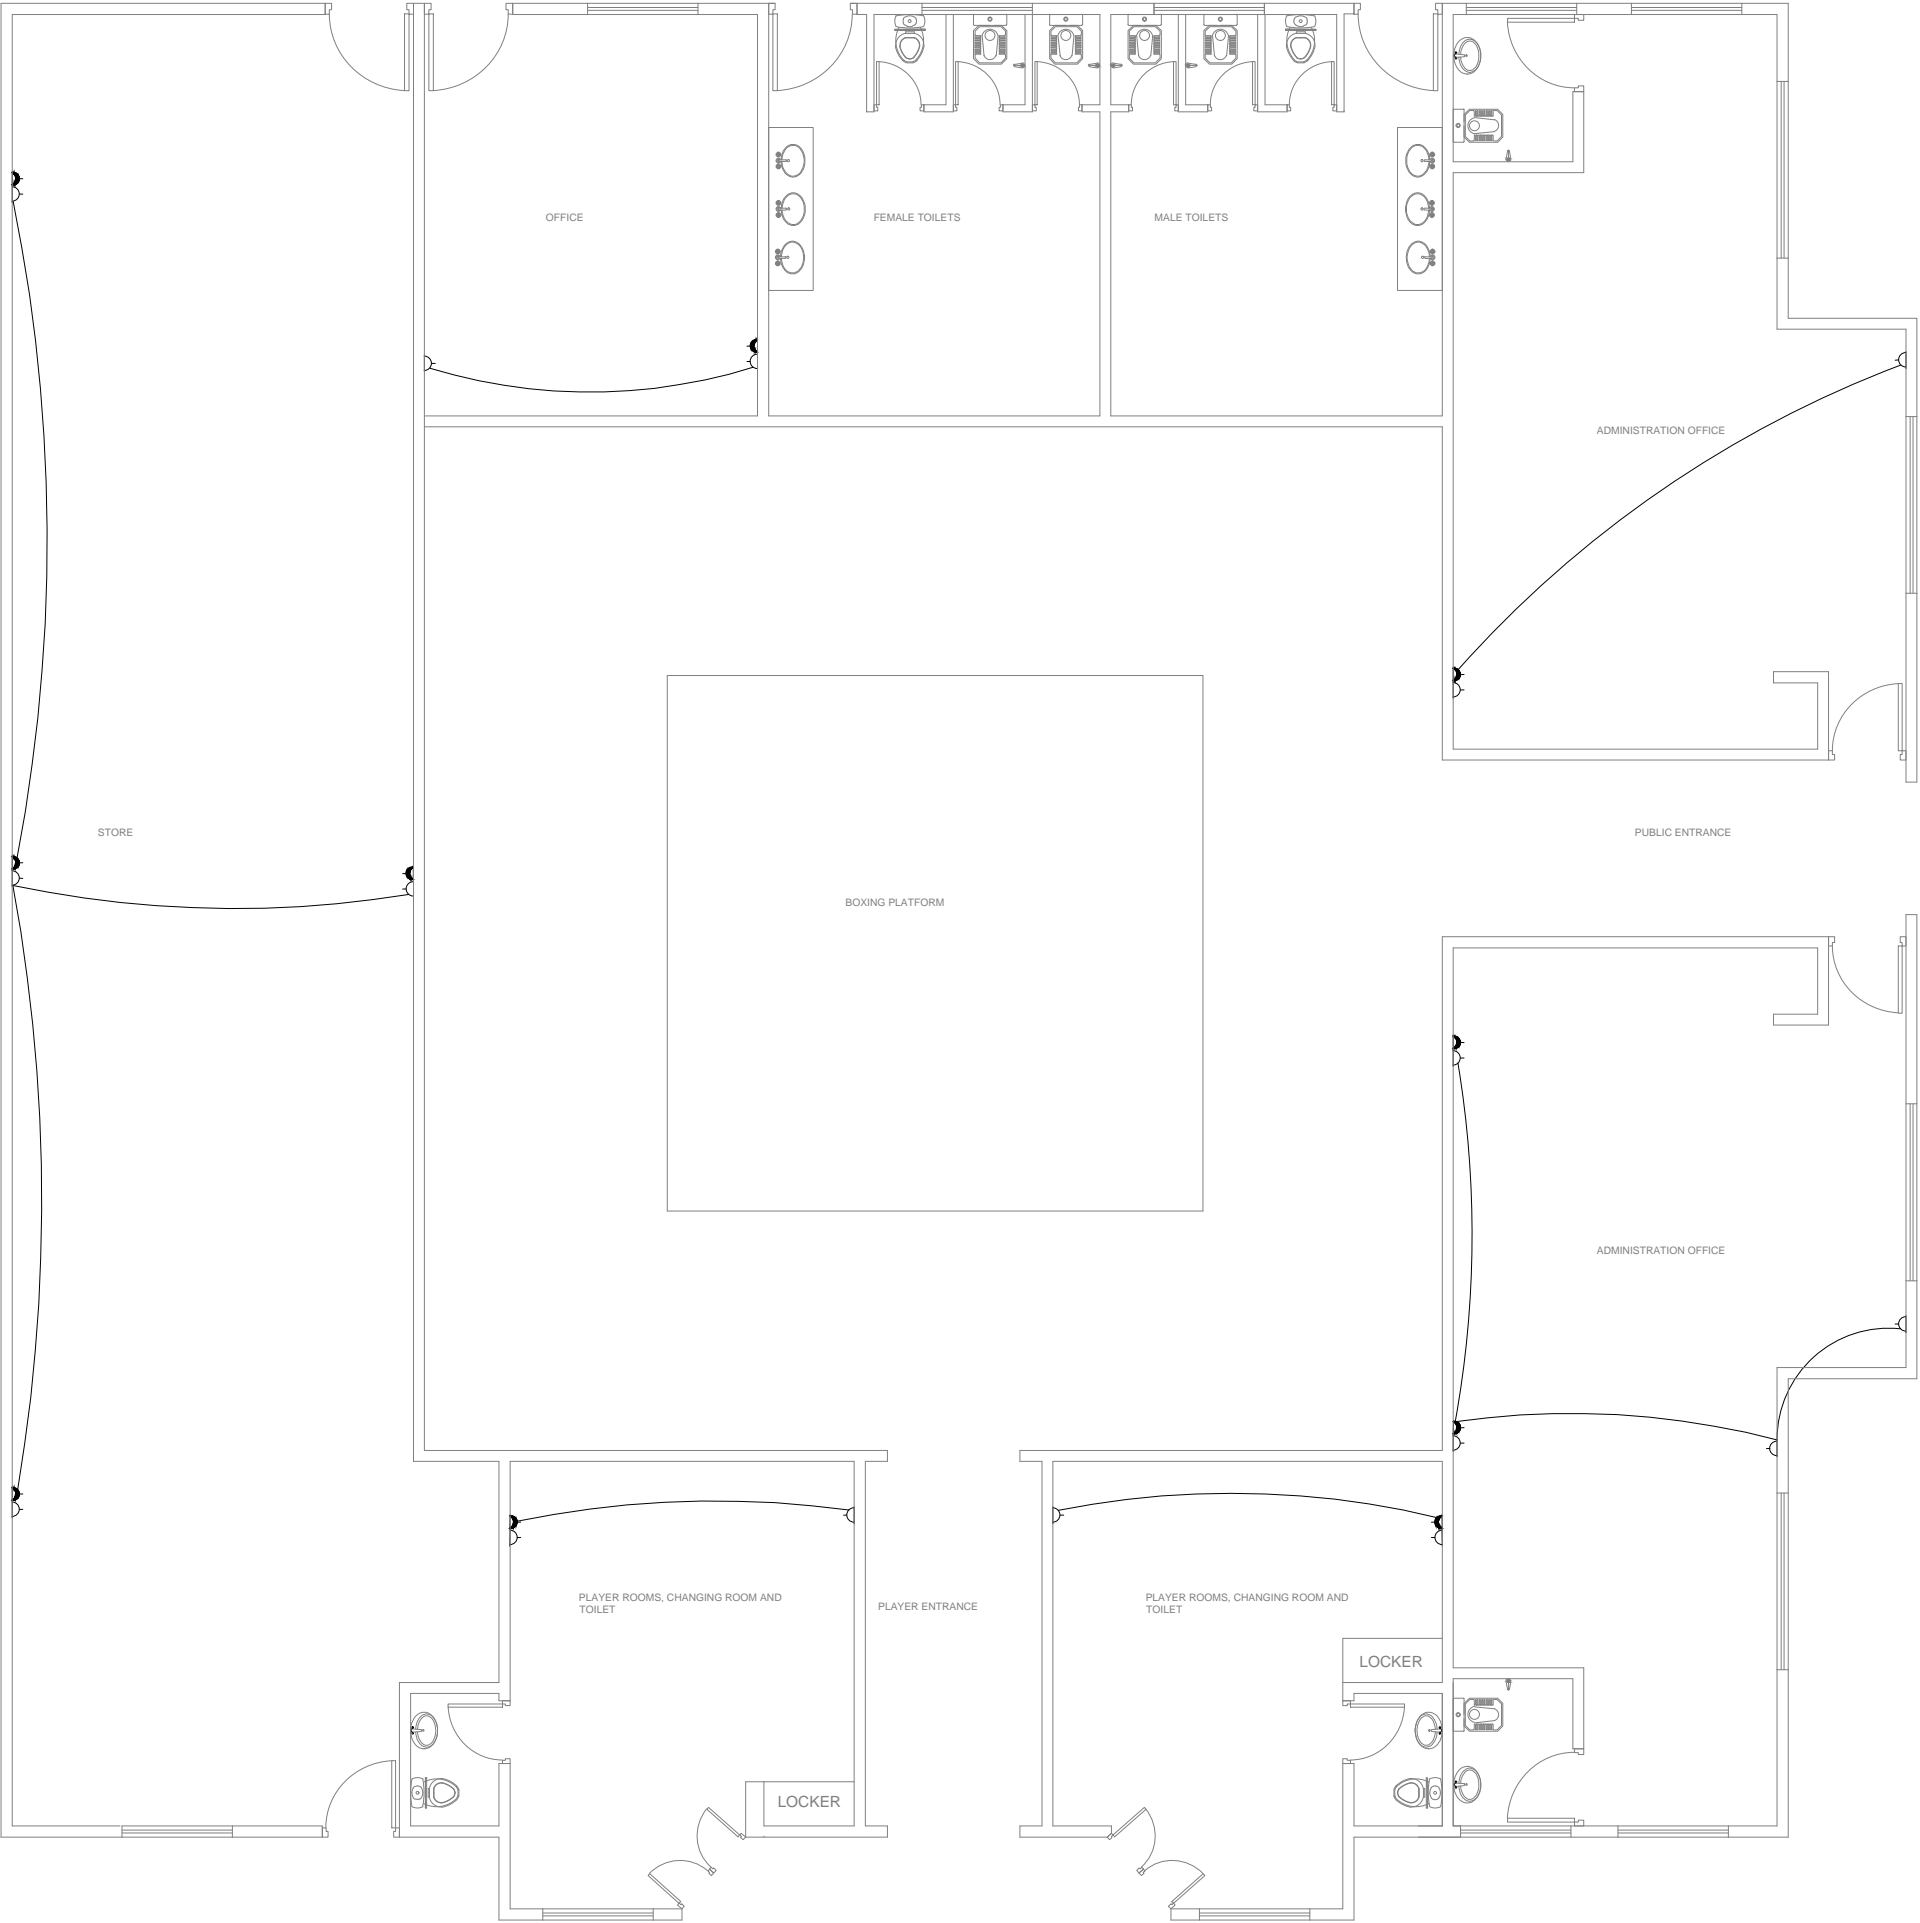

CLIENT:

 **PROJECT  
IMPLEMENTATION  
UNIT (PIU) KNIP**



CONSULTANTS:

G3 ENGINEERING  
CONSULTANTS (PVT)LTD.  
House No.57-M Gulberg-III, Lahore, Pakistan



Tel : (92-42) 35441641, 35441642  
Fax : (92-42) 35441645  
E-mail : info@g3ec.com  
URL : www.g3ec.com

PROJECT:

**Karachi Neighbouhood  
Improvement Project (KNIP)**

SUB PROJECT:

**Redevelopment of Kakri Sports  
Complex and Neighborhood  
Improvement**

NOTES:

1. ALL DIMENSIONS ARE IN FEET UNLESS OTHERWISE SPECIFIED.
2. THIS DRAWING IS AN INTELLECTUAL PROPERTY OF G3 ENGINEERING CONSULTANTS (PVT.) LTD. AND CANNOT BE REPRINTED OR REPRODUCED WITHOUT PRIOR APPROVAL OF G3.

REVISIONS:

No.	DESCRIPTION	DATE

**TENDER DRAWINGS**

DRAWING TITLE:  
**BOXING ARENA  
POWER DISTRIBUTION  
LAYOUT**



DRAWN BY: <b>M.Raffeh</b>	DATE: <b>SEP 2021</b>
------------------------------	--------------------------

CHECKED BY: <b>Eng.Ghulam Daraz Shaikh</b>	
---	---

Approved BY: <b>Syed Ali Abbas Gillani</b>	
---	---

DRAWING NO: <b>0249/BA/020</b>	REV: <b>0</b>
-----------------------------------	------------------

SCALE (A3): <b>N.T.S</b>	SHEET: <b>00/00</b>
-----------------------------	------------------------

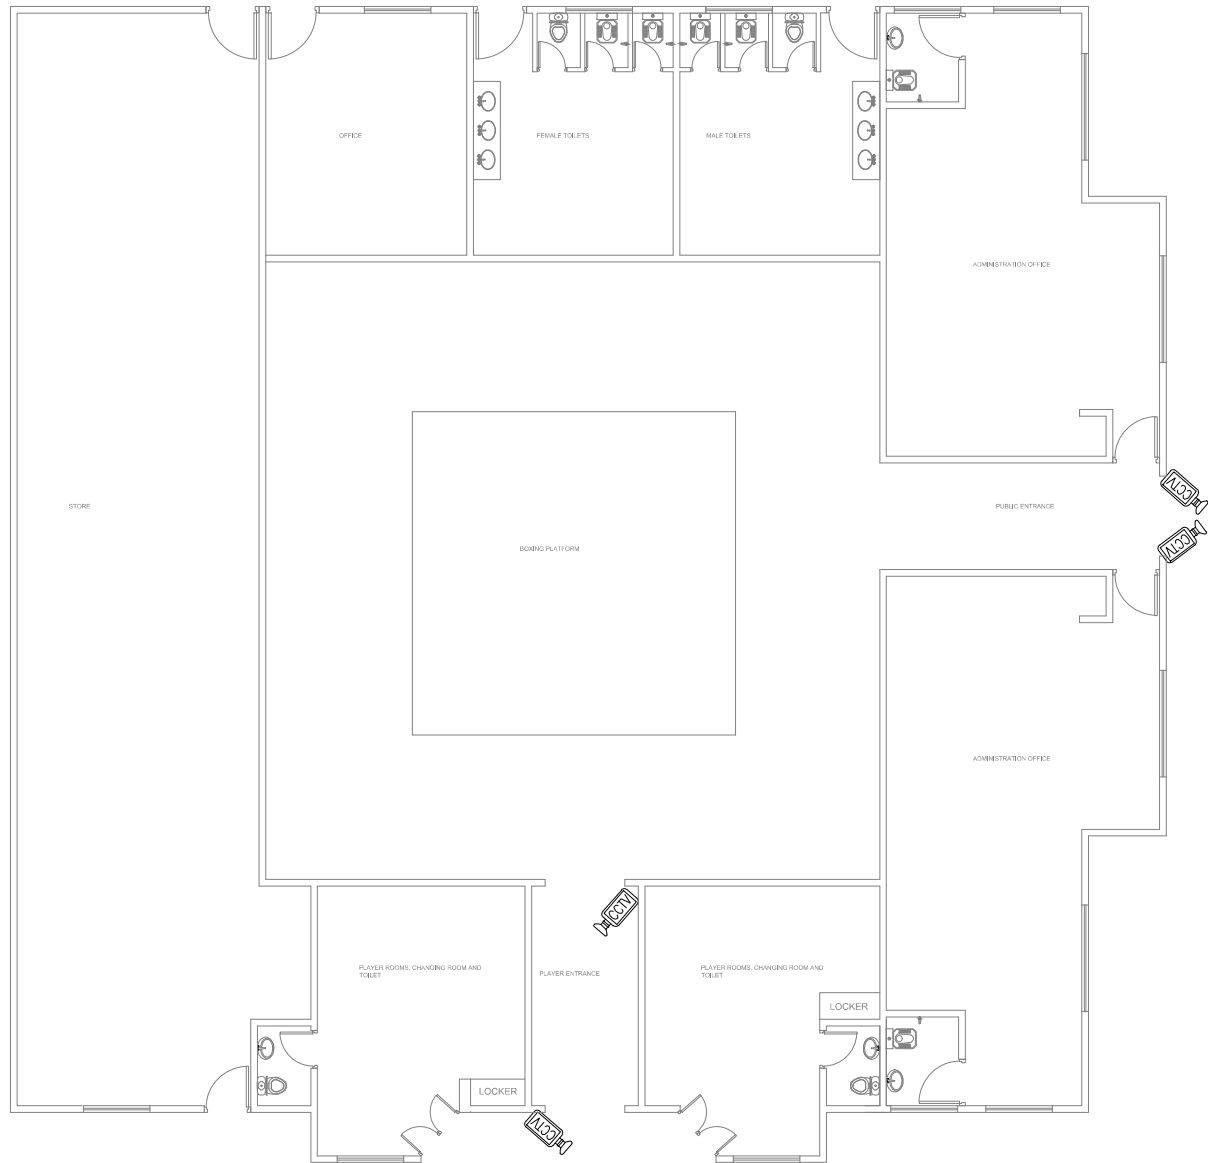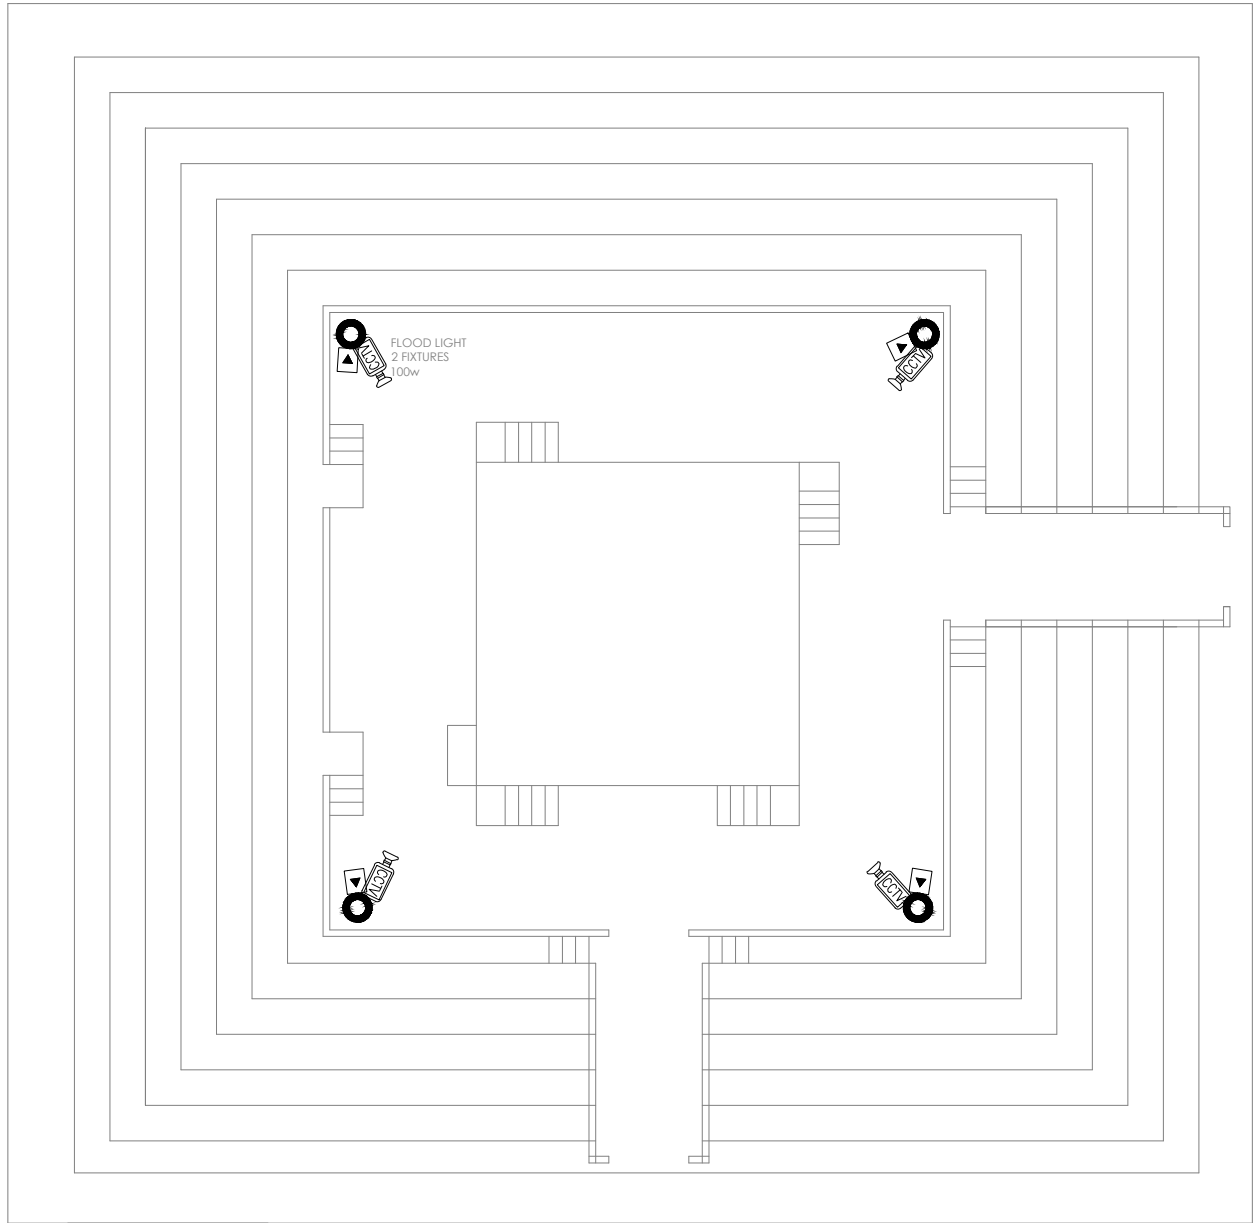

CLIENT:

**PROJECT  
IMPLEMENTATION  
UNIT (PIU) KNIP**



CONSULTANTS:

G3 ENGINEERING  
CONSULTANTS (PVT) LTD.  
House No.57-M Gulberg-III, Lahore, Pakistan



Tel : (92-42) 35441641, 35441642  
Fax : (92-42) 35441645  
E-mail : info@g3ec.com  
URL : www.g3ec.com

PROJECT:

**Karachi Neighbourhood  
Improvement Project (KNIP)**

SUB PROJECT:

**Redevelopment of Kakri Sports  
Complex and Neighborhood  
Improvement**

NOTES:

1. ALL DIMENSIONS ARE IN FEET UNLESS OTHERWISE SPECIFIED.
2. THIS DRAWING IS AN INTELLECTUAL PROPERTY OF G3 ENGINEERING CONSULTANTS (PVT.) LTD. AND CANNOT BE REPRINTED OR REPRODUCED WITHOUT PRIOR APPROVAL OF G3.


REVISIONS:

No.	DESCRIPTION	DATE

**TENDER DRAWINGS**

DRAWING TITLE:  
**BOXING ARENA  
PUBLIC ADDRESS SYSTEM  
& CCTV LAYOUT**

DRAWN BY: <b>M.Raffeh</b>	DATE: <b>SEP 2021</b>
CHECKED BY: <b>Eng.Ghulam Daraz Shaikh</b>	
Approved BY: <b>Syed Ali Abbas Gillani</b>	
DRAWING NO: <b>0249/BA/021</b>	REV: <b>0</b>
SCALE (A3): <b>N.T.S</b>	SHEET: <b>00/00</b>

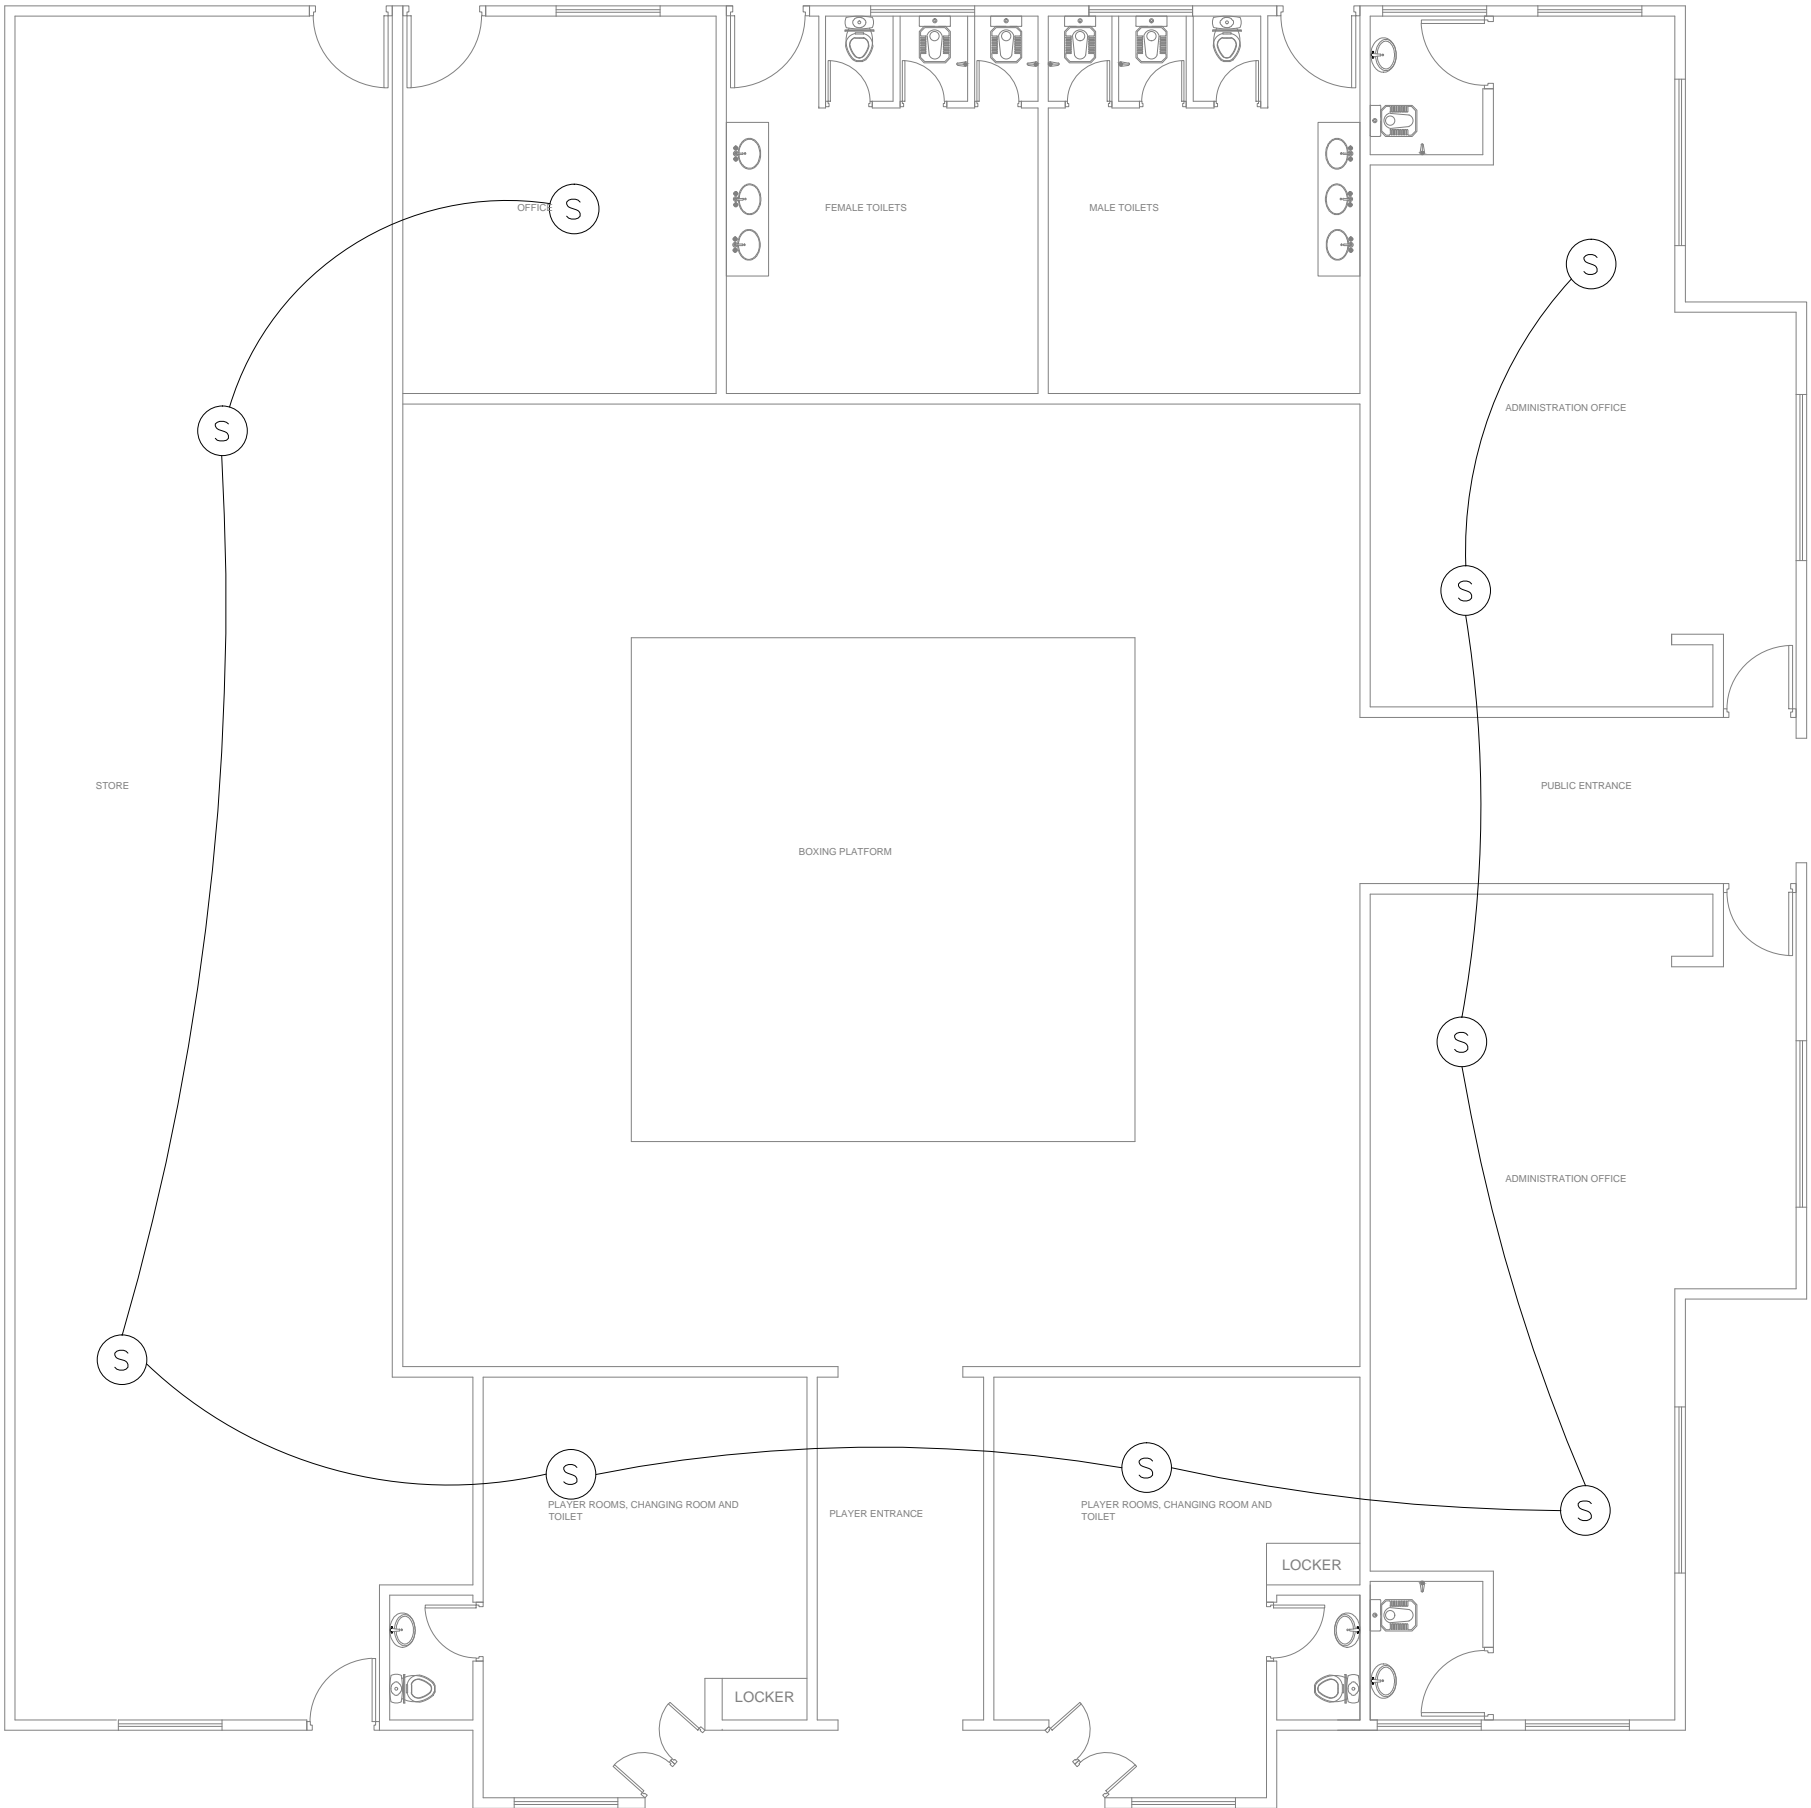

CLIENT:

 PROJECT  
IMPLEMENTATION  
UNIT (PIU) KNIP



CONSULTANTS:  
  
G3 ENGINEERING  
CONSULTANTS (PVT)LTD.  
House No.57-M Gulberg-III, Lahore, Pakistan  
  
Tel : (92-42) 35441641, 35441642  
Fax : (92-42) 35441645  
E-mail : info@g3ec.com  
URL : www.g3ec.com

PROJECT:  
  
**Karachi Neighbourhood  
Improvement Project (KNIP)**

SUB PROJECT:  
  
**Redevelopment of Kakri Sports  
Complex and Neighborhood  
Improvement**

NOTES:  
1. ALL DIMENSIONS ARE IN FEET UNLESS  
OTHERWISE SPECIFIED.  
2. THIS DRAWING IS AN INTELLECTUAL PROPERTY  
OF G3 ENGINEERING CONSULTANTS (PVT.) LTD.  
AND CANNOT BE REPRINTED OR REPRODUCED  
WITHOUT PRIOR APPROVAL OF G3.

REVISIONS:		
No.	DESCRIPTION	DATE

TENDER DRAWINGS

DRAWING TITLE:	
BOXING ARENA FIRE ALARM SYSTEM	
DRAWN BY: M.Raffeh	DATE: SEP 2021
CHECKED BY: Eng.Ghulam Daraz Shaikh	
Approved BY: Syed Ali Abbas Gillani	
DRAWING NO: 0249/BA/022	REV: 0
SCALE (A3): N.T.S	SHEET: 00/00



CLIENT:

PROJECT  
IMPLEMENTATION  
UNIT (PIU) KNIP

CONSULTANTS:  
G3 ENGINEERING  
CONSULTANTS (PVT) LTD.  
House No.57-M Gulberg-III, Lahore, Pakistan  
Tel : (92-42) 35441641, 35441642  
Fax : (92-42) 35441645  
E-mail : info@g3ec.com  
URL : www.g3ec.com

PROJECT:  
Karachi Neighbourhood  
Improvement Project (KNIP)

SUB PROJECT:  
Redevelopment of Kakri Sports  
Complex and Neighborhood  
Improvement


NOTES:  
1. ALL DIMENSIONS ARE IN FEET UNLESS  
OTHERWISE SPECIFIED.  
2. THIS DRAWING IS AN INTELLECTUAL PROPERTY  
OF G3 ENGINEERING CONSULTANTS (PVT.) LTD.  
AND CANNOT BE REPRINTED OR REPRODUCED  
WITHOUT PRIOR APPROVAL OF G3.


REVISIONS:		
No.	DESCRIPTION	DATE

TENDER DRAWINGS

DRAWING TITLE:  
STADIA  
ILLUMINATION LAYOUT

DRAWN BY: M.Raffeh	DATE: SEP 2021
CHECKED BY: Eng.Ghulam Daraz Shaikh	
Approved BY: Syed Ali Abbas Gillani	
DRAWING NO: 0249/ST/023	REV: 0
SCALE (A3): N.T.S	SHEET: 00/00

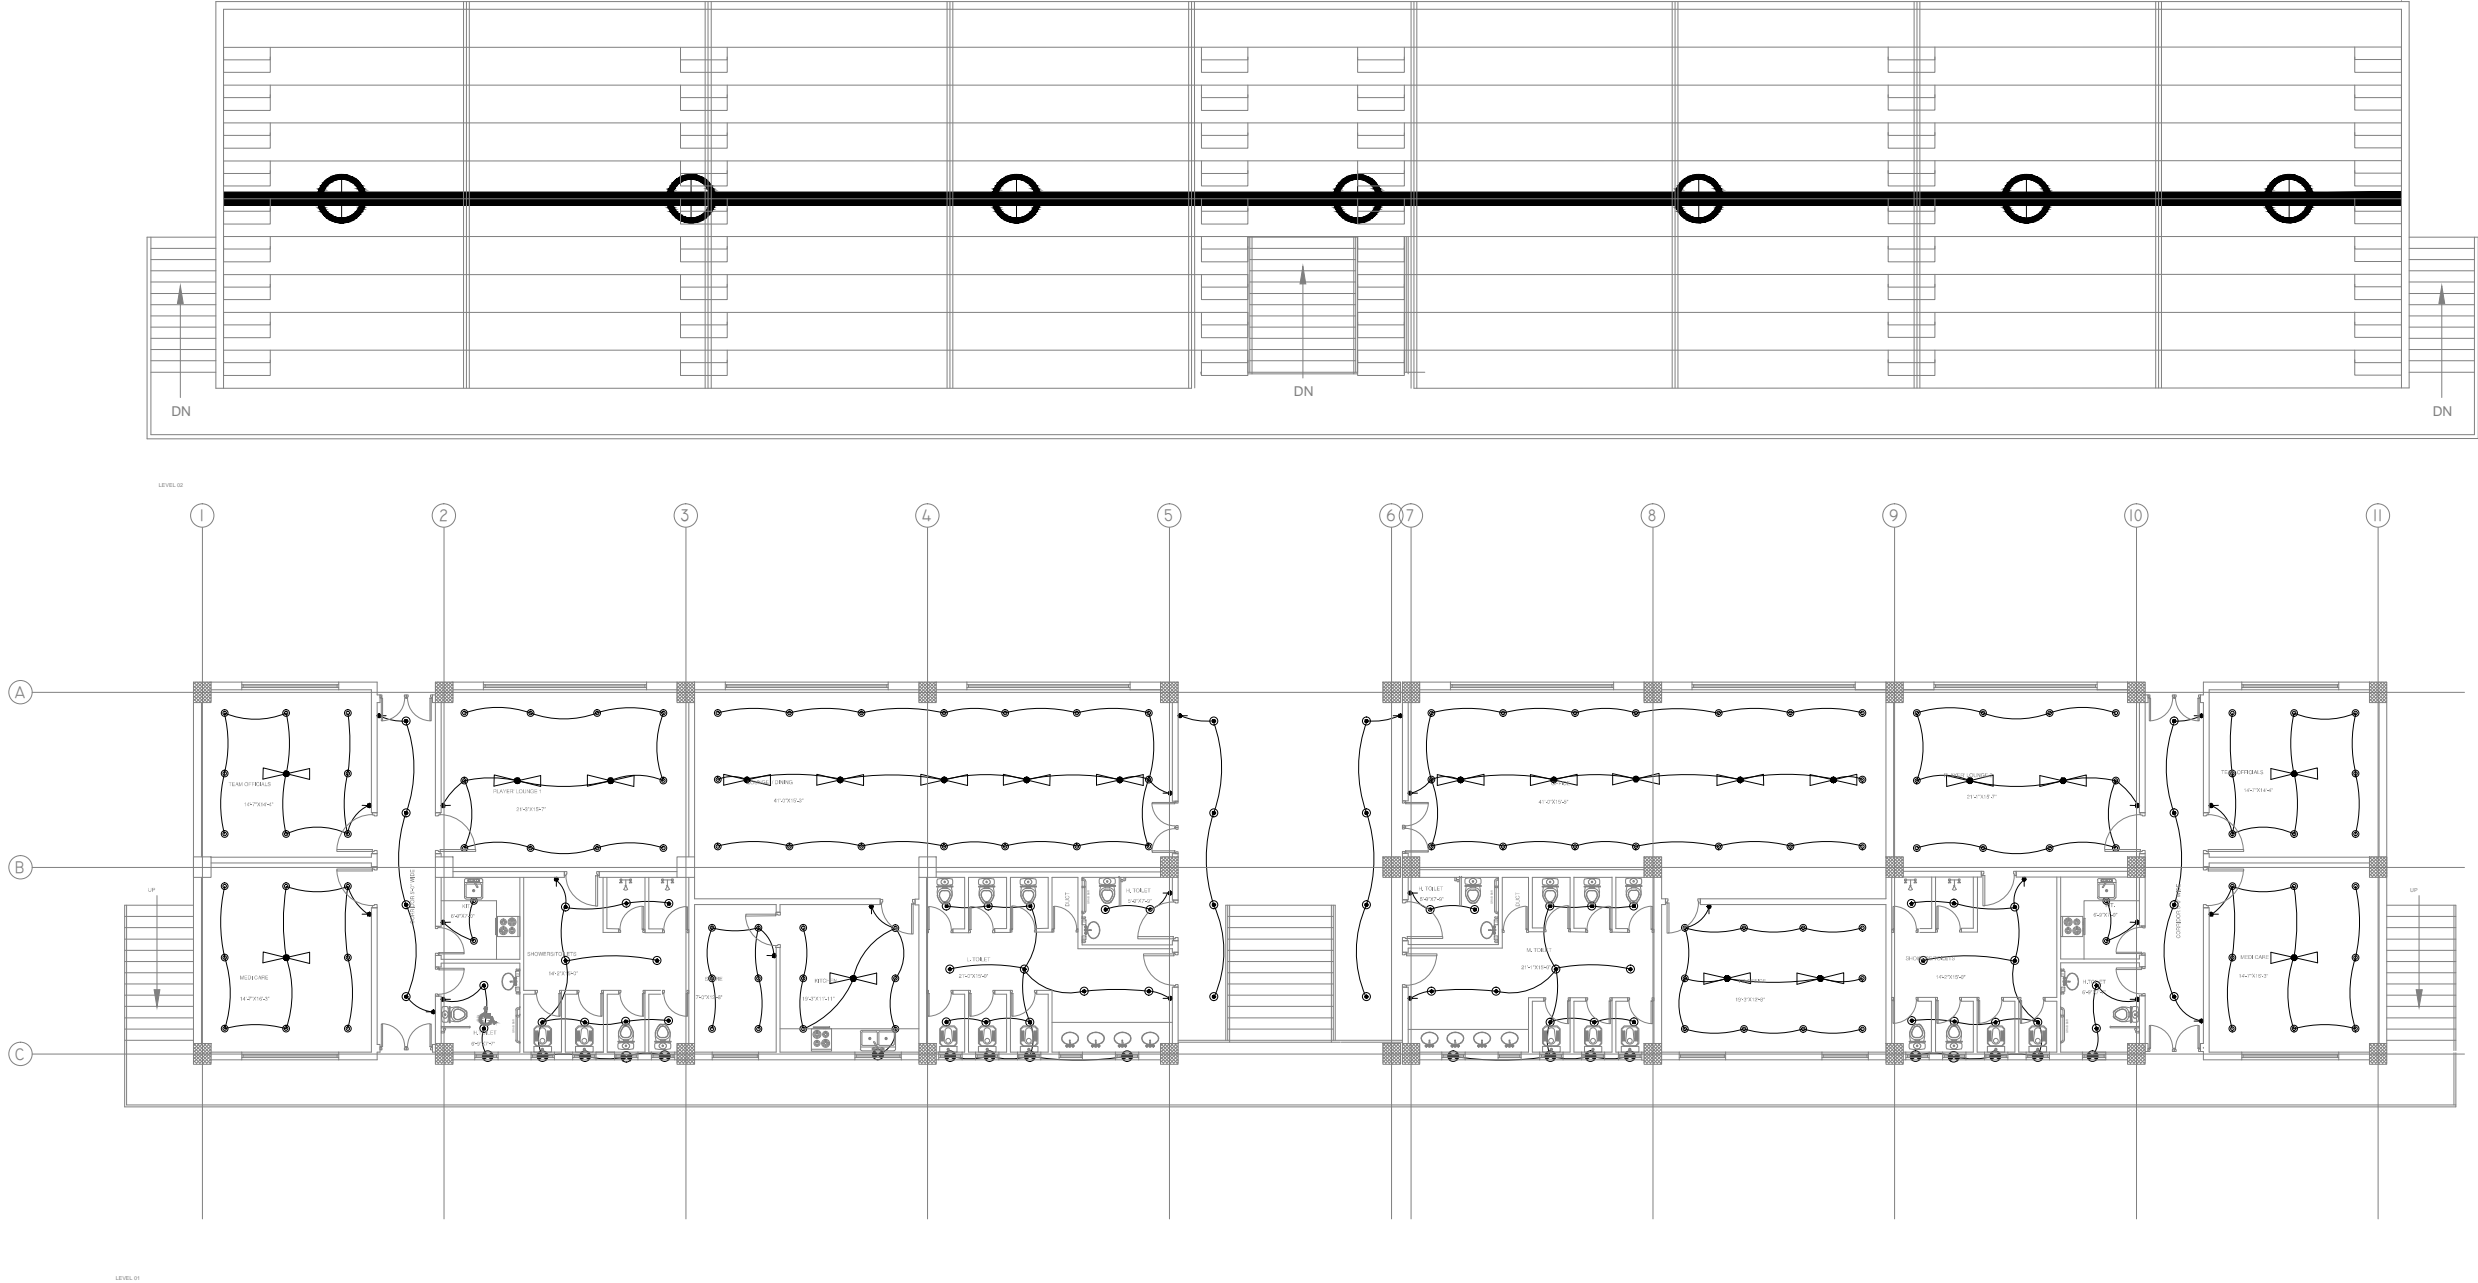



PROJECT  
IMPLEMENTATION  
UNIT (PIU) KNIP



**G3 ENGINEERING  
CONSULTANTS (PVT)LTD.**  
House No.57-M Gulberg-III, Lahore, Pakistan

Tel : (92-42) 35441641, 35441642  
Fax : (92-42) 35441645  
E-mail : [info@g3ec.com](mailto:info@g3ec.com)  
URL : [www.g3ec.com](http://www.g3ec.com)

## Karachi Neighbourhood Improvement Project (KNIP)

### Redevelopment of Kakri Sports Complex and Neighborhood Improvement

1. ALL DIMENSIONS ARE IN FEET UNLESS OTHERWISE SPECIFIED.
2. THIS DRAWING IS AN INTELLECTUAL PROPERTY OF G3 ENGINEERING CONSULTANTS (PVT.) LTD. AND CANNOT BE REPRINTED OR REPRODUCED WITHOUT PRIOR APPROVAL OF G3.

[illegible]


DRAWING TITLE:  
STADIA  
POWERDISTRIBUTION  
SYSTEM


CHECKED BY:  
Eng.Ghulam Daraz Shaikh

Approved BY:  
Syed Ali Abbas Gillani

DRAWING NO: 0249/ST/024	REV: 0
----------------------------	-----------

SCALE (A3): N.T.S	SHEET: 00/00
----------------------	-----------------

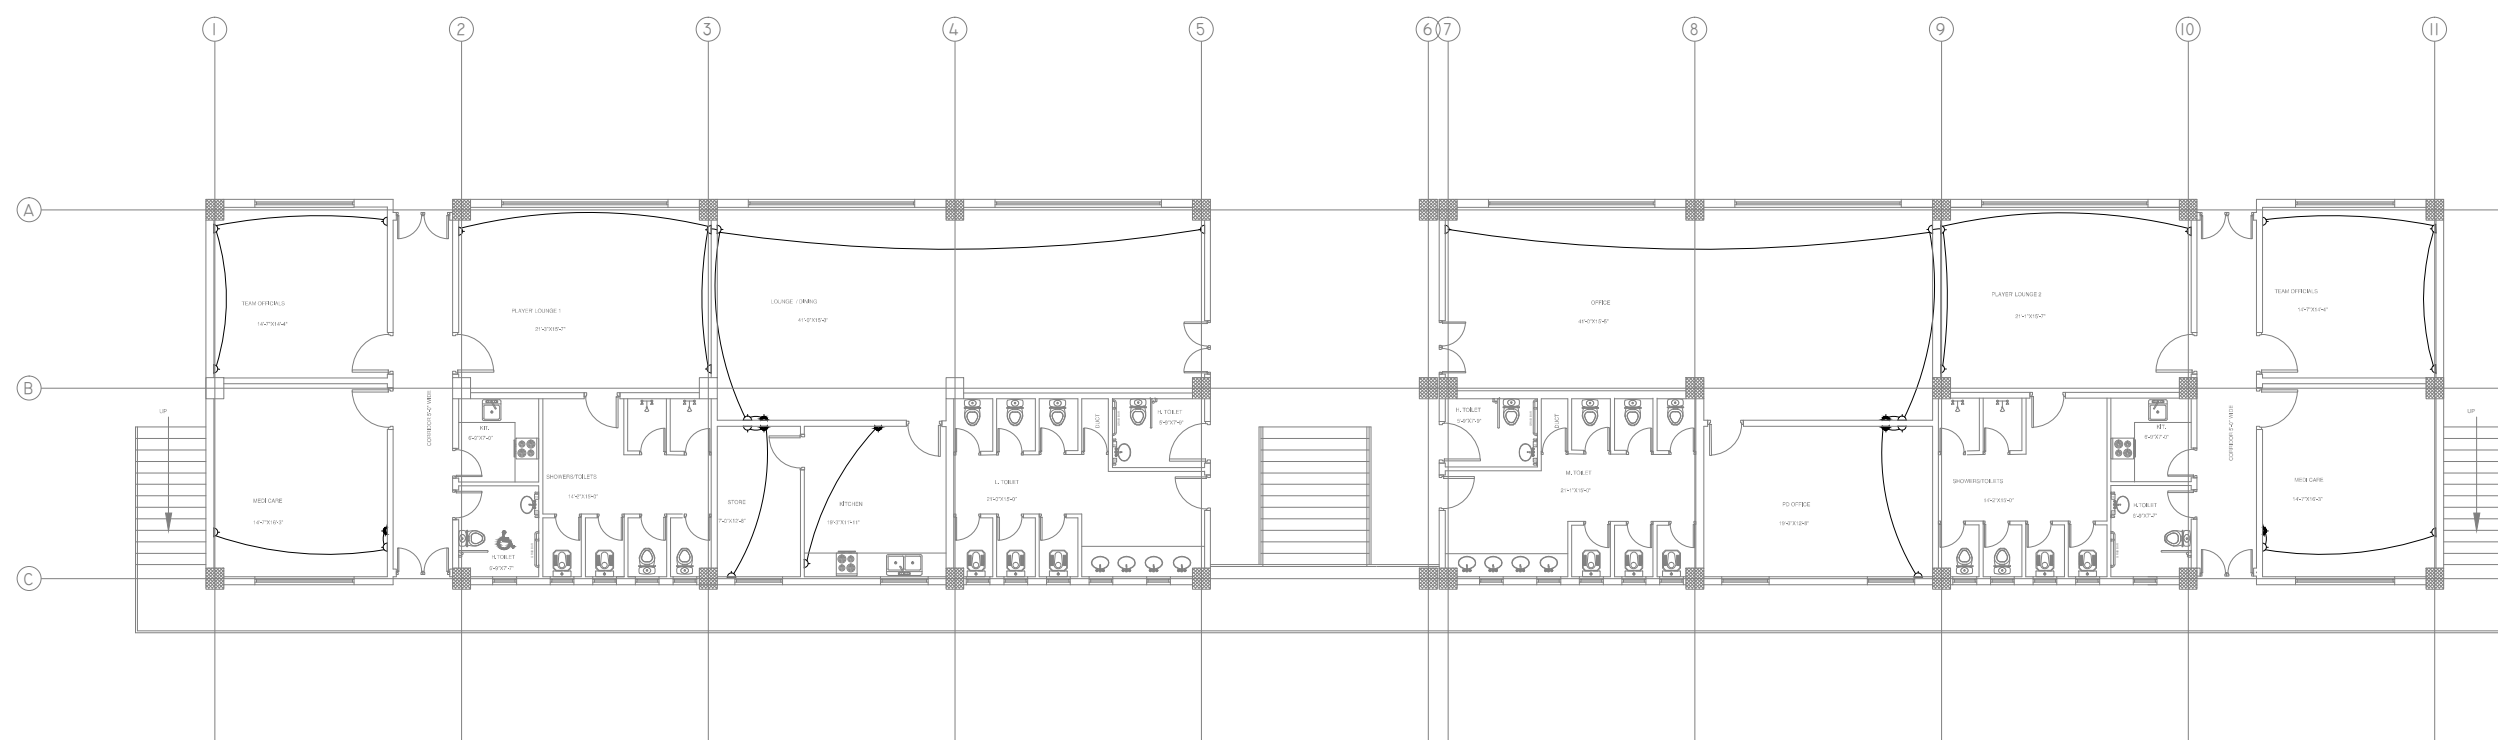

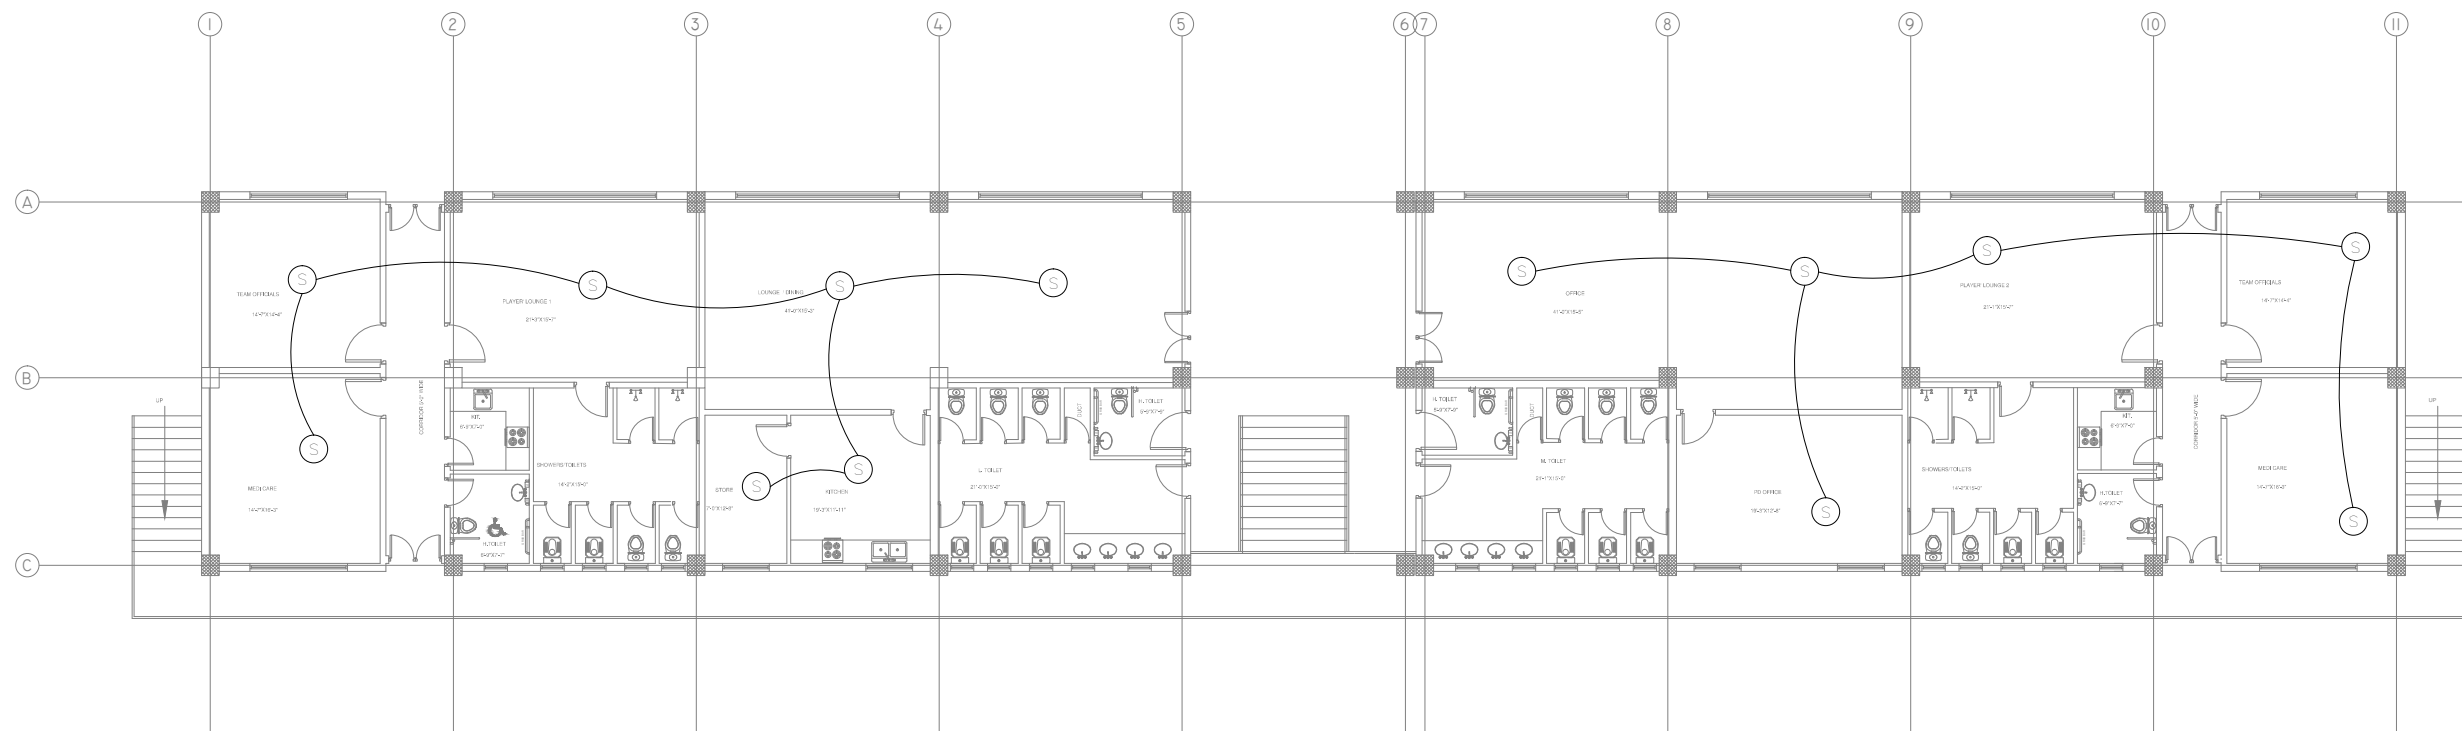

CLIENT:



**PROJECT  
IMPLEMENTATION  
UNIT (PIU) KNIP**



CONSULTANTS:

**G3 ENGINEERING  
CONSULTANTS (PVT) LTD.**  
House No.57-M Gulberg-III, Lahore, Pakistan



Tel : (92-42) 35441641, 35441642  
Fax : (92-42) 35441645  
E-mail : info@g3ec.com  
URL : www.g3ec.com

PROJECT:

**Karachi Neighbourhood  
Improvement Project (KNIP)**

SUB PROJECT:

**Redevelopment of Kakri Sports  
Complex and Neighborhood  
Improvement**

NOTES:

1. ALL DIMENSIONS ARE IN FEET UNLESS OTHERWISE SPECIFIED.
2. THIS DRAWING IS AN INTELLECTUAL PROPERTY OF G3 ENGINEERING CONSULTANTS (PVT.) LTD. AND CANNOT BE REPRINTED OR REPRODUCED WITHOUT PRIOR APPROVAL OF G3.



REVISIONS:

No.	DESCRIPTION	DATE

TENDER DRAWINGS

DRAWING TITLE:

**STADIA  
FIRE ALARM SYSTEM**

DRAWN BY: <b>M.Raffeh</b>	DATE: <b>SEP 2021</b>
CHECKED BY: <b>Eng.Ghulam Daraz Shaikh</b>	
Approved BY: <b>Syed Ali Abbas Gillani</b>	
DRAWING NO: <b>0249/ST/025</b>	REV: <b>0</b>
SCALE (A3): <b>N.T.S</b>	SHEET: <b>00/00</b>

CLIENT:

 PROJECT  
IMPLEMENTATION  
UNIT (PIU) KNIP



CONSULTANTS:

G3 ENGINEERING  
CONSULTANTS (PVT) LTD.  
House No.57-M Gulberg-III, Lahore, Pakistan



Tel : (92-42) 35441641, 35441642  
Fax : (92-42) 35441645  
E-mail : info@g3ec.com  
URL : www.g3ec.com

PROJECT:

**Karachi Neighbourhood  
Improvement Project (KNIP)**

SUB PROJECT:

**Redevelopment of Kakri Sports  
Complex and Neighborhood  
Improvement**

NOTES:

1. ALL DIMENSIONS ARE IN FEET UNLESS OTHERWISE SPECIFIED.
2. THIS DRAWING IS AN INTELLECTUAL PROPERTY OF G3 ENGINEERING CONSULTANTS (PVT.) LTD. AND CANNOT BE REPRINTED OR REPRODUCED WITHOUT PRIOR APPROVAL OF G3.



REVISIONS:


No.	DESCRIPTION	DATE

**TENDER DRAWINGS**

DRAWING TITLE:

**EXISTING STADIA  
ILLUMINATION LAYOUT**

DRAWN BY: M.Raffeh	DATE: SEP 2021
CHECKED BY: Eng.Ghulam Daraz Shaikh	
Approved BY: Syed Ali Abbas Gillani	
DRAWING NO: 0249/ST/026	REV: 0
SCALE (A3): N.T.S	SHEET: 00/00

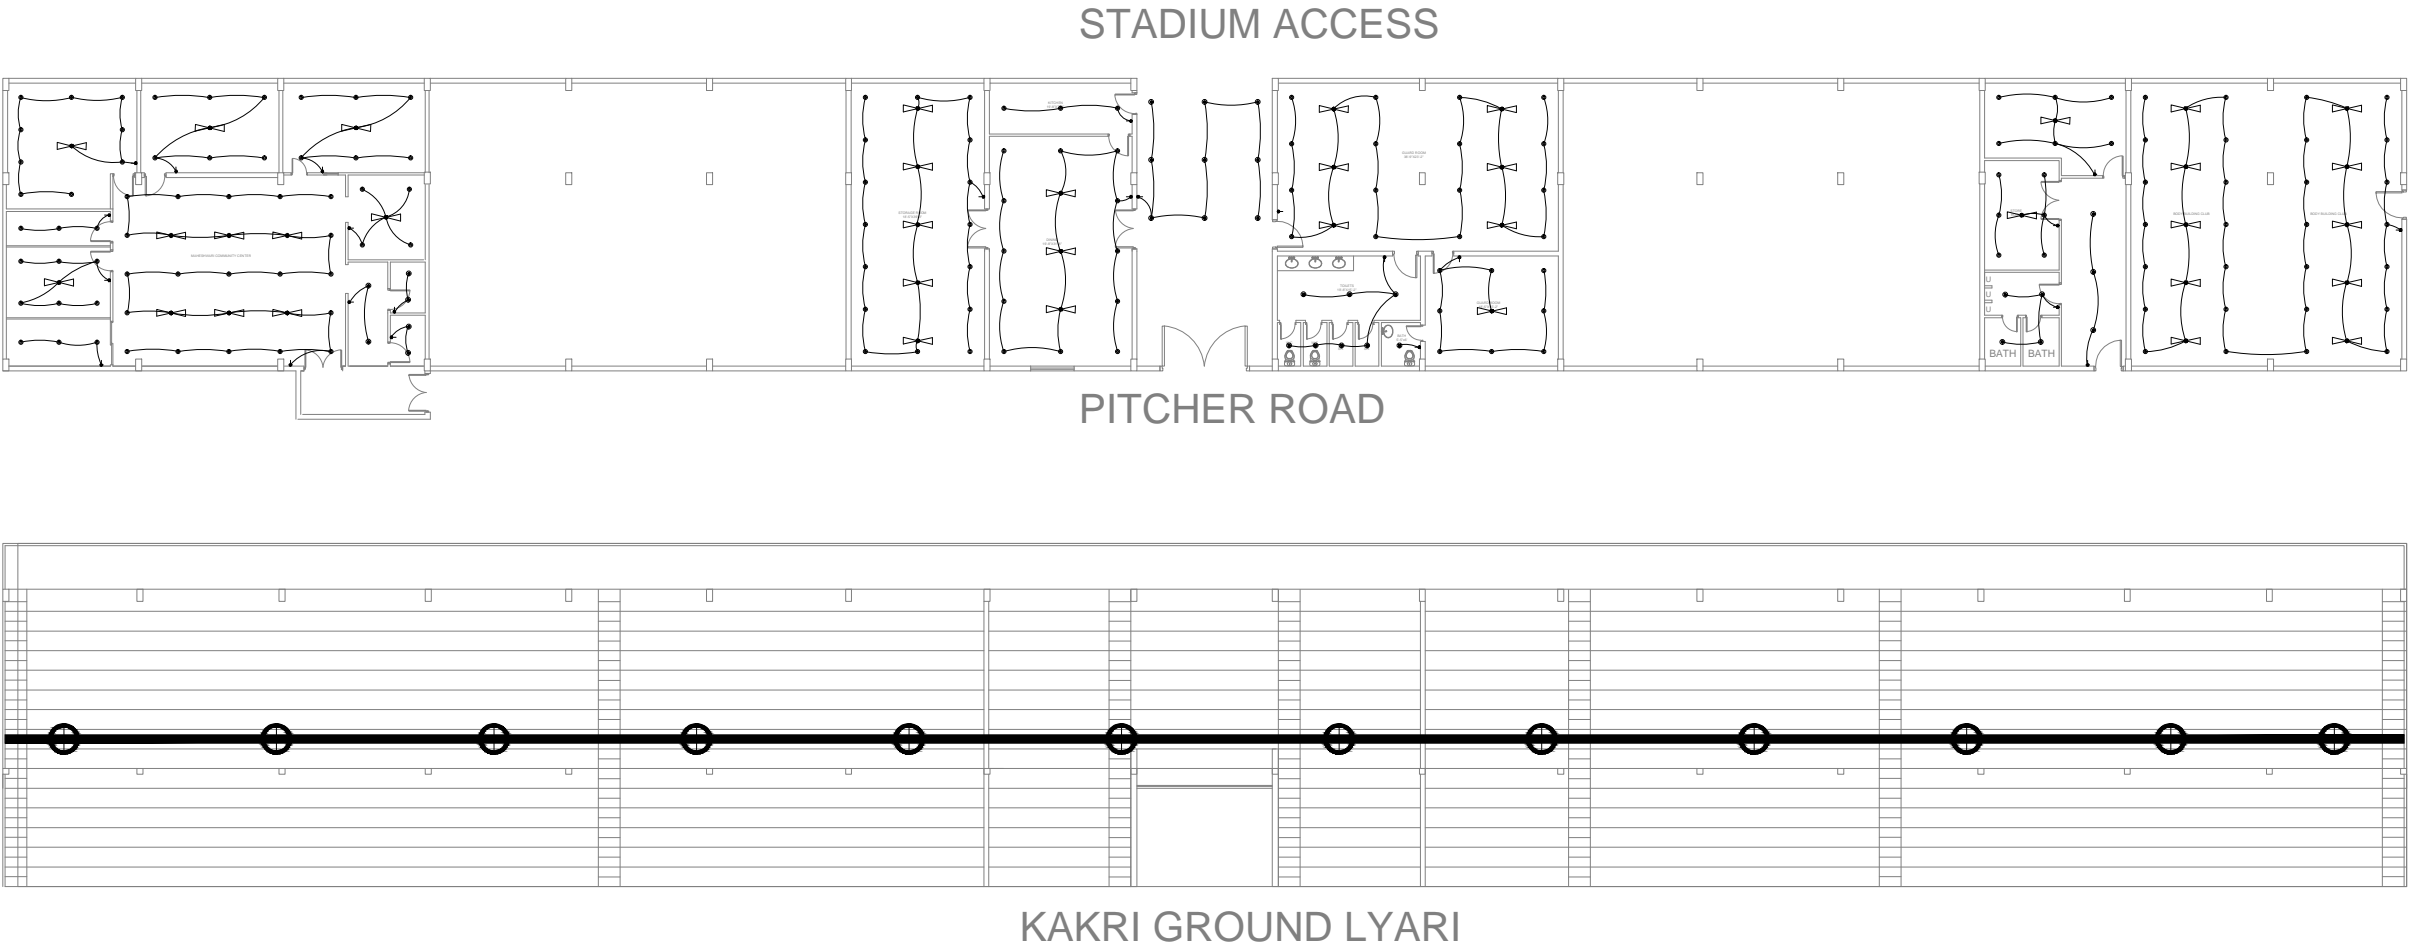



CLIENT:

**PROJECT  
IMPLEMENTATION  
UNIT (PIU) KNIP**



CONSULTANTS:

G3 ENGINEERING  
CONSULTANTS (PVT) LTD.  
House No.57-M Gulberg-III, Lahore, Pakistan



Tel : (92-42) 35441641, 35441642  
Fax : (92-42) 35441645  
E-mail : info@g3ec.com  
URL : www.g3ec.com

PROJECT:

**Karachi Neighbourhood  
Improvement Project (KNIP)**

SUB PROJECT:

**Redevelopment of Kakri Sports  
Complex and Neighborhood  
Improvement**

NOTES:

1. ALL DIMENSIONS ARE IN FEET UNLESS OTHERWISE SPECIFIED.
2. THIS DRAWING IS AN INTELLECTUAL PROPERTY OF G3 ENGINEERING CONSULTANTS (PVT.) LTD. AND CANNOT BE REPRINTED OR REPRODUCED WITHOUT PRIOR APPROVAL OF G3.

REVISIONS:

No.	DESCRIPTION	DATE

**TENDER DRAWINGS**

DRAWING TITLE:  
**EXISTING STADIA  
POWER DISTRIBUTION  
LAYOUT**

DRAWN BY: M.Raffeh DATE: SEP 2021


CHECKED BY: Eng.Ghulam Daraz Shaikh

Approved BY: Syed Ali Abbas Gillani


DRAWING NO: 0249/ST/027 REV: 0

SCALE (A3): N.T.S SHEET: 00/00

STADIUM ACCESS

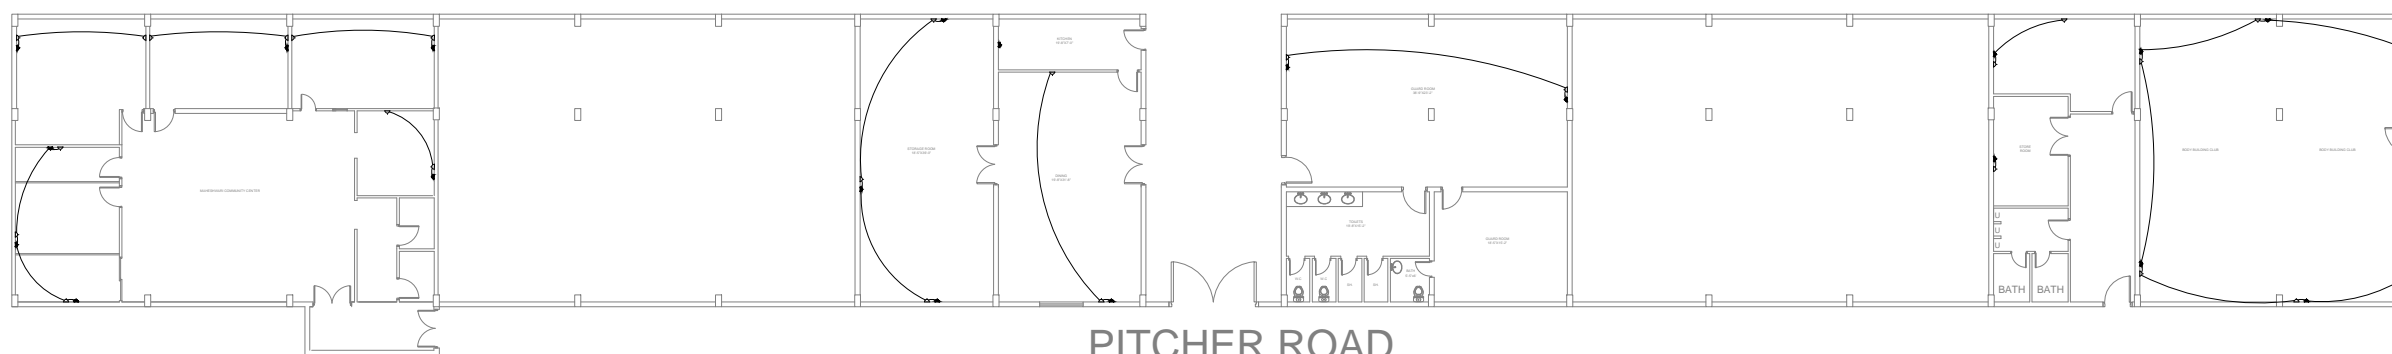

PITCHER ROAD

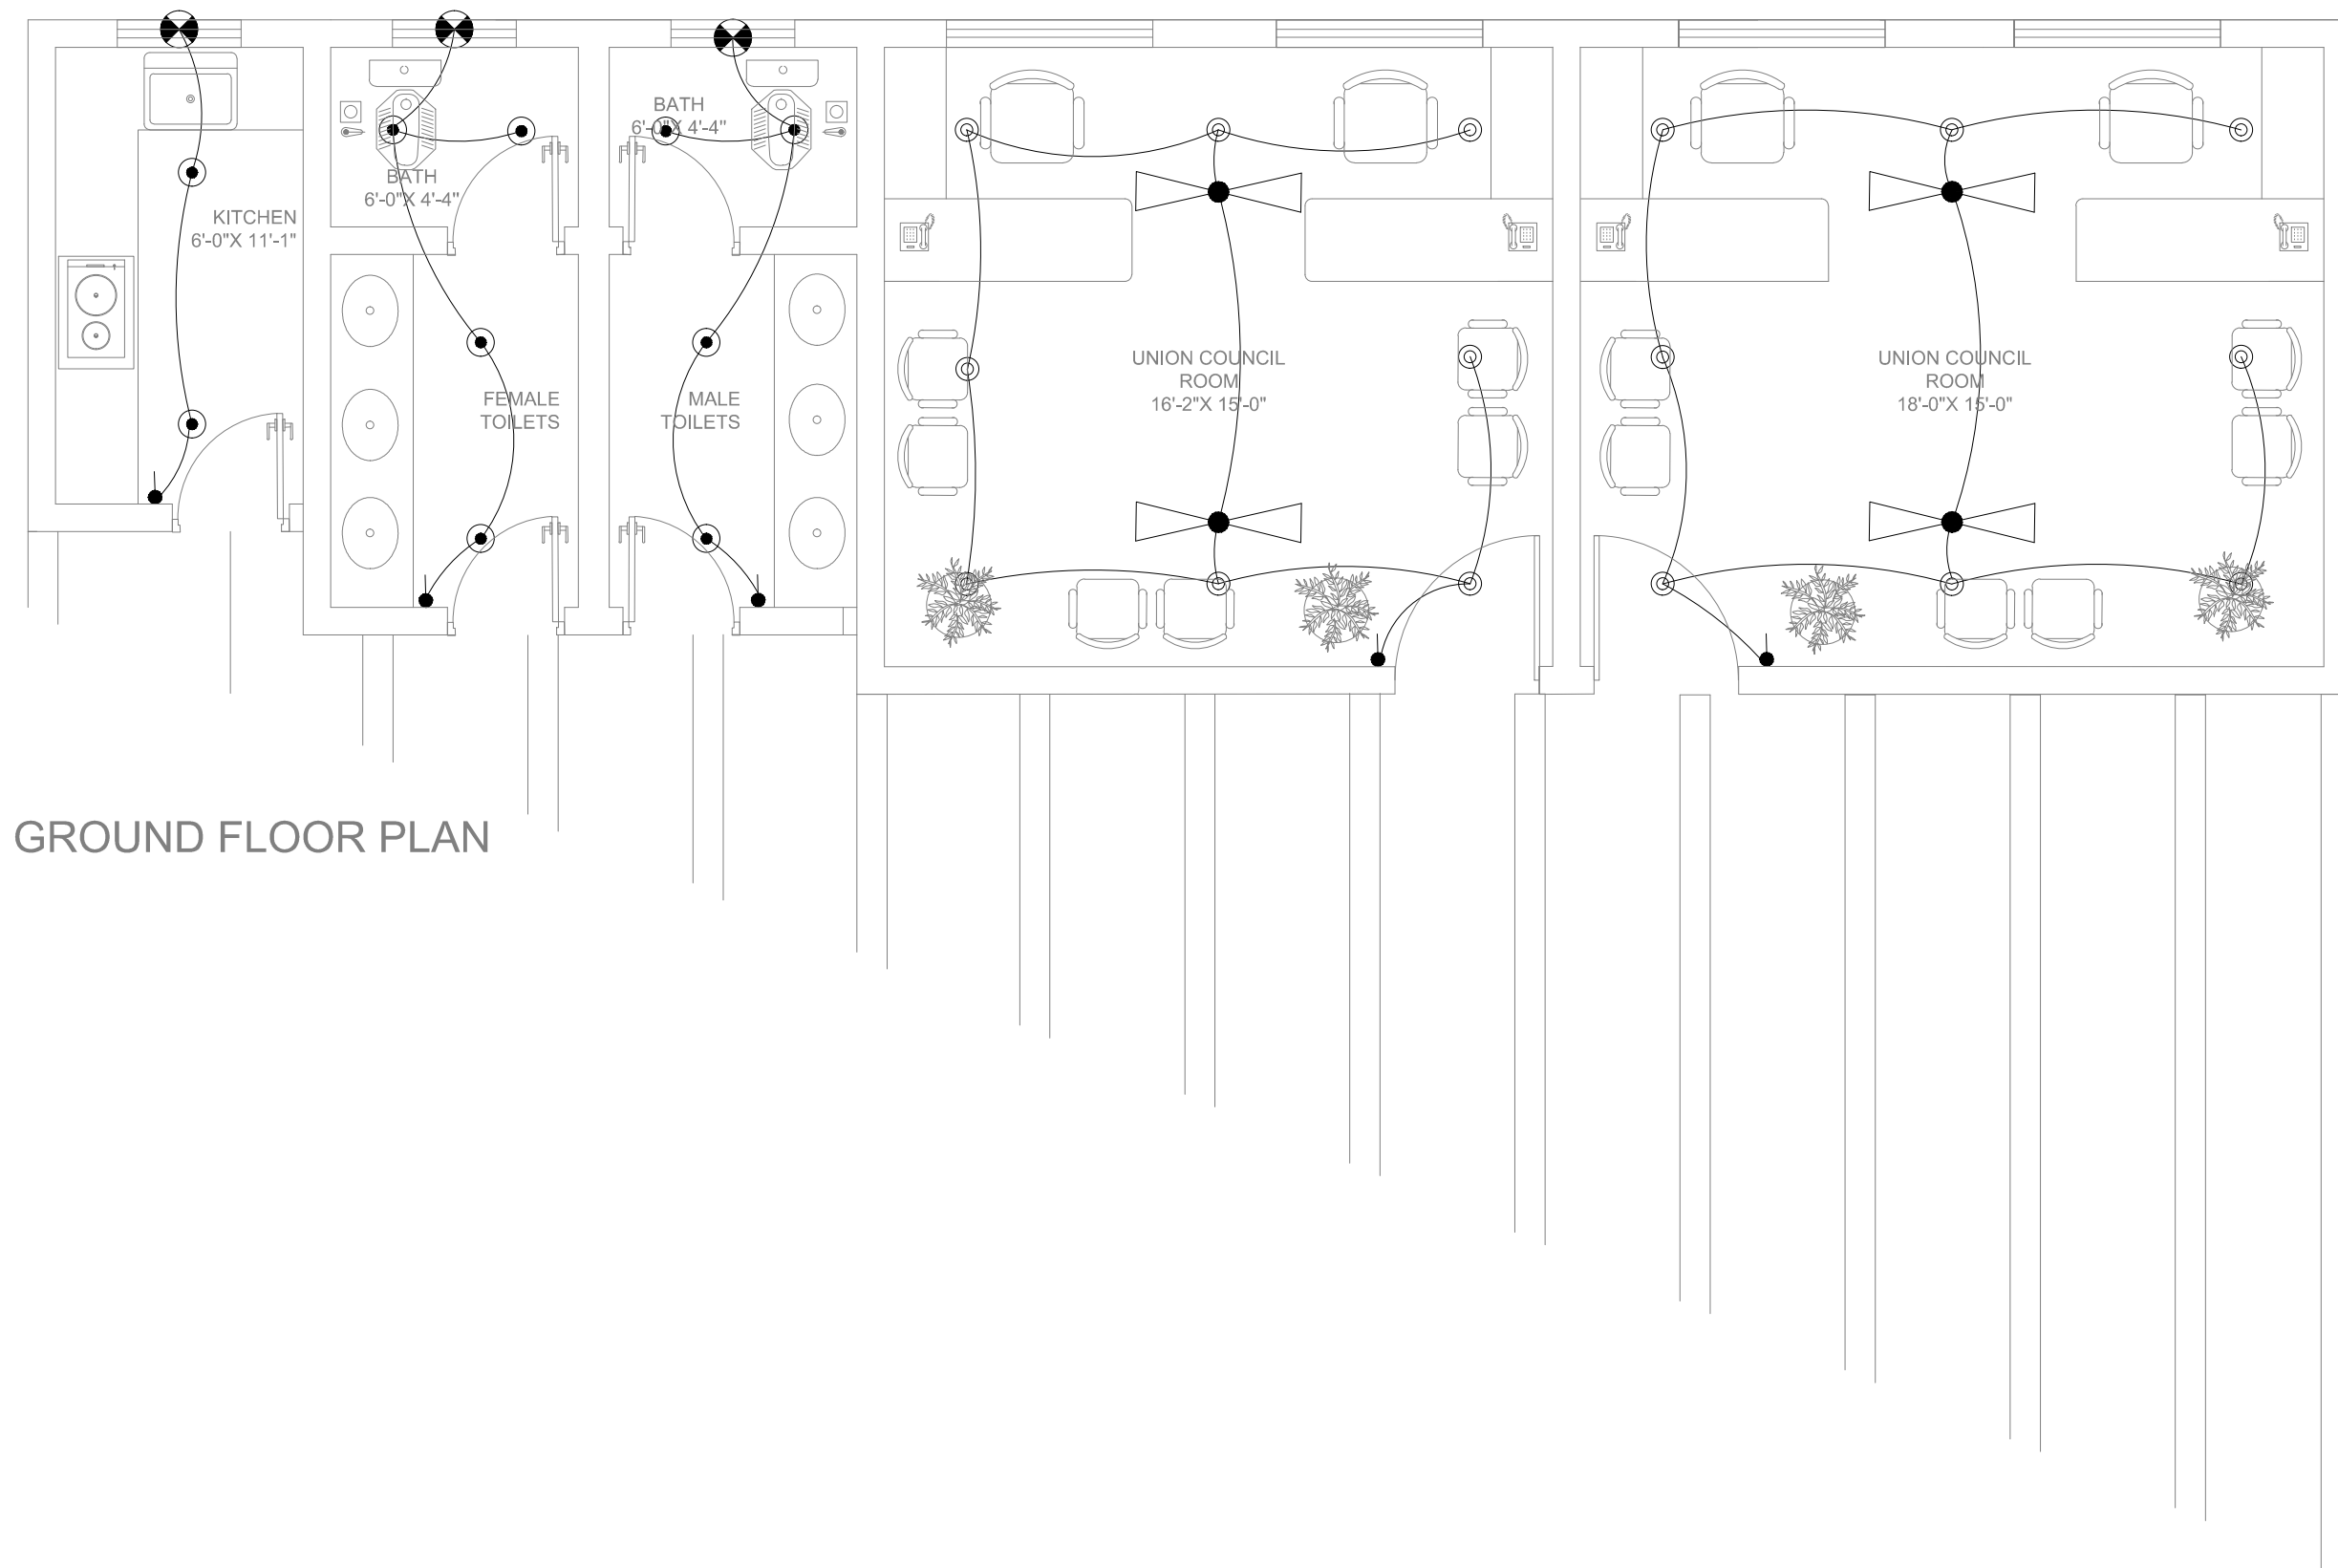

GROUND FLOOR PLAN

CLIENT:

**PROJECT  
IMPLEMENTATION  
UNIT (PIU) KNIP**




**CONSULTANTS:**

**G3 ENGINEERING  
CONSULTANTS (PVT) LTD.**  
House No.57-M Gulberg-III, Lahore, Pakistan

Tel : (92-42) 35441641, 35441642  
Fax : (92-42) 35441645  
E-mail : info@g3ec.com  
URL : www.g3ec.com

**PROJECT:**

**Karachi Neighbourhood  
Improvement Project (KNIP)**

**SUB PROJECT:**

**Redevelopment of Kakri Sports  
Complex and Neighborhood  
Improvement**

**NOTES:**

1. ALL DIMENSIONS ARE IN FEET UNLESS OTHERWISE SPECIFIED.
2. THIS DRAWING IS AN INTELLECTUAL PROPERTY OF G3 ENGINEERING CONSULTANTS (PVT.) LTD. AND CANNOT BE REPRINTED OR REPRODUCED WITHOUT PRIOR APPROVAL OF G3.


REVISIONS:		
No.	DESCRIPTION	DATE

**TENDER DRAWINGS**

DRAWING TITLE:

**UNION COUNCIL  
ILLUMINATION LAYOUT**

DRAWN BY: <b>M.Raffeh</b>	DATE: <b>SEP 2021</b>
CHECKED BY: <b>Eng.Ghulam Daraz Shaikh</b>	
Approved BY: <b>Syed Ali Abbas Gillani</b>	
DRAWING NO: <b>0249/UCO/028</b>	REV: <b>0</b>
SCALE (A3): <b>N.T.S</b>	SHEET: <b>00/00</b>

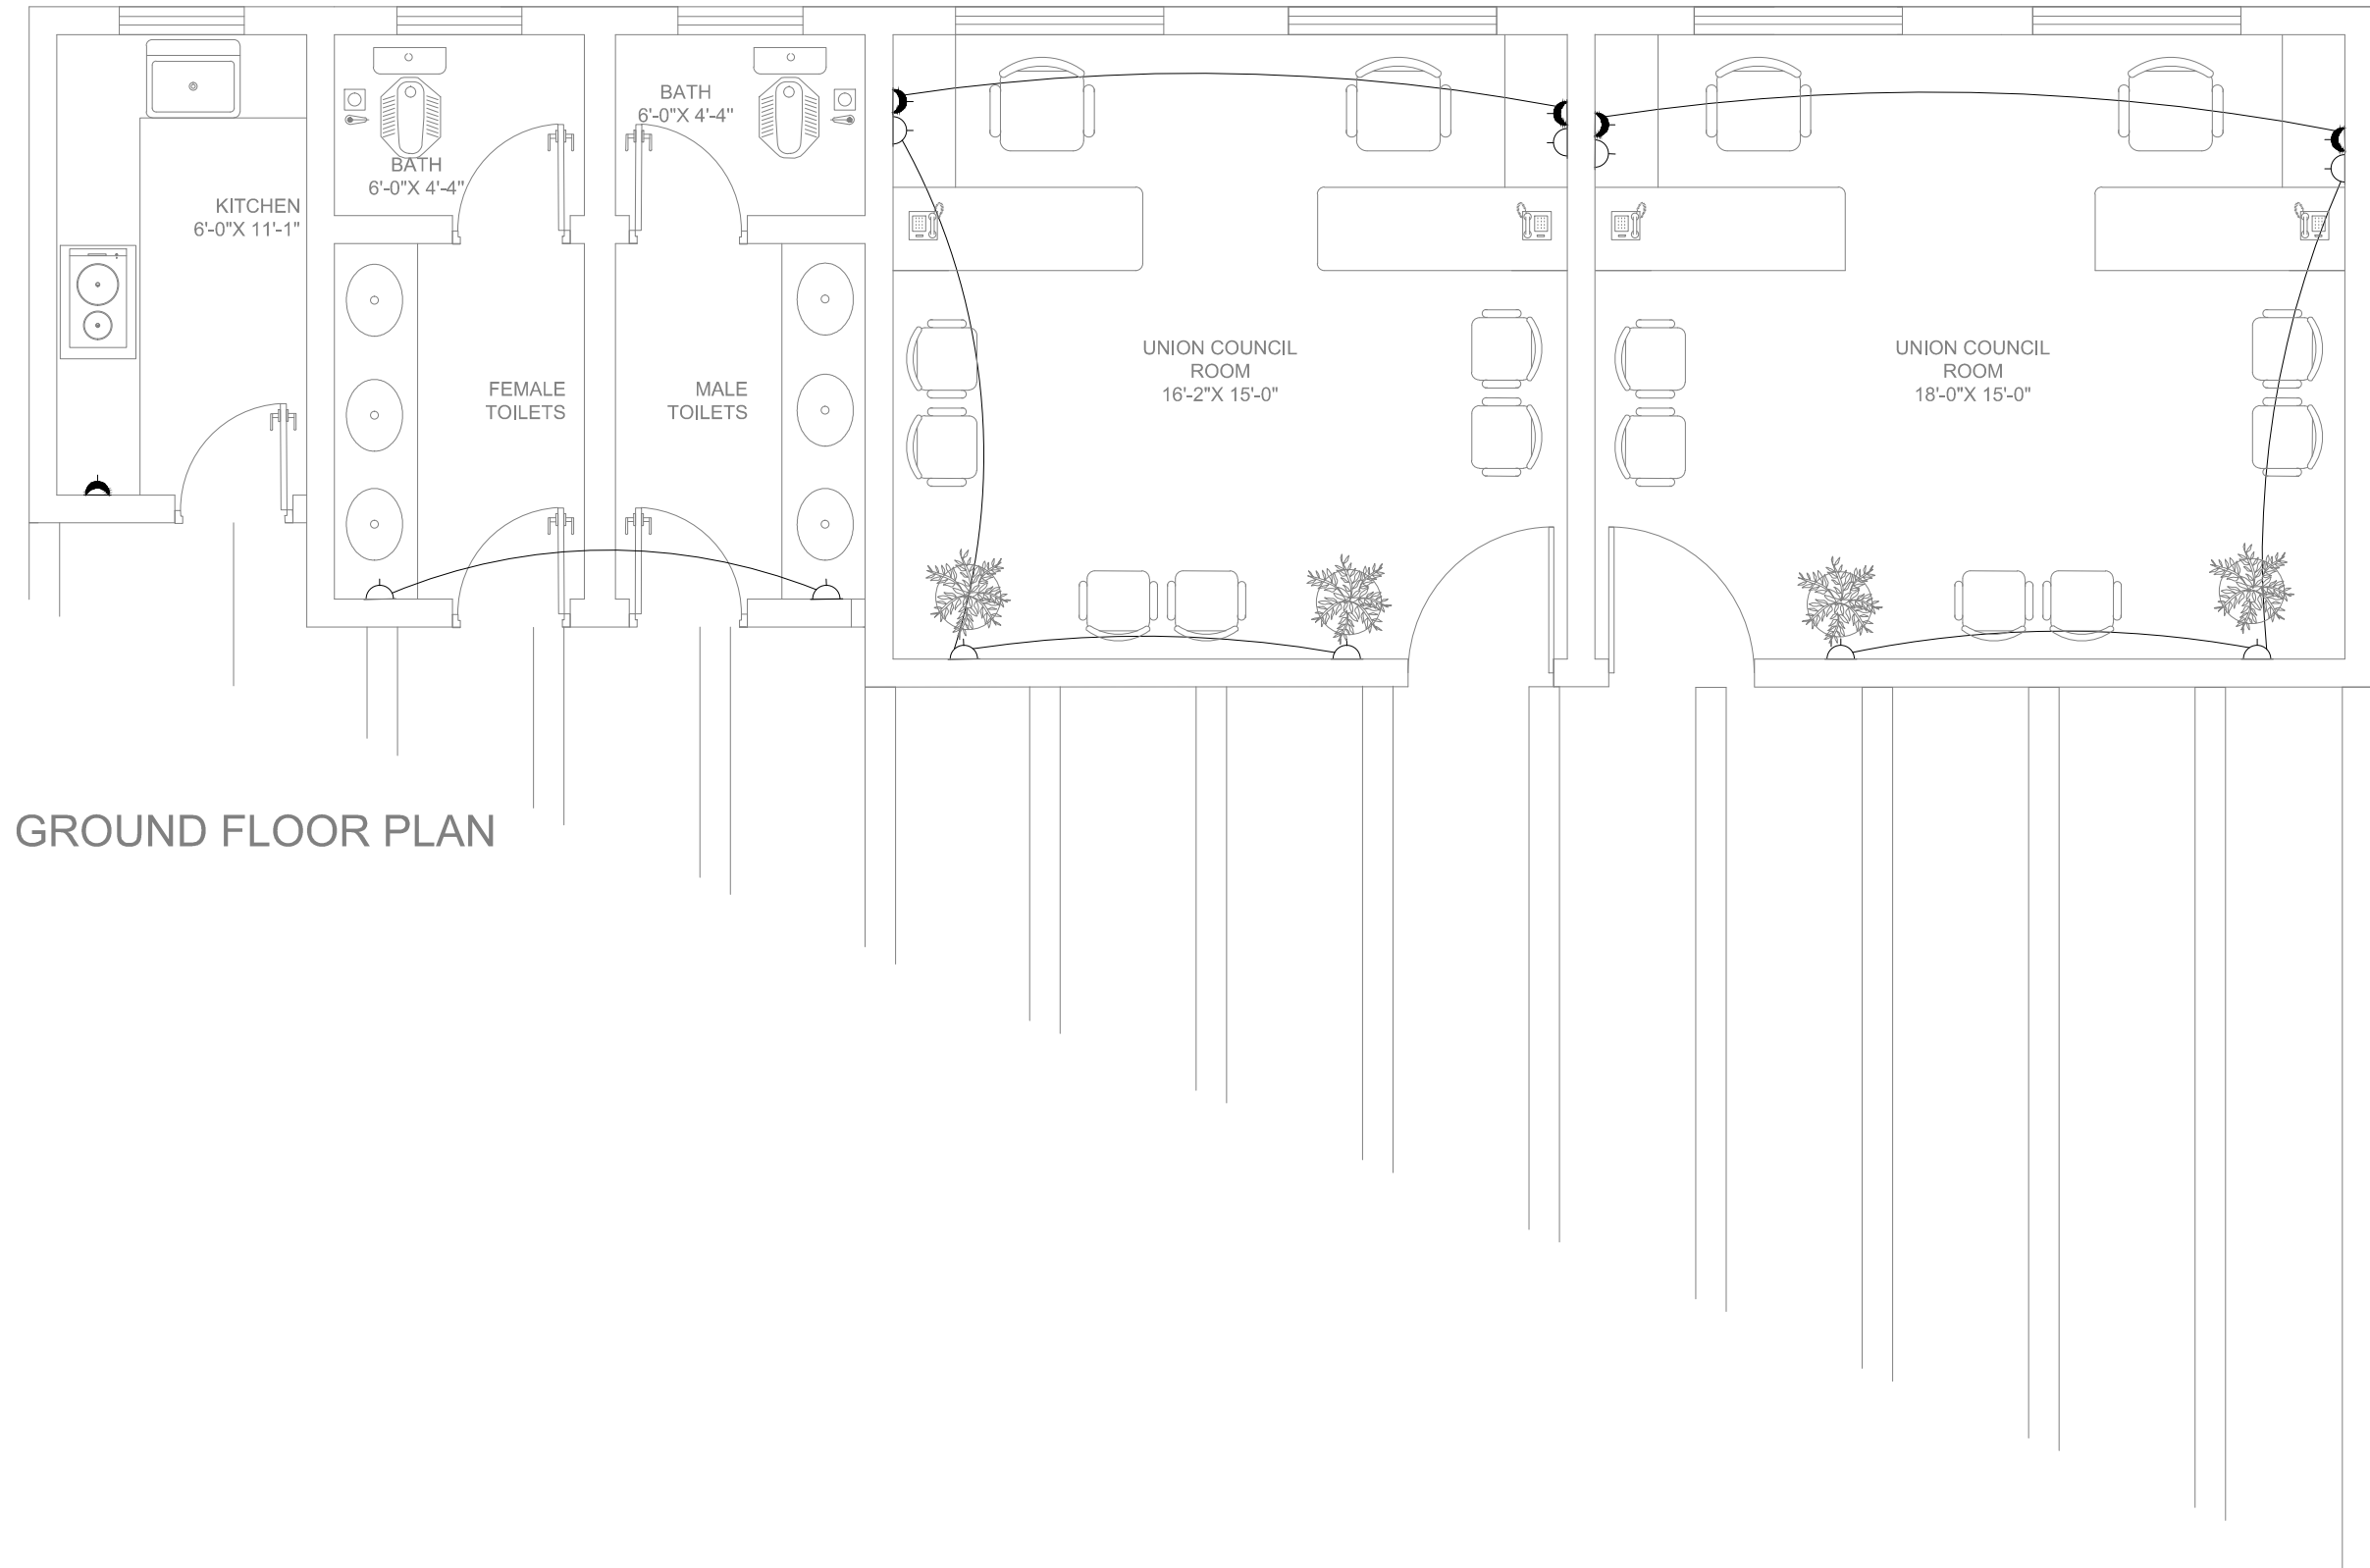

GROUND FLOOR PLAN

CLIENT:

 PROJECT  
IMPLEMENTATION  
UNIT (PIU) KNIP



CONSULTANTS:  
G3 ENGINEERING  
CONSULTANTS (PVT) LTD.  
House No.57-M Gulberg-III, Lahore, Pakistan



Tel : (92-42) 35441641, 35441642  
Fax : (92-42) 35441645  
E-mail : info@g3ec.com  
URL : www.g3ec.com

PROJECT:

**Karachi Neighbourhood  
Improvement Project (KNIP)**

SUB PROJECT:

**Redevelopment of Kakri Sports  
Complex and Neighborhood  
Improvement**

NOTES:

1. ALL DIMENSIONS ARE IN FEET UNLESS OTHERWISE SPECIFIED.
2. THIS DRAWING IS AN INTELLECTUAL PROPERTY OF G3 ENGINEERING CONSULTANTS (PVT.) LTD. AND CANNOT BE REPRINTED OR REPRODUCED WITHOUT PRIOR APPROVAL OF G3.

REVISIONS:

No.	DESCRIPTION	DATE

**TENDER DRAWINGS**

DRAWING TITLE:  
**UNION COUNCIL  
POWER DISTRIBUTION  
LAYOUT**


DRAWN BY: M.Raffeh DATE: SEP 2021

CHECKED BY: Eng.Ghulam Daraz Shaikh


Approved BY: Syed Ali Abbas Gillani

DRAWING NO: 0249/UCO/029 REV: 0

SCALE (A3): N.T.S SHEET: 00/00

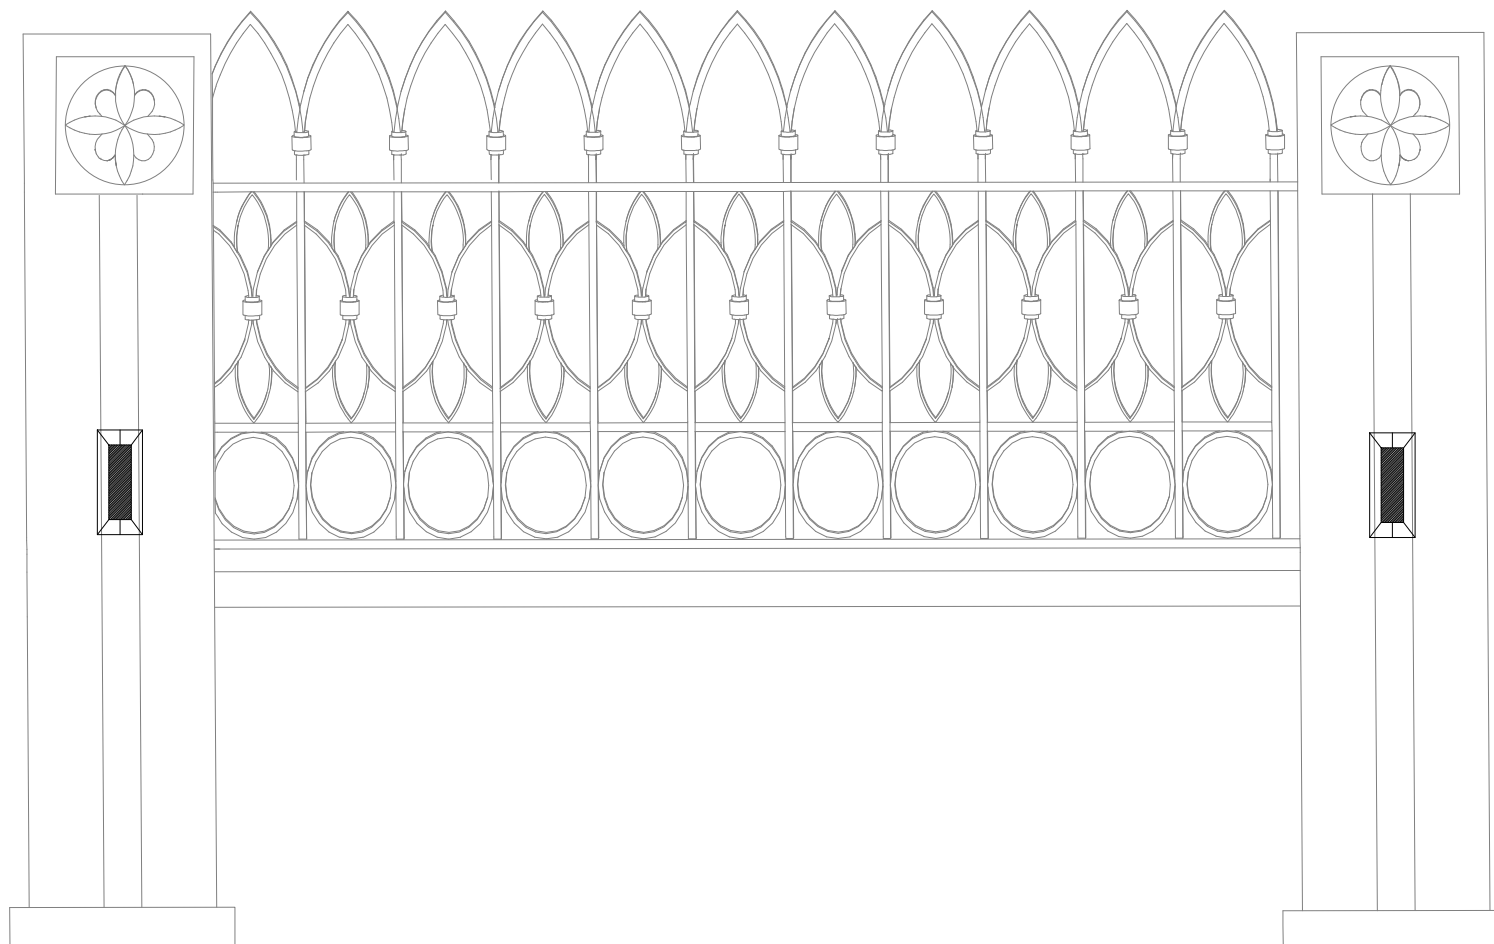

ELEVATION

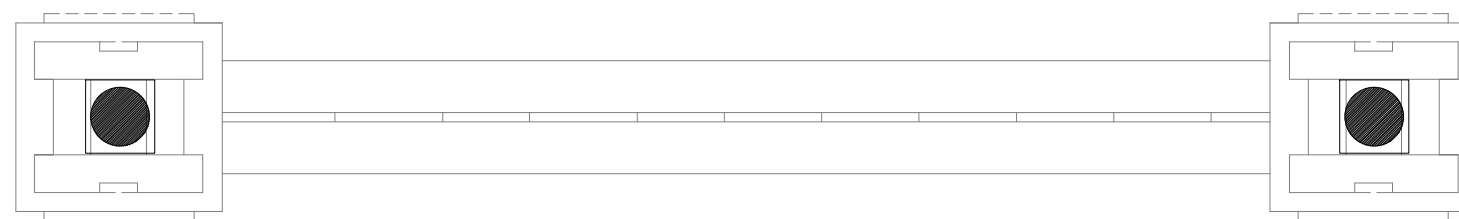

PLAN

CLIENT:



PROJECT  
IMPLEMENTATION  
UNIT (PIU) KNIP



CONSULTANTS:

G3 ENGINEERING  
CONSULTANTS (PVT) LTD.  
House No.57-M Gulberg-III, Lahore, Pakistan



Tel : (92-42) 35441641, 35441642  
Fax : (92-42) 35441645  
E-mail : info@g3ec.com  
URL : www.g3ec.com

PROJECT:

**Karachi Neighbourhood  
Improvement Project (KNIP)**

SUB PROJECT:

**Redevelopment of Kakri Sports  
Complex and Neighborhood  
Improvement**

NOTES:

1. ALL DIMENSIONS ARE IN FEET UNLESS OTHERWISE SPECIFIED.
2. THIS DRAWING IS AN INTELLECTUAL PROPERTY OF G3 ENGINEERING CONSULTANTS (PVT.) LTD. AND CANNOT BE REPRINTED OR REPRODUCED WITHOUT PRIOR APPROVAL OF G3.

REVISIONS:

No.	DESCRIPTION	DATE


**TENDER DRAWINGS**

DRAWING TITLE:


**PLAY GROUND  
BOUNDARY WALL**

DRAWN BY: <b>M.Raffeh</b>	DATE: <b>SEP 2021</b>
CHECKED BY: <b>Eng.Ghulam Daraz Shaikh</b>	
Approved BY: <b>Syed Ali Abbas Gillani</b>	
DRAWING NO: <b>0249/BW/030</b>	REV: <b>0</b>
SCALE (A3): <b>N.T.S</b>	SHEET: <b>00/00</b>



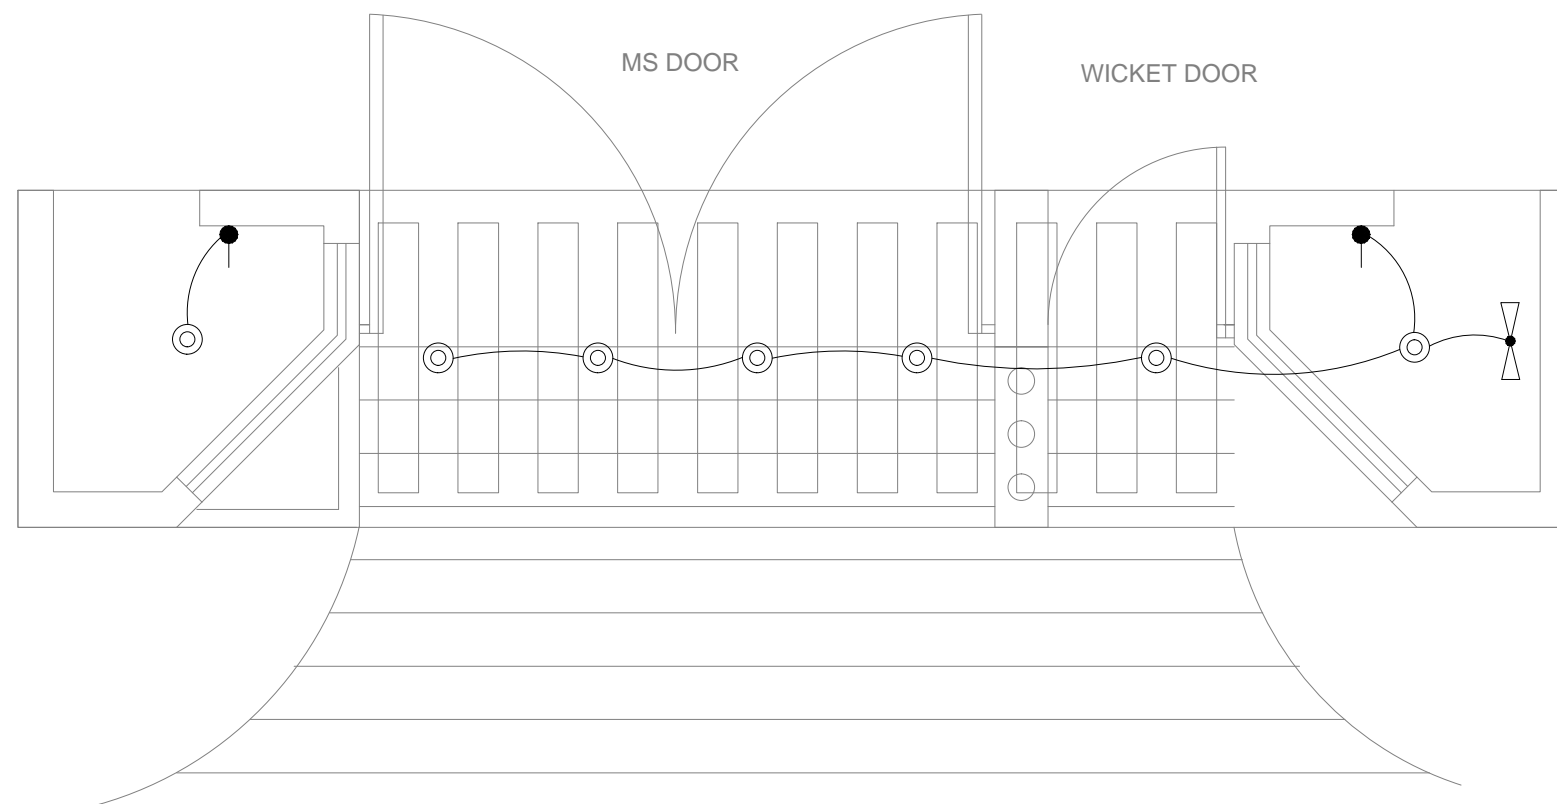

ENTRANCE GATE WORKING PLAN

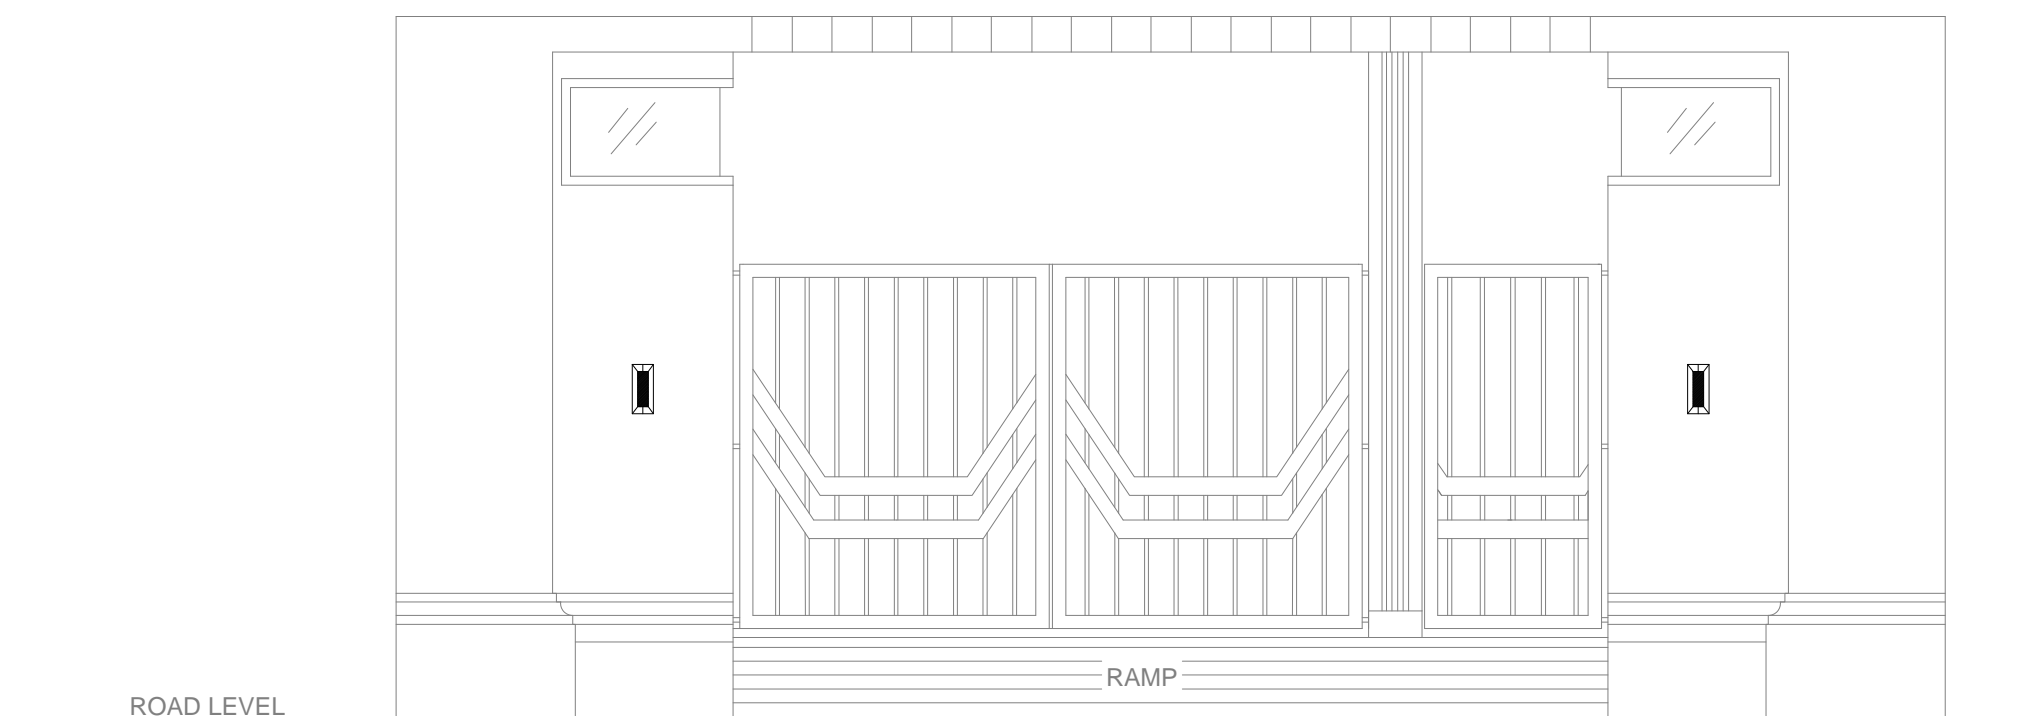

FRONT ELEVATION

CLIENT:



PROJECT  
IMPLEMENTATION  
UNIT (PIU) KNIP



CONSULTANTS:

G3 ENGINEERING  
CONSULTANTS (PVT) LTD.  
House No.57-M Gulberg-III, Lahore, Pakistan



Tel : (92-42) 35441641, 35441642  
Fax : (92-42) 35441645  
E-mail : info@g3ec.com  
URL : www.g3ec.com

PROJECT:

**Karachi Neighbourhood  
Improvement Project (KNIP)**

SUB PROJECT:

**Redevelopment of Kakri Sports  
Complex and Neighborhood  
Improvement**

NOTES:

1. ALL DIMENSIONS ARE IN FEET UNLESS OTHERWISE SPECIFIED.
2. THIS DRAWING IS AN INTELLECTUAL PROPERTY OF G3 ENGINEERING CONSULTANTS (PVT.) LTD. AND CANNOT BE REPRINTED OR REPRODUCED WITHOUT PRIOR APPROVAL OF G3.

REVISIONS:


No.	DESCRIPTION	DATE

**TENDER DRAWINGS**


DRAWING TITLE:

**PLAY GROUND  
ENTRANCE GATE**


DRAWN BY: M.Raffeh	DATE: SEP 2021
CHECKED BY: Eng.Ghulam Daraz Shaikh	
Approved BY: Syed Ali Abbas Gillani	
DRAWING NO: 0249/EG/031	REV: 0
SCALE (A3): N.T.S	SHEET: 00/00

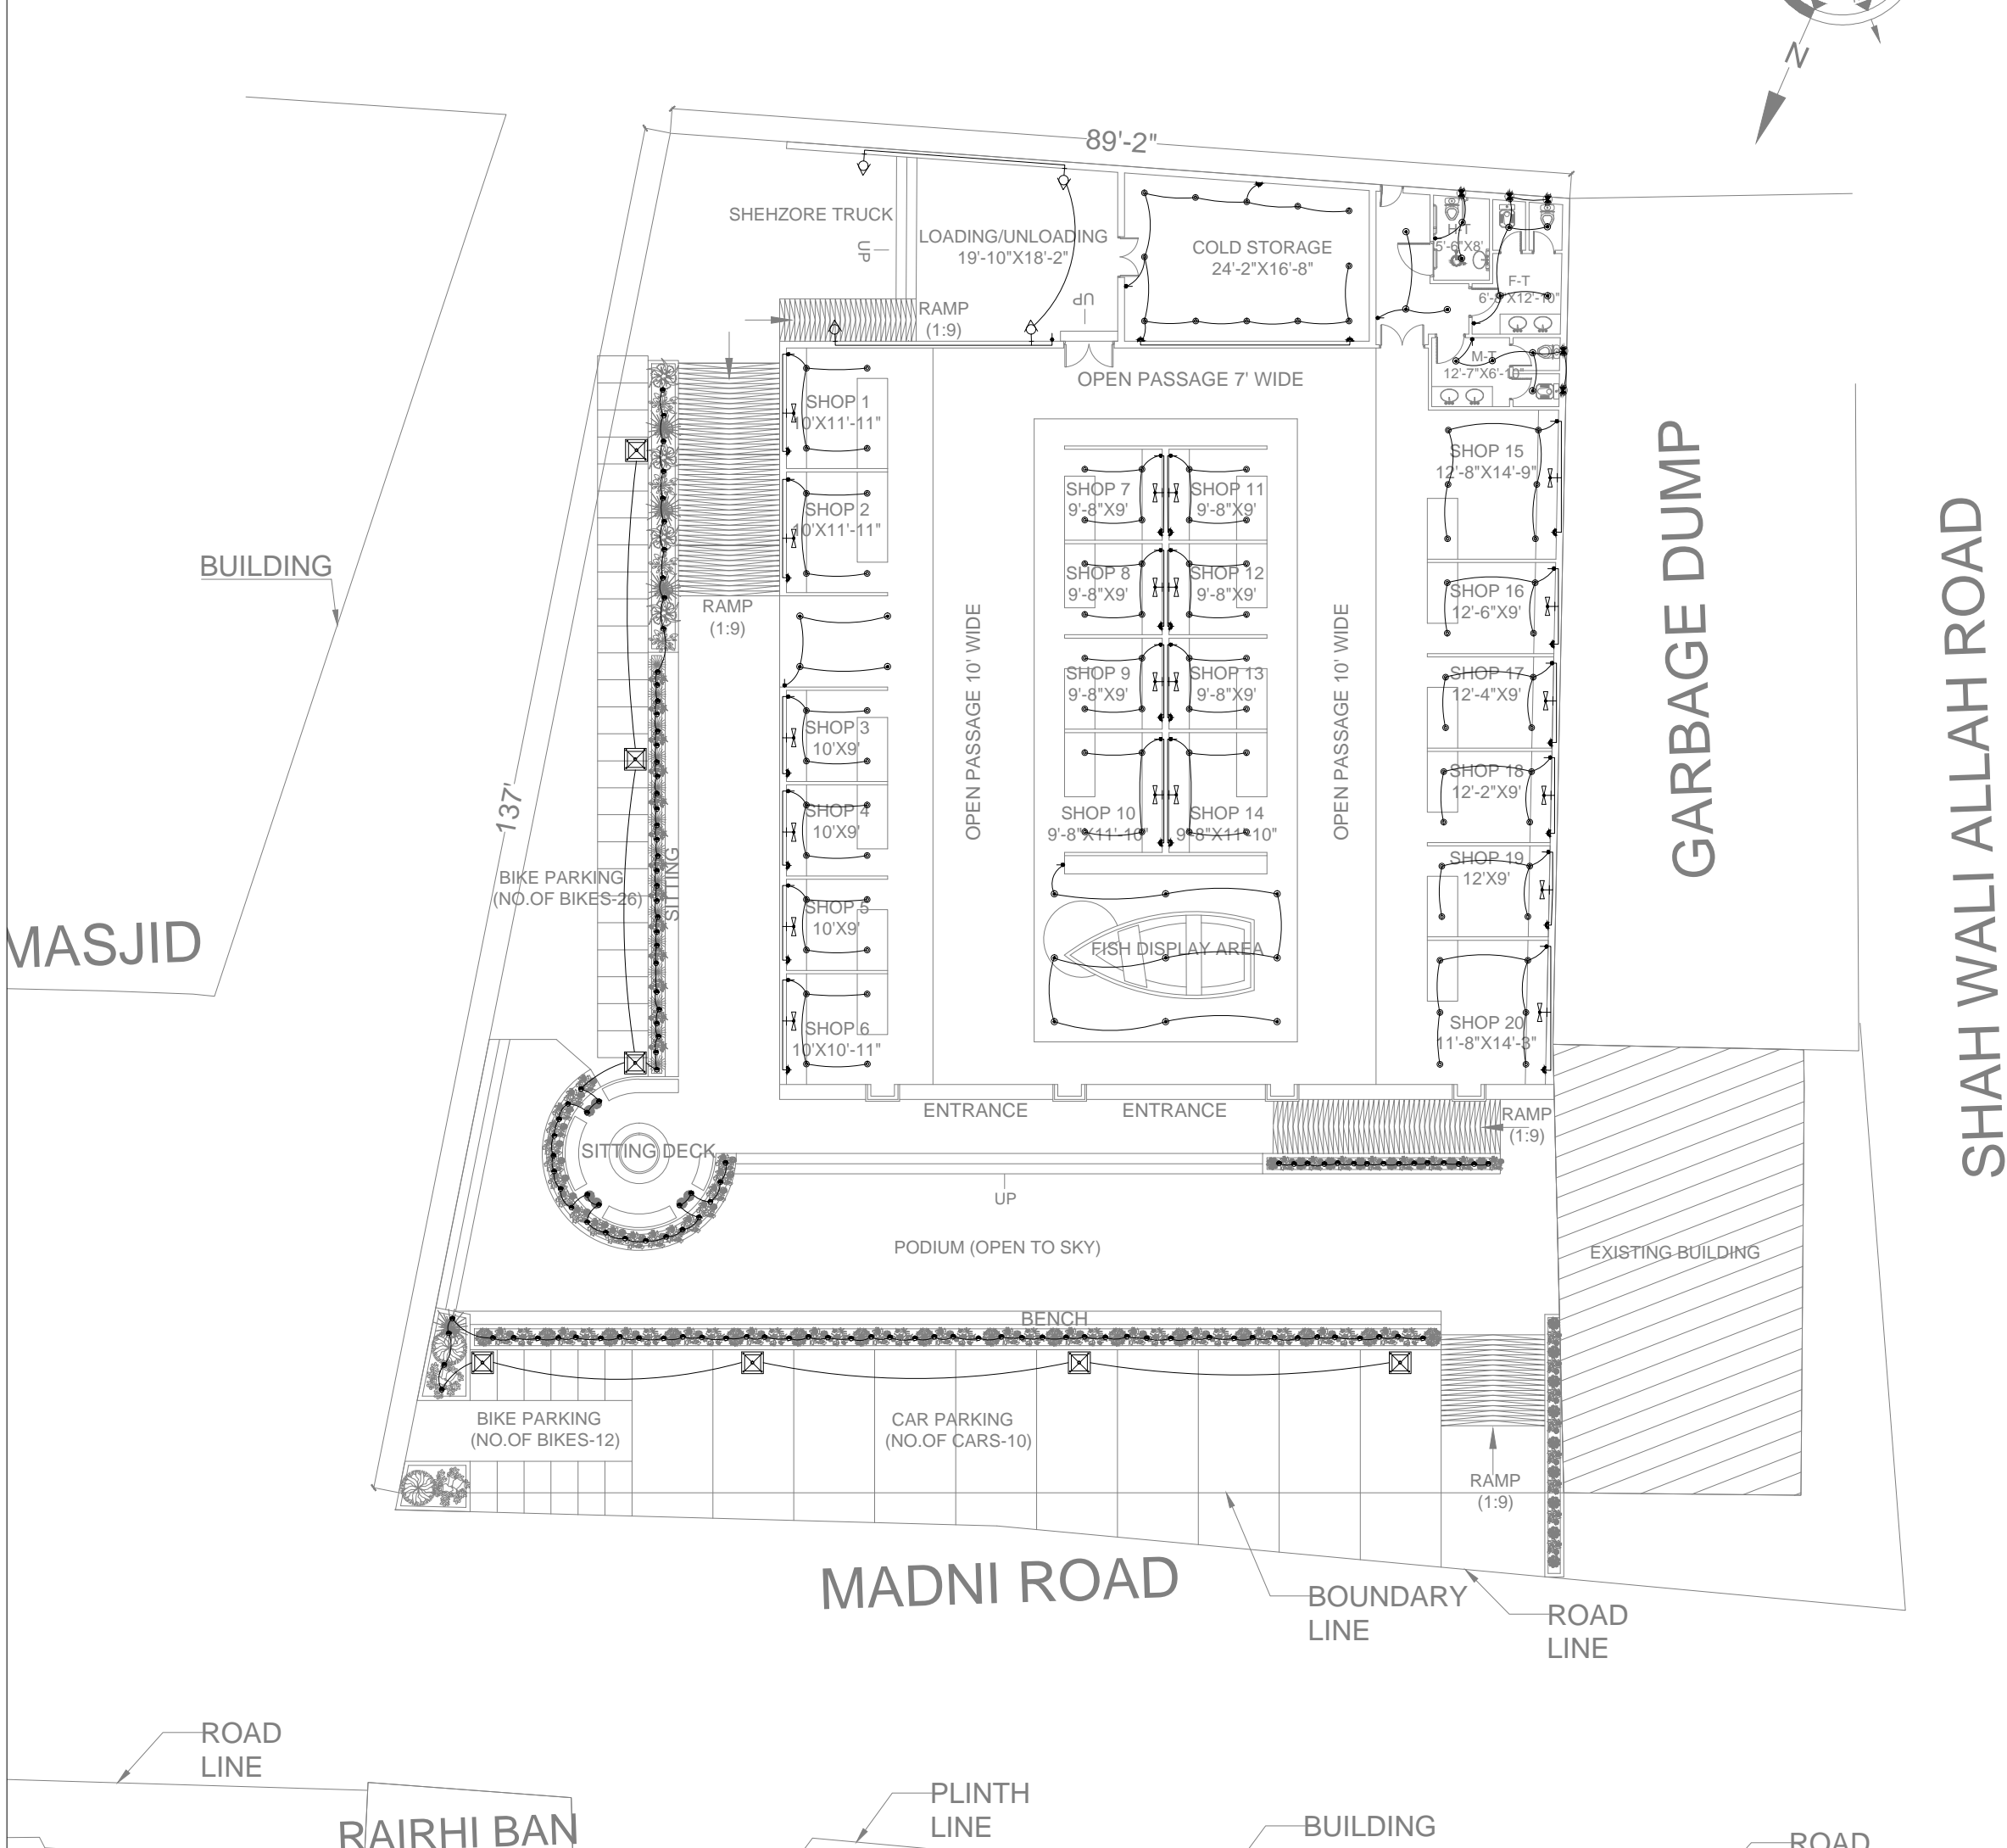

CLIENT:

 PROJECT IMPLEMENTATION UNIT (PIU) KNIP

CONSULTANTS:

 G3 ENGINEERING CONSULTANTS (PVT) LTD.  
House No.57-M Gulberg-III, Lahore, Pakistan

Tel : (92-42) 35441641, 35441642  
Fax : (92-42) 35441645  
E-mail : info@g3ec.com  
URL : www.g3ec.com

PROJECT:

**Karachi Neighbourhood Improvement Project (KNIP)**

SUB PROJECT:

**Redevelopment of Kakri Sports Complex and Neighborhood Improvement**

NOTES:

1. ALL DIMENSIONS ARE IN FEET UNLESS OTHERWISE SPECIFIED.  
2. THIS DRAWING IS AN INTELLECTUAL PROPERTY OF G3 ENGINEERING CONSULTANTS (PVT.) LTD. AND CANNOT BE REPRINTED OR REPRODUCED WITHOUT PRIOR APPROVAL OF G3.

REVISIONS:		
No.	DESCRIPTION	DATE


**TENDER DRAWINGS**

DRAWING TITLE:

**FISH MARKET**

DRAWN BY: M.Raffeh	DATE: SEP 2021
CHECKED BY: Eng.Ghulam Daraz Shaikh	
Approved BY: Syed Ali Abbas Gillani	
DRAWING NO: 0249/FM/032	REV: 0
SCALE (A3): N.T.S	SHEET: 00/00

REDEVELOPMENT OF  
KHARADAR LOCALITY  
ELECTRICAL DRAWINGS  
ALLAH RAKHA PARK

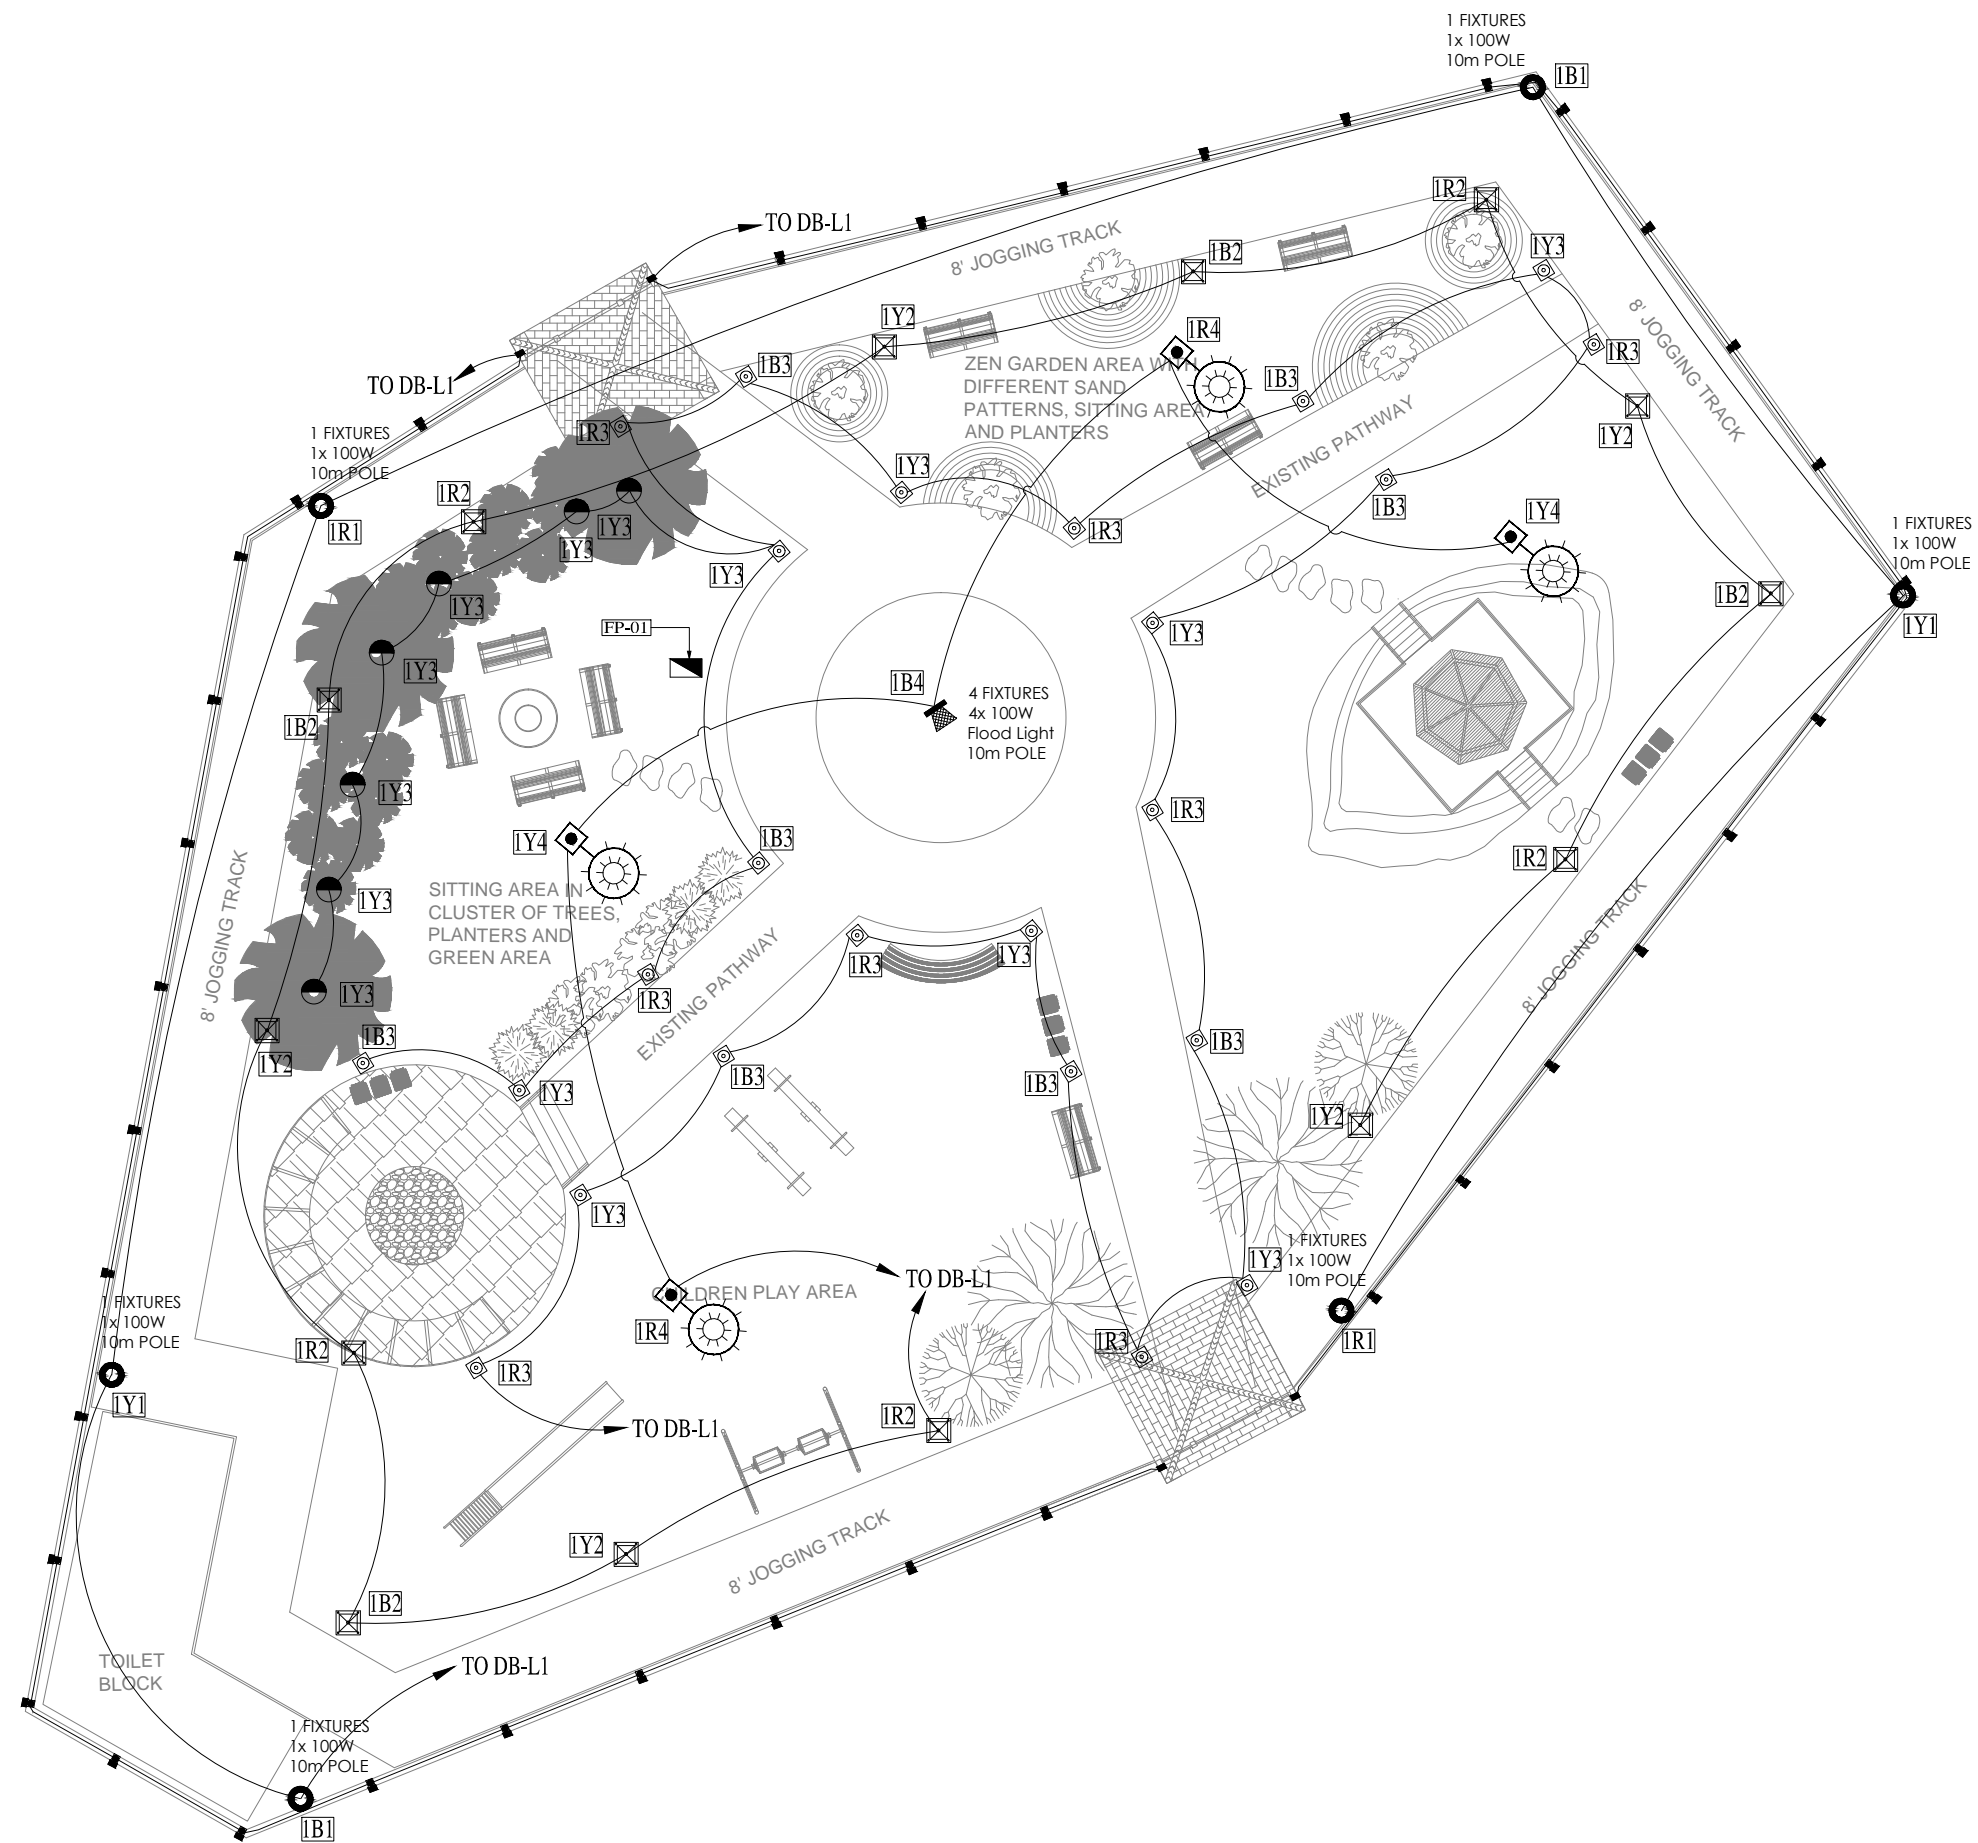

ALLAH RAKHA PARK – WORKING PLAN

 
CLIENT:

**PROJECT  
IMPLEMENTATION  
UNIT (PIU) KNIP**



CONSULTANTS:

G3 ENGINEERING  
CONSULTANTS (PVT) LTD.  
House No.57-M Gulberg-III, Lahore, Pakistan



Tel : (92-42) 35441641, 35441642  
Fax : (92-42) 35441645  
E-mail : info@g3ec.com  
URL : www.g3ec.com

PROJECT:

**Karachi Neighbourhood  
Improvement Project (KNIP)**

SUB PROJECT:

**Redevelopment of Kharadar  
Locality**

NOTES:

1. ALL DIMENSIONS ARE IN FEET UNLESS OTHERWISE SPECIFIED.
2. THIS DRAWING IS AN INTELLECTUAL PROPERTY OF G3 ENGINEERING CONSULTANTS (PVT.) LTD. AND CANNOT BE REPRINTED OR REPRODUCED WITHOUT PRIOR APPROVAL OF G3.

REVISIONS:

No.	DESCRIPTION	DATE


**TENDER DRAWINGS**

DRAWING TITLE:

**PARK  
ILLUMINATION LAYOUT**

DRAWN BY: M.Raffeh	DATE: SEP 2021
CHECKED BY: Eng.Ghulam Daraz Shaikh	
Approved BY: Syed Ali Abbas Gillani	
DRAWING NO: 0249/PARK/033	REV: 0
SCALE (A3): N.T.S	SHEET: 00/00



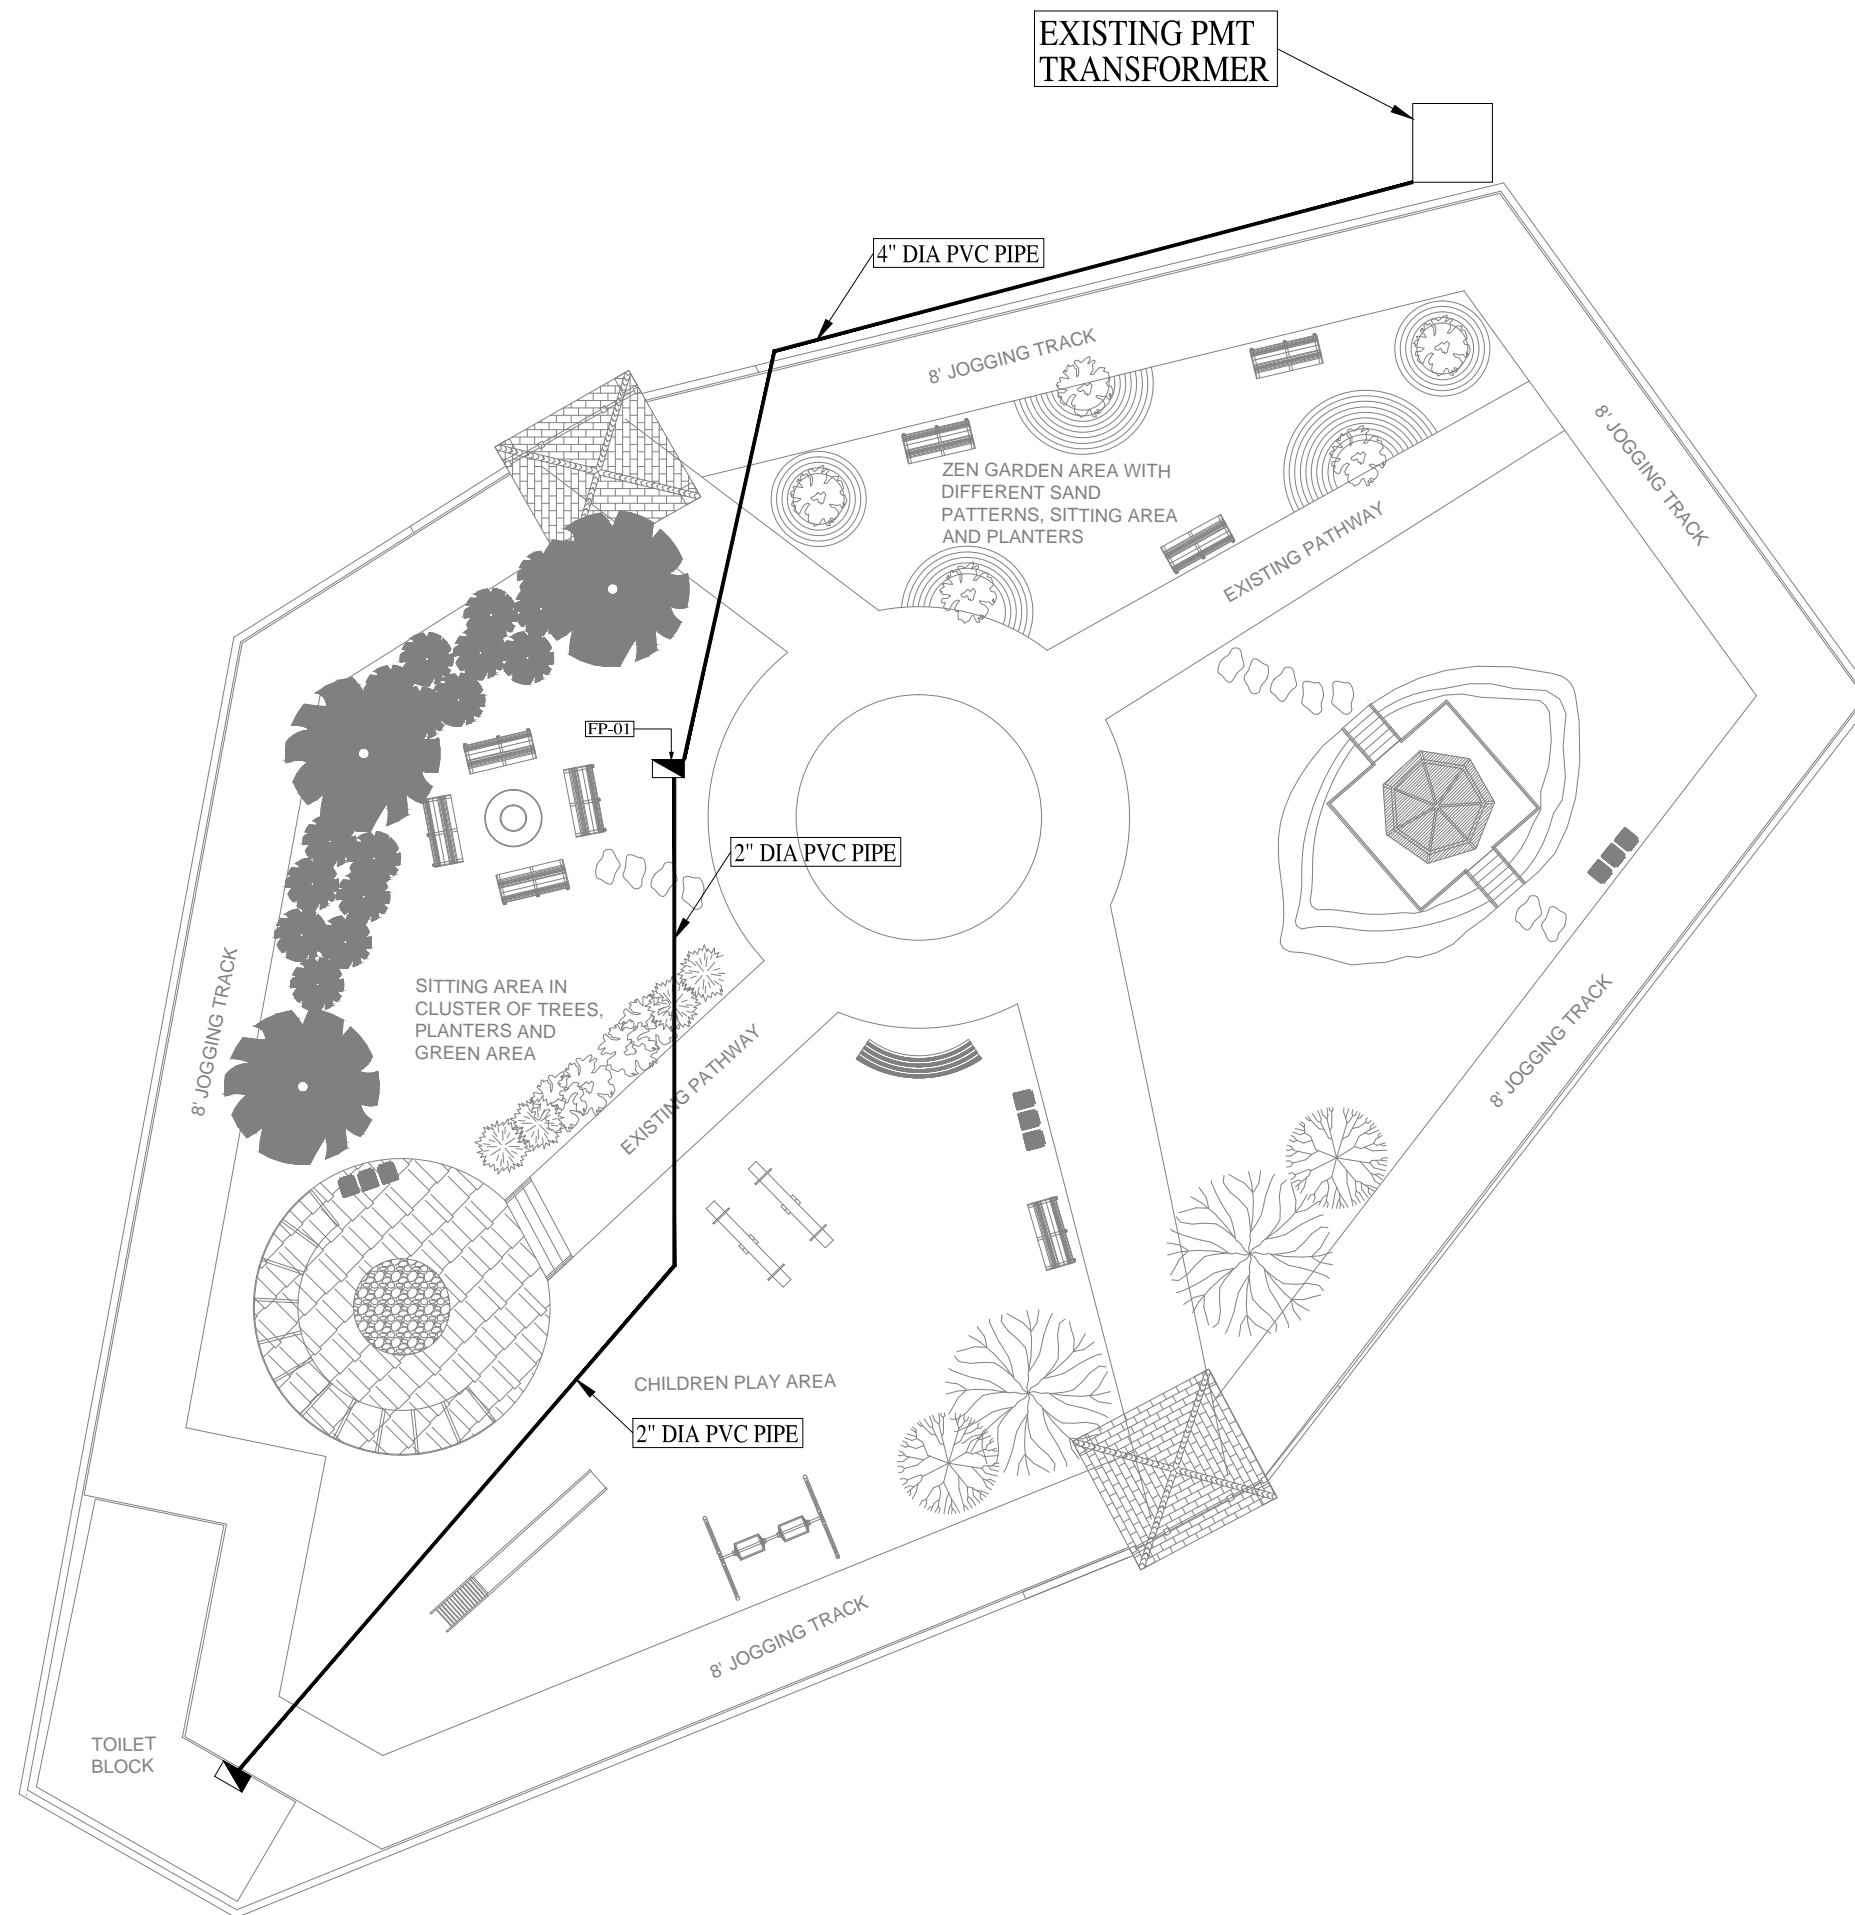

ALLAH RAKHA PARK – WORKING PLAN

CLIENT:



PROJECT  
IMPLEMENTATION  
UNIT (PIU) KNIP



CONSULTANTS:

G3 ENGINEERING  
CONSULTANTS (PVT) LTD.  
House No.57-M Gulberg-III, Lahore, Pakistan



Tel : (92-42) 35441641, 35441642  
Fax : (92-42) 35441645  
E-mail : info@g3ec.com  
URL : www.g3ec.com

PROJECT:

**Karachi Neighbourhood  
Improvement Project (KNIP)**

SUB PROJECT:

**Redevelopment of Kharadar  
Locality**

NOTES:

1. ALL DIMENSIONS ARE IN FEET UNLESS OTHERWISE SPECIFIED.
2. THIS DRAWING IS AN INTELLECTUAL PROPERTY OF G3 ENGINEERING CONSULTANTS (PVT.) LTD. AND CANNOT BE REPRINTED OR REPRODUCED WITHOUT PRIOR APPROVAL OF G3.

REVISIONS:


No.	DESCRIPTION	DATE

**TENDER DRAWINGS**

DRAWING TITLE:

**PARK  
POWER DISTRIBUTION**

DRAWN BY: M.Raffeh	DATE: SEP 2021
CHECKED BY: Eng.Ghulam Daraz Shaikh	
Approved BY: Syed Ali Abbas Gillani	
DRAWING NO: 0249/PARK/034	REV: 0
SCALE (A3): N.T.S	SHEET: 00/00

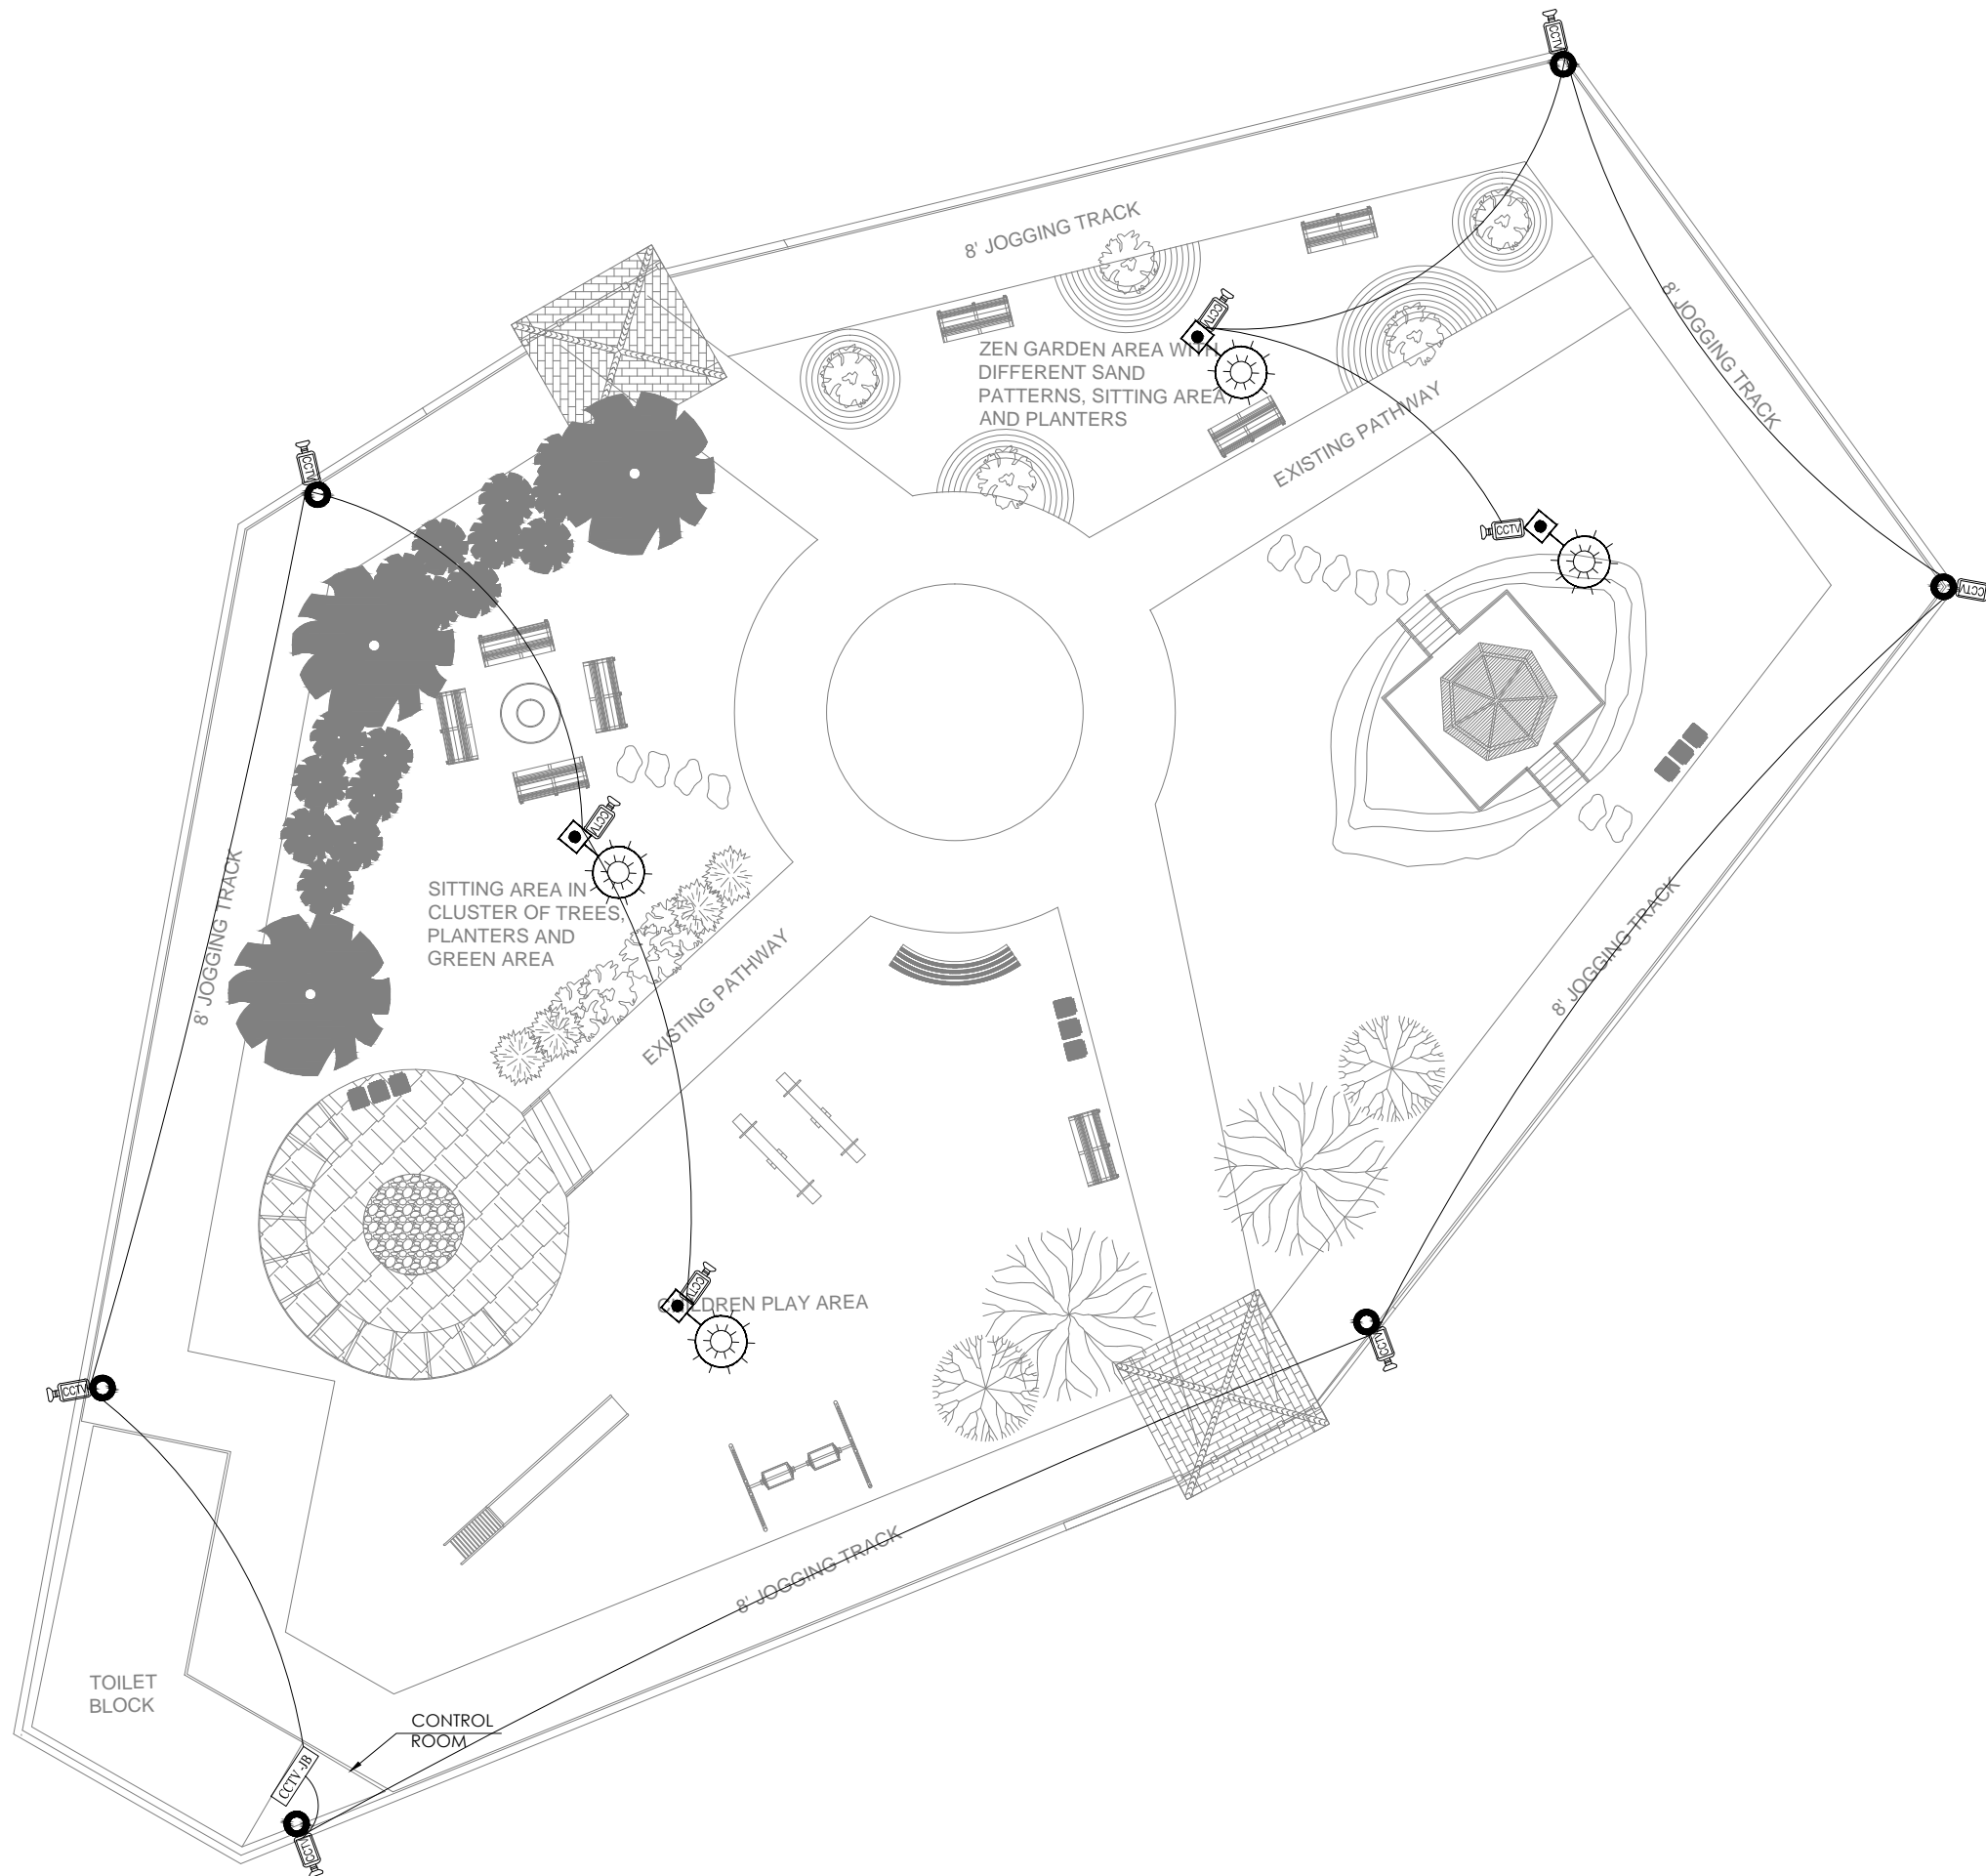

ALLAH RAKHA PARK – WORKING PLAN

CLIENT:



PROJECT  
IMPLEMENTATION  
UNIT (PIU) KNIP



CONSULTANTS:

G3 ENGINEERING  
CONSULTANTS (PVT) LTD.  
House No.57-M Gulberg-III, Lahore, Pakistan



Tel : (92-42) 35441641, 35441642  
Fax : (92-42) 35441645  
E-mail : info@g3ec.com  
URL : www.g3ec.com

PROJECT:

**Karachi Neighbourhood  
Improvement Project (KNIP)**

SUB PROJECT:

**Redevelopment of Kharadar  
Locality**

NOTES:

1. ALL DIMENSIONS ARE IN FEET UNLESS OTHERWISE SPECIFIED.
2. THIS DRAWING IS AN INTELLECTUAL PROPERTY OF G3 ENGINEERING CONSULTANTS (PVT.) LTD. AND CANNOT BE REPRINTED OR REPRODUCED WITHOUT PRIOR APPROVAL OF G3.

REVISIONS:

No.	DESCRIPTION	DATE

**TENDER DRAWINGS**

DRAWING TITLE:

**PARK  
CCTV LAYOUT**

DRAWN BY:

M.Raffeh

DATE:

SEP 2021

CHECKED BY:

Eng.Ghulam Daraz Shaikh

Approved BY:

Syed Ali Abbas Gillani

DRAWING NO:

0249/PARK/035

REV:


0

SCALE (A3):

N.T.S

SHEET:

00/00

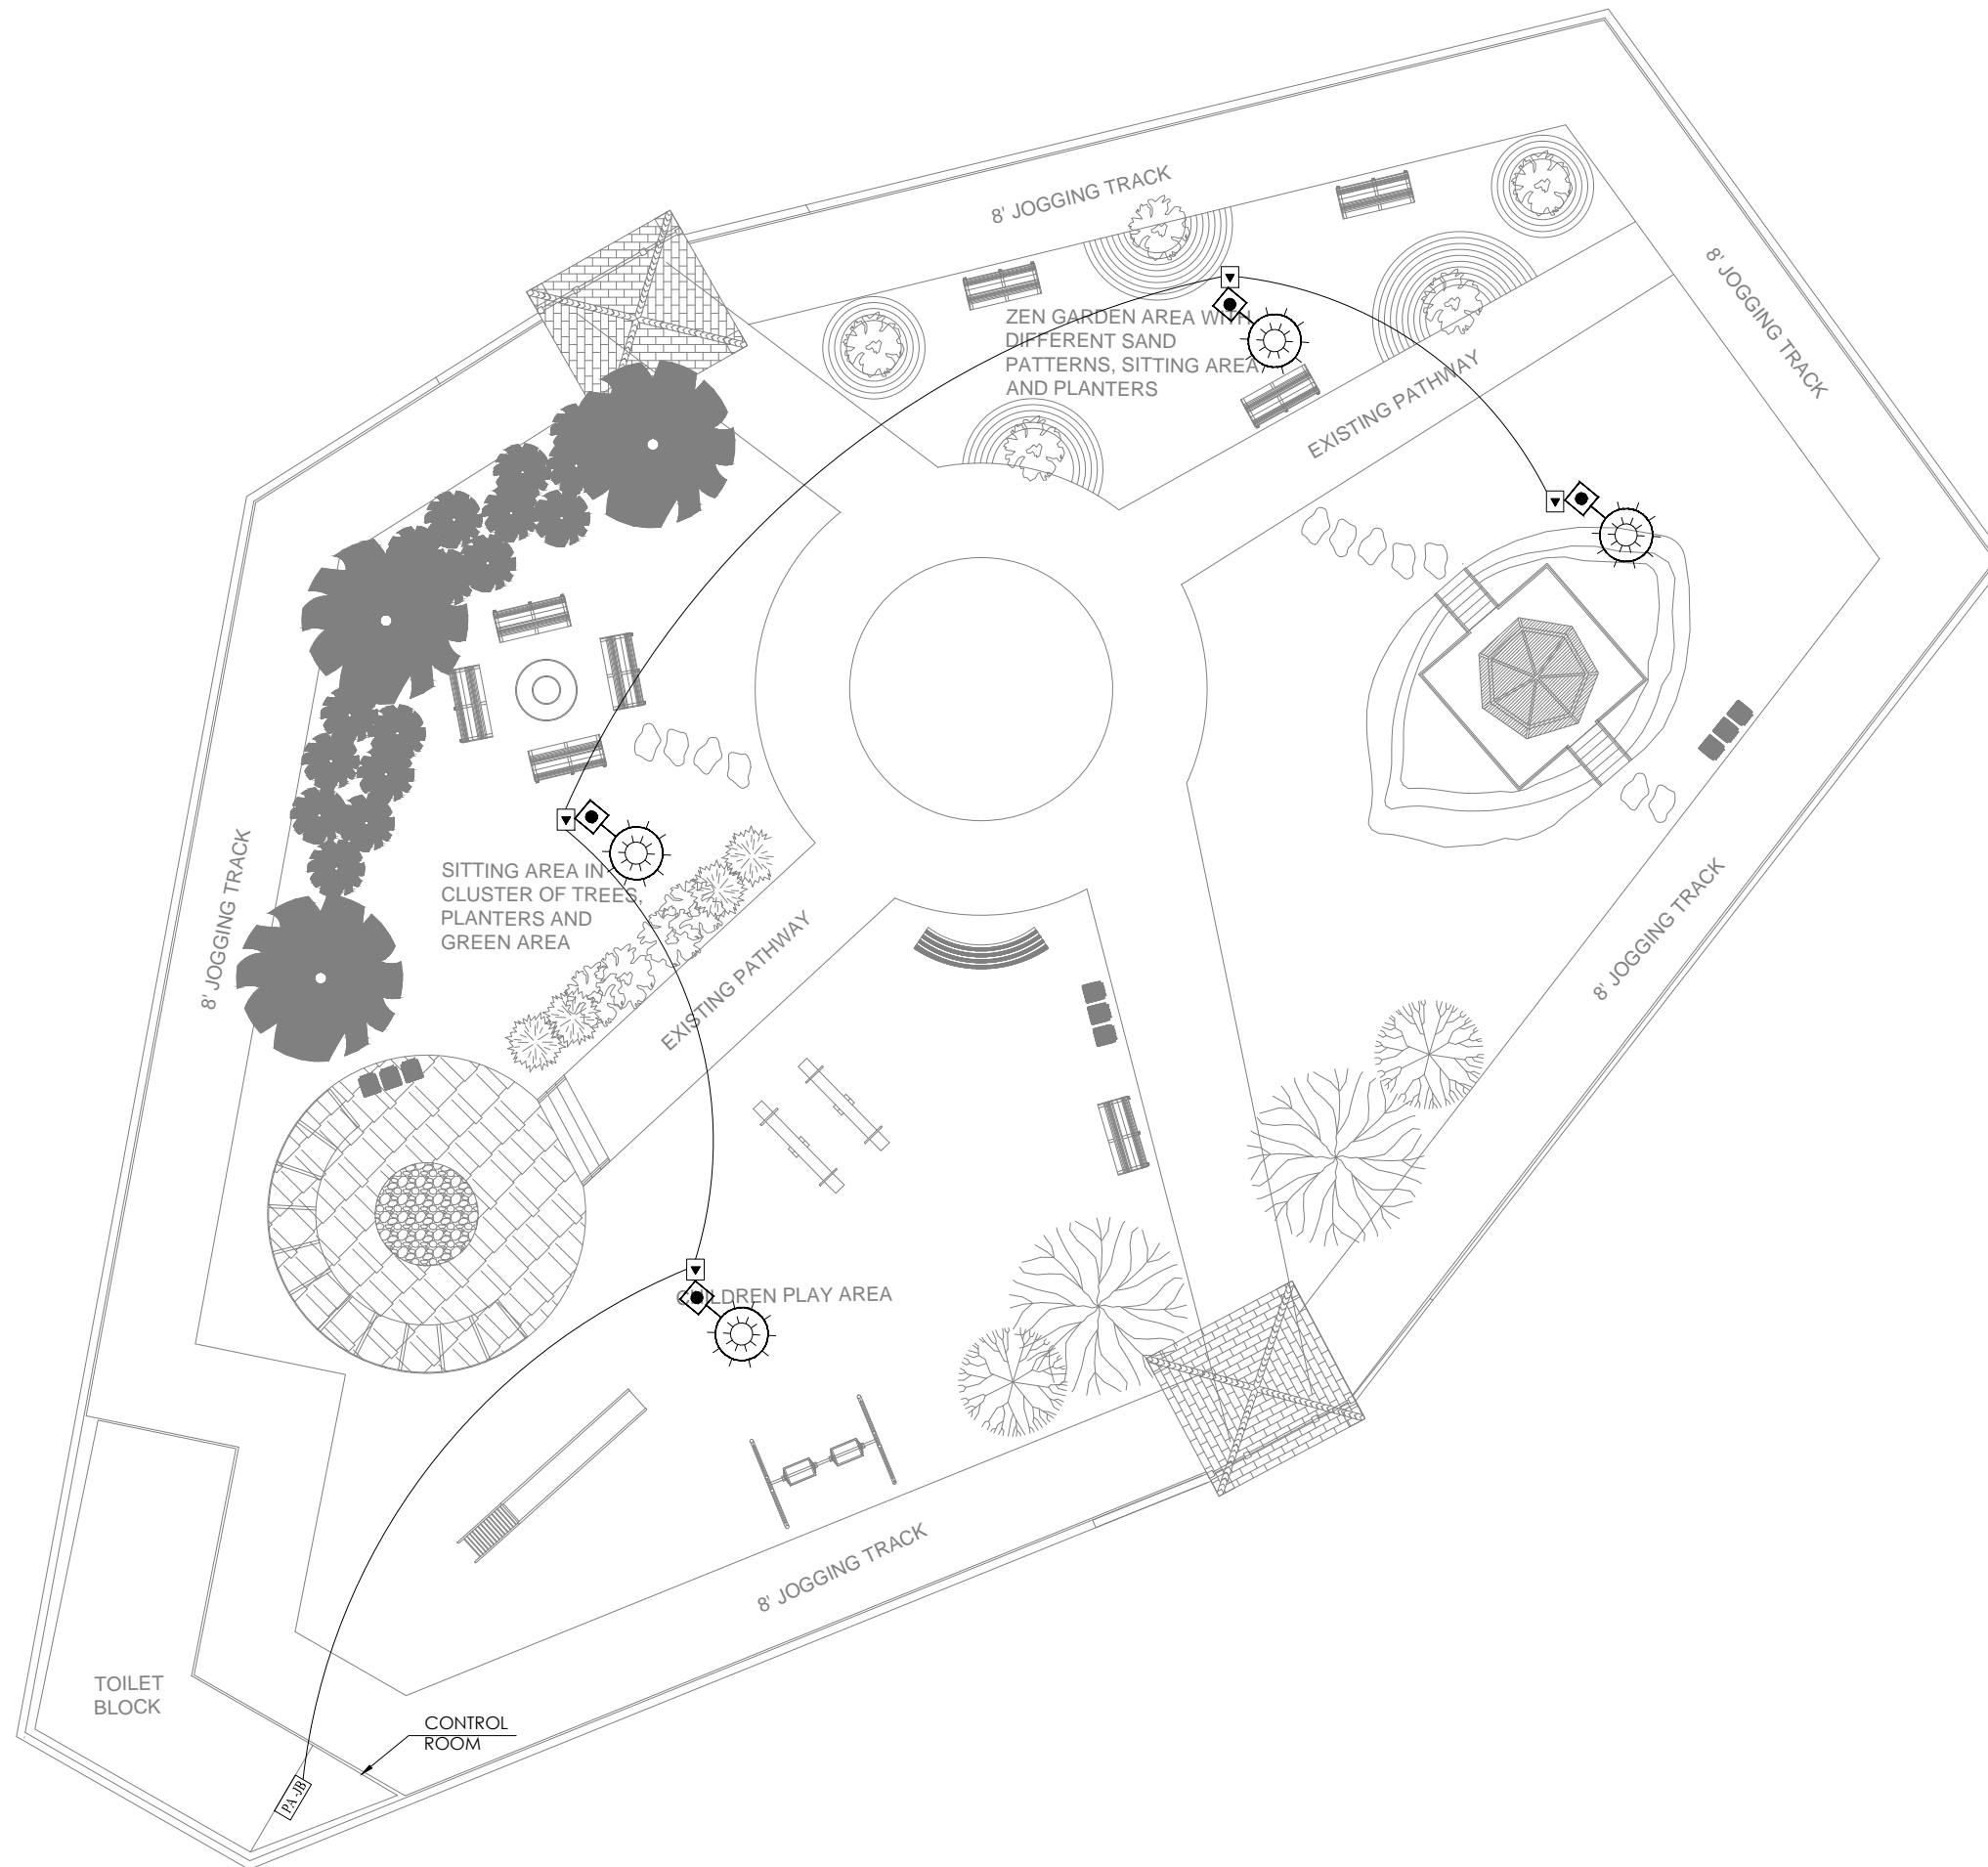

ALLAH RAKHA PARK — WORKING PLAN

CLIENT:



PROJECT  
IMPLEMENTATION  
UNIT (PIU) KNIP



CONSULTANTS:

G3 ENGINEERING  
CONSULTANTS (PVT) LTD.  
House No.57-M Gulberg-III, Lahore, Pakistan

Tel : (92-42) 35441641, 35441642  
Fax : (92-42) 35441645  
E-mail : info@g3ec.com  
URL : www.g3ec.com

PROJECT:

**Karachi Neighbourhood  
Improvement Project (KNIP)**

SUB PROJECT:

**Redevelopment of Kharadar  
Locality**

NOTES:

1. ALL DIMENSIONS ARE IN FEET UNLESS OTHERWISE SPECIFIED.
2. THIS DRAWING IS AN INTELLECTUAL PROPERTY OF G3 ENGINEERING CONSULTANTS (PVT.) LTD. AND CANNOT BE REPRINTED OR REPRODUCED WITHOUT PRIOR APPROVAL OF G3.

REVISIONS:

No.	DESCRIPTION	DATE

**TENDER DRAWINGS**

DRAWING TITLE:

**PARK  
PUBLIC ADDRESS SYSTEM**

DRAWN BY:

M.Raffeh

DATE:

SEP 2021

CHECKED BY:

Eng.Ghulam Daraz Shaikh

Approved BY:

Syed Ali Abbas Gillani

DRAWING NO:

0249/PARK/036

REV:


0

SCALE (A3):

N.T.S

SHEET:

00/00

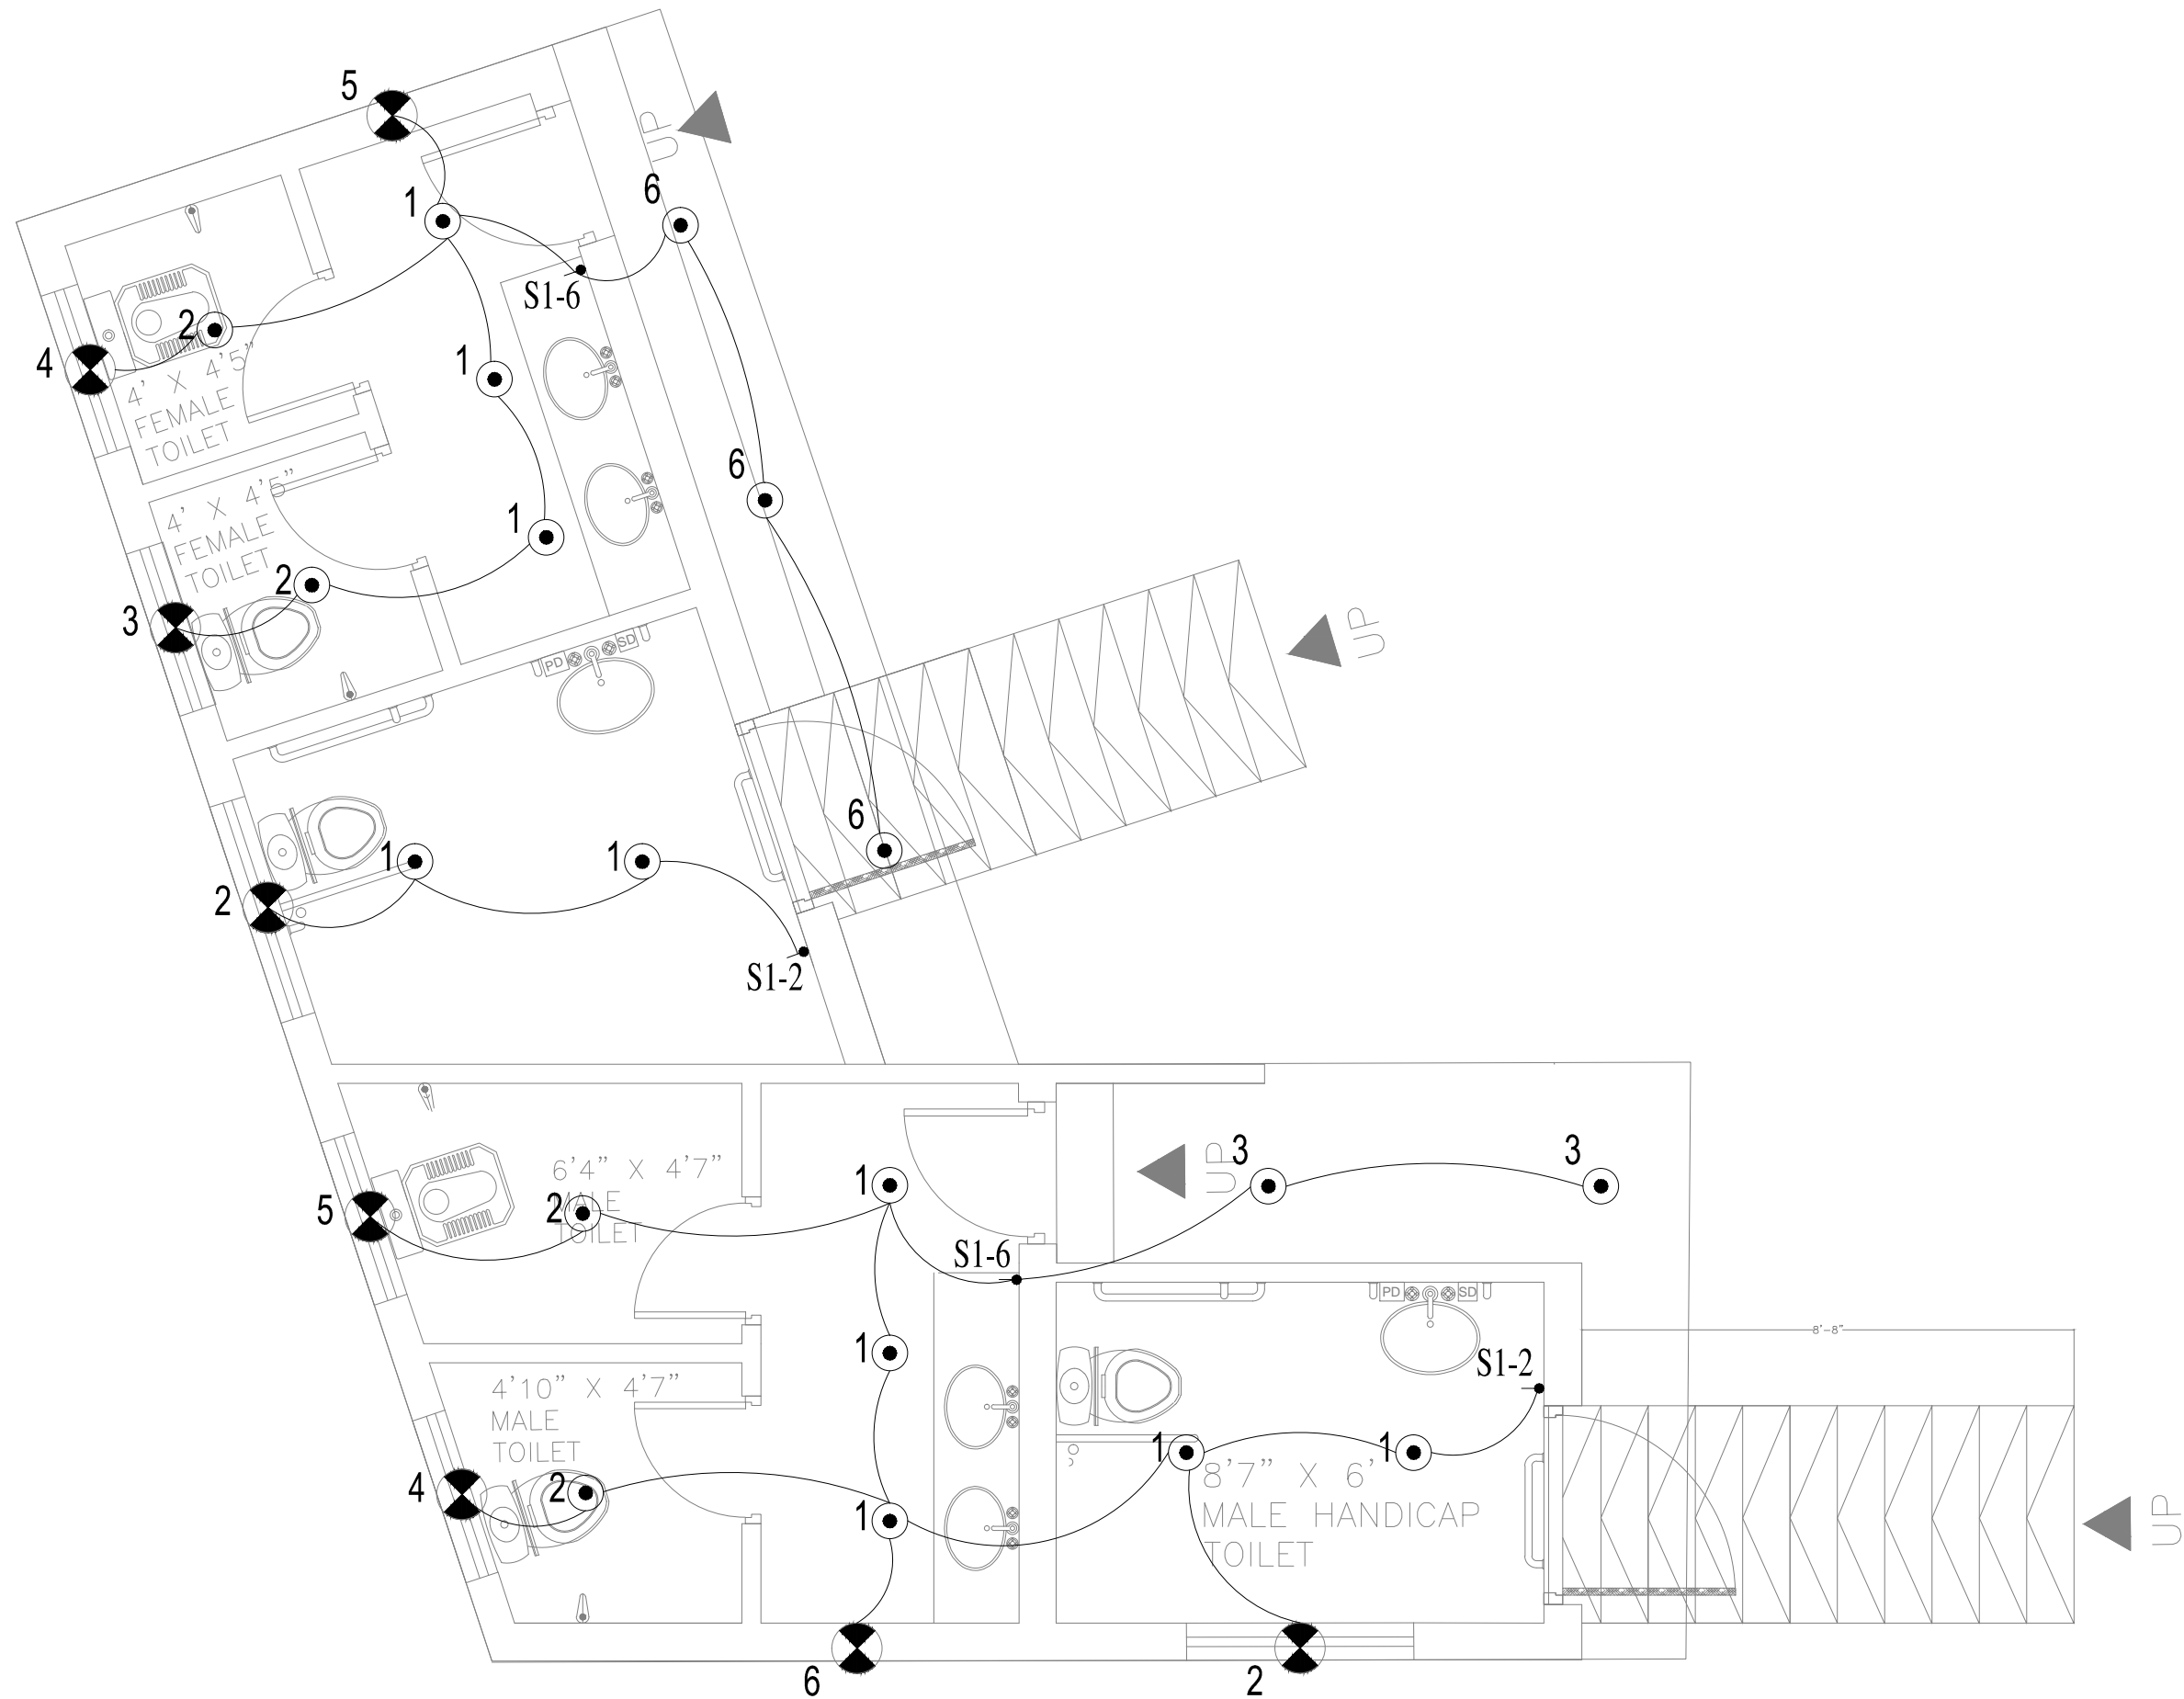

TOILET BLOCK WORKING PLAN

CLIENT:

 


PROJECT  
IMPLEMENTATION  
UNIT (PIU) KNIP



CONSULTANTS:

G3 ENGINEERING  
CONSULTANTS (PVT) LTD.  
House No.57-M Gulberg-III, Lahore, Pakistan



Tel : (92-42) 35441641, 35441642  
Fax : (92-42) 35441645  
E-mail : info@g3ec.com  
URL : www.g3ec.com

PROJECT:

**Karachi Neighbourhood  
Improvement Project (KNIP)**

SUB PROJECT:

**Redevelopment of Kharadar  
Locality**

NOTES:

1. ALL DIMENSIONS ARE IN FEET UNLESS OTHERWISE SPECIFIED.
2. THIS DRAWING IS AN INTELLECTUAL PROPERTY OF G3 ENGINEERING CONSULTANTS (PVT.) LTD. AND CANNOT BE REPRINTED OR REPRODUCED WITHOUT PRIOR APPROVAL OF G3.

REVISIONS:

No.	DESCRIPTION	DATE

**TENDER DRAWINGS**

DRAWING TITLE:

**TOILET BLOCK  
ILLUMINATION LAYOUT**

DRAWN BY:

M.Raffeh

DATE:

SEP 2021

CHECKED BY:

Eng.Ghulam Daraz Shaikh

Approved BY:

Syed Ali Abbas Gillani

DRAWING NO:

0249/TB/037

REV:

0


SCALE (A3):

N.T.S


SHEET:

00/00



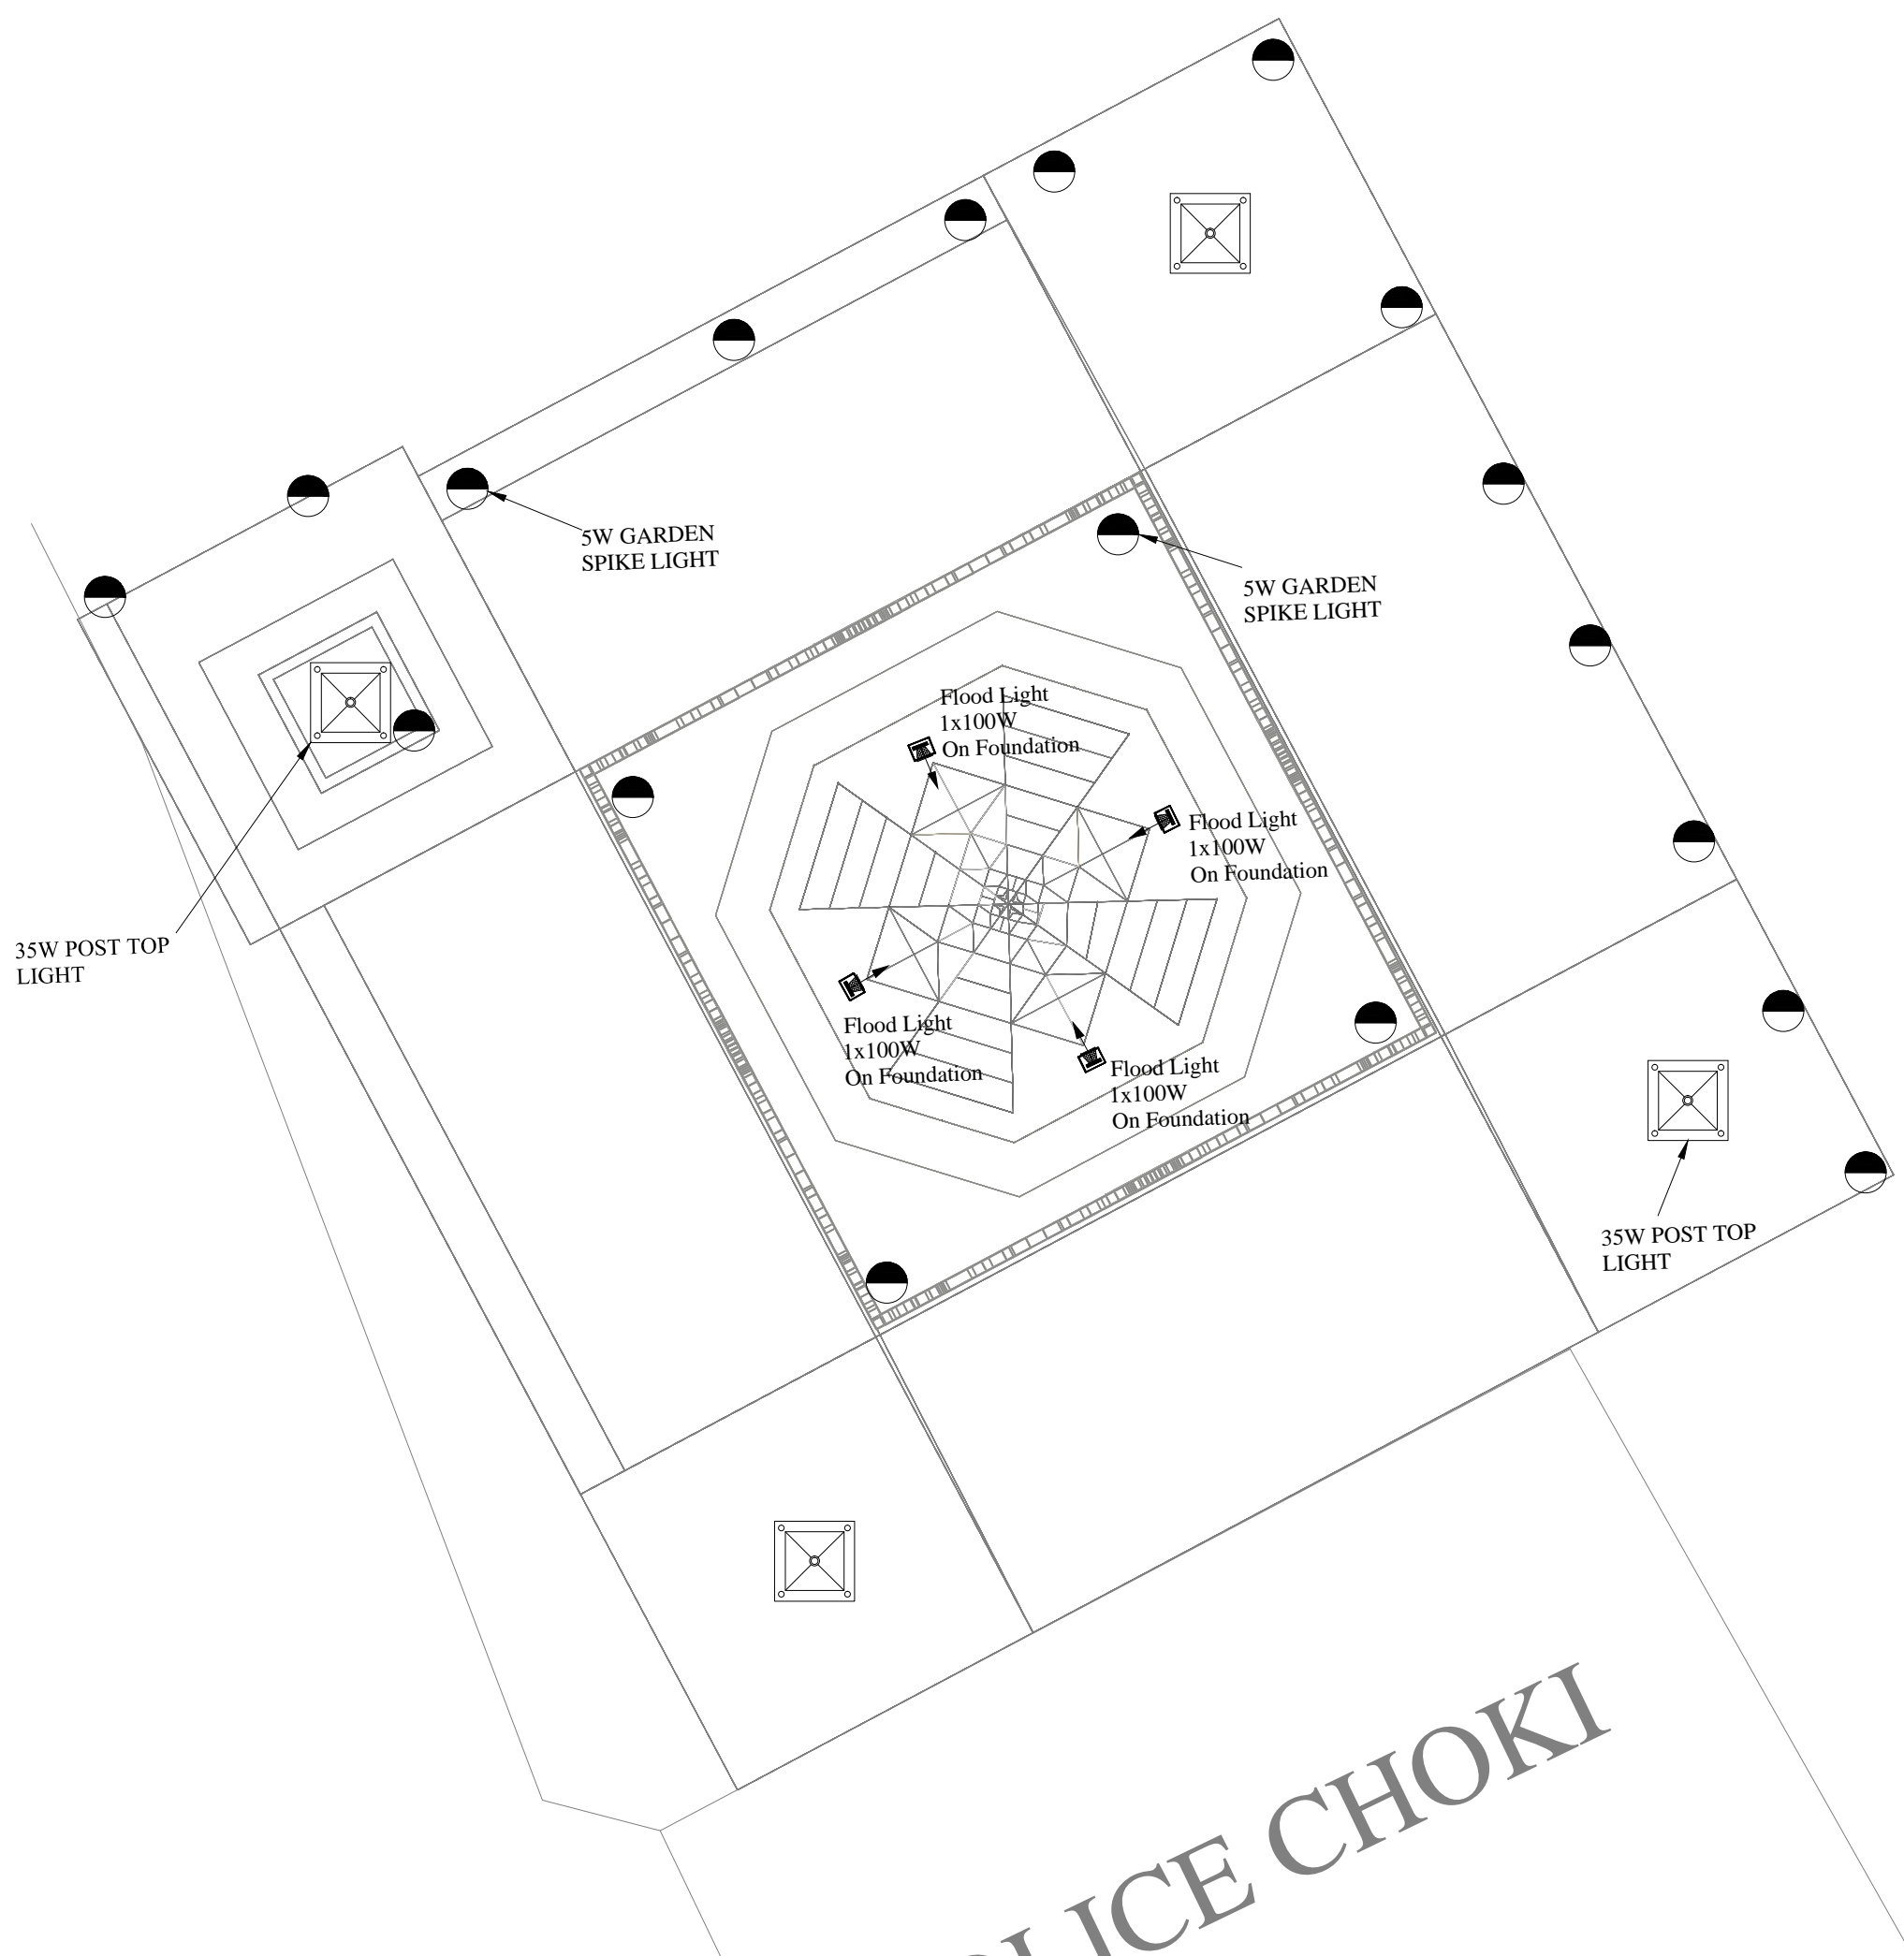

CLIENT:



**PROJECT  
IMPLEMENTATION  
UNIT (PIU) KNIP**



**CONSULTANTS:**  
**G3 ENGINEERING  
CONSULTANTS (PVT) LTD.**  
House No.57-M Gulberg-III, Lahore, Pakistan

Tel : (92-42) 35441641, 35441642  
Fax : (92-42) 35441645  
E-mail : info@g3ec.com  
URL : www.g3ec.com

**PROJECT:**  
**Karachi Neighbourhood  
Improvement Project (KNIP)**



**SUB PROJECT:**  
**Redevelopment of Kharadar  
Locality**

**NOTES:**  
1. ALL DIMENSIONS ARE IN FEET UNLESS  
OTHERWISE SPECIFIED.  
2. THIS DRAWING IS AN INTELLECTUAL PROPERTY  
OF G3 ENGINEERING CONSULTANTS (PVT.) LTD.  
AND CANNOT BE REPRINTED OR REPRODUCED  
WITHOUT PRIOR APPROVAL OF G3.

REVISIONS:		
No.	DESCRIPTION	DATE

**TENDER DRAWINGS**

DRAWING TITLE:  
**MONUMENT POLICE CHOKI**

DRAWN BY: <b>M.Raffeh</b>	DATE: <b>SEP 2021</b>
CHECKED BY: <b>Eng.Ghulam Daraz Shaikh</b>	
Approved BY: <b>Syed Ali Abbas Gillani</b>	
DRAWING NO: <b>0249/MO/038</b>	REV: <b>0</b>
SCALE (A3): <b>N.T.S</b>	SHEET: <b>00/00</b>



CLIENT:

PROJECT  
IMPLEMENTATION  
UNIT (PIU) KNIP



CONSULTANTS:

G3 ENGINEERING  
CONSULTANTS (PVT) LTD.  
House No.57-M Gulberg-III, Lahore, Pakistan



Tel : (92-42) 35441641, 35441642  
Fax : (92-42) 35441645  
E-mail : info@g3ec.com  
URL : www.g3ec.com

PROJECT:

Karachi Neighbourhood  
Improvement Project (KNIP)

SUB PROJECT:

Redevelopment of Kharadar  
Locality

NOTES:

1. ALL DIMENSIONS ARE IN FEET UNLESS OTHERWISE SPECIFIED.
2. THIS DRAWING IS AN INTELLECTUAL PROPERTY OF G3 ENGINEERING CONSULTANTS (PVT.) LTD. AND CANNOT BE REPRINTED OR REPRODUCED WITHOUT PRIOR APPROVAL OF G3.

REVISIONS:

No.	DESCRIPTION	DATE

TENDER DRAWINGS

DRAWING TITLE:

SINGLE LINE  
DIAGRAM

DRAWN BY:

M.Raffeh

DATE:

SEP 2021

CHECKED BY:

Eng.Ghulam Daraz Shaikh

Approved BY:

Syed Ali Abbas Gillani

DRAWING NO:

0249/SL/039

REV:

0



SCALE (A3):

N.T.S


 
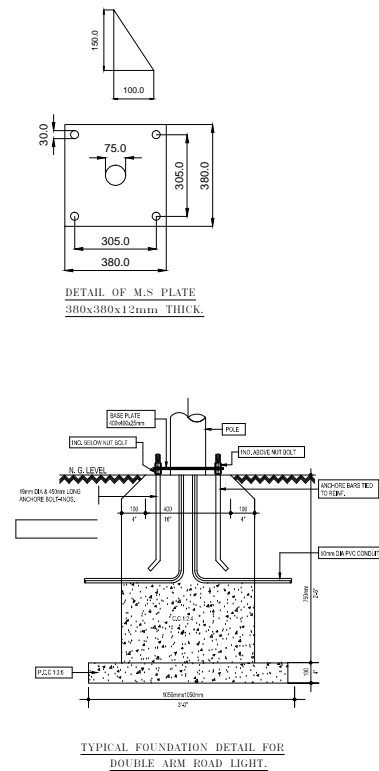
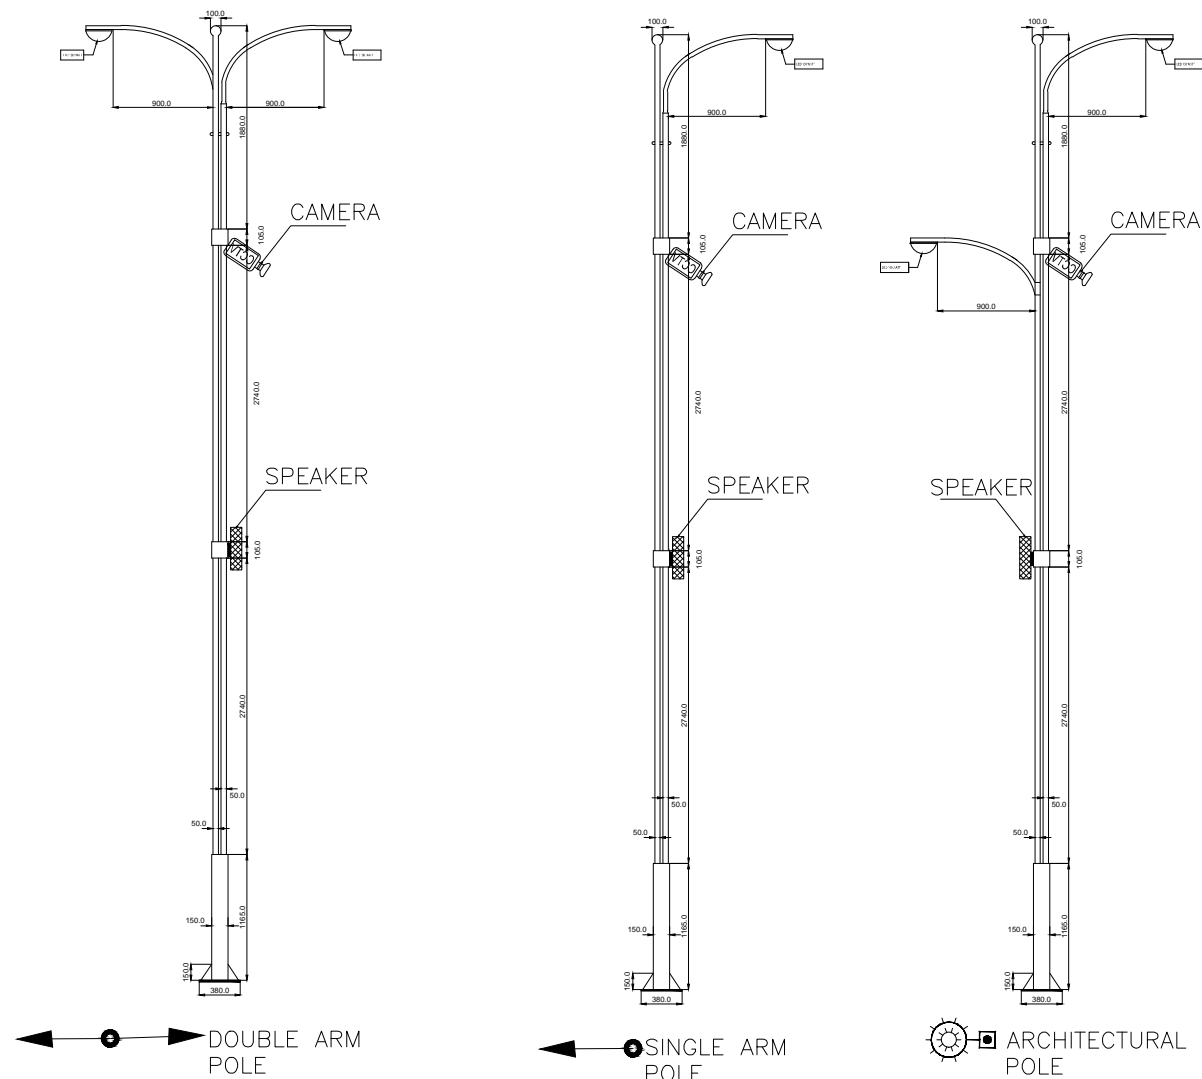
SHEET:

00/00


SINGLE LINE DIAGRAM OF:-  
(DBLP-GF), INSTALLED AT  
ST-09

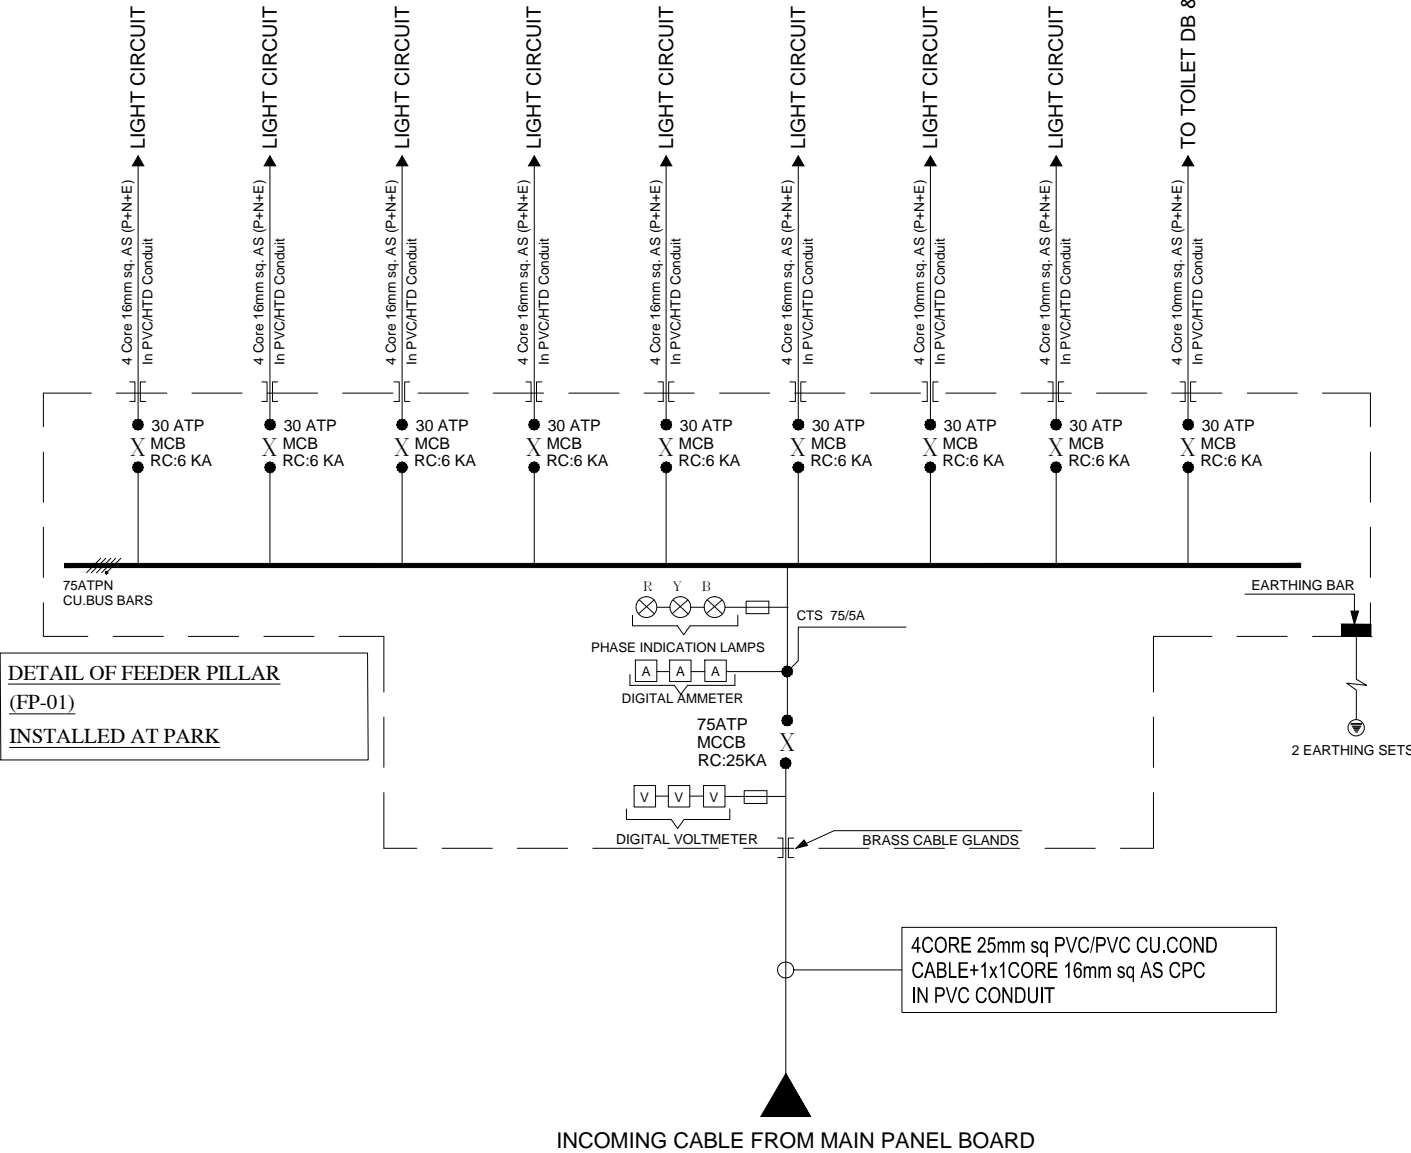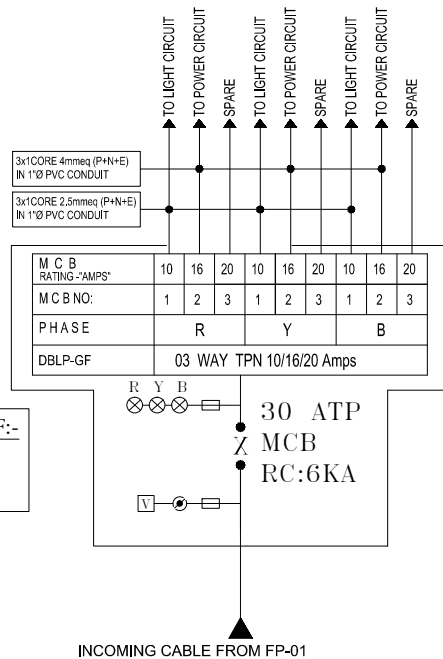

## LIGHTING DETAILS



JAPANESE LANTERN

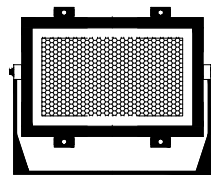

 LED FLOOD LIGHT 100 WATT



LED BOLLARD LIGHT

● OUTDOOR GARDEN SPIKE LIGHT

 POST TOP LED LIGHT

CLIENT:



PROJECT  
IMPLEMENTATION  
UNIT (PIU) KNIP



CONSULTANTS:

**G3 ENGINEERING  
CONSULTANTS (PVT)LTD.**  
House No.57-M Gulberg-III, Lahore, Pakistan

Tel : (92-42) 35441641, 35441642  
Fax : (92-42) 35441645  
E-mail : [info@g3ec.com](mailto:info@g3ec.com)  
URL : [www.g3ec.com](http://www.g3ec.com)

PROJECT:

## Karachi Neighbourhood Improvement Project (KNIP)

SUB PROJECT:

### Redevelopment of Kharadar Locality

NOTES:

1. ALL DIMENSIONS ARE IN FEET UNLESS OTHERWISE SPECIFIED.
2. THIS DRAWING IS AN INTELLECTUAL PROPERTY OF G3 ENGINEERING CONSULTANTS (PVT.) LTD. AND CANNOT BE REPRINTED OR REPRODUCED WITHOUT PRIOR APPROVAL OF G3.

REVISIONS:

[illegible]

TENDER DRAWINGS

DRAWING TITLE:

## LIGHTING DETAILS

DRAWN BY:

M.Raffeh

CHECKED BY:  
Eng.Ghulam Daraz Shaikh

Approved BY:  
Syed Ali Abbas Gillani

DRAWING NO:

0249/LD/040

SCALE (A3):

N.T.S

DATE:  
SEP 2021

aikh

---

EV:

0

HEET: 00/00